



PARTNERS in Architecture, PLC

65 MARKET STREET  
MOUNT CLEMENS, MI 48043  
P 586.469.3000  
F 586.469.3057

Statement of Intellectual Property

The ideas, concepts, drawings and thoughts conveyed herein are the intellectual property of PARTNERS in Architecture, PLC, 65 Market Street, Mount Clemens, MI 48043 (P 586.469.3000). This set of drawings, in whole or in part, may not be reproduced, without the written consent of PARTNERS in Architecture, PLC. This information is protected under U.S. Copyright Law, all rights reserved.


© Copyright 2016

CONSULTANT



MEEC JOB # 1617107

KEY PLAN

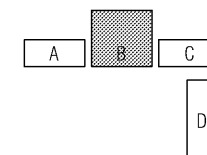

OWNER

Suwanee Grocery, LLC

8110 N. Saint Louis Avenue  
Skokie, IL 60076

PROJECT NAME

Suwanee Grocery, LLC  
Building-B Build-Out

3230 Caliber Street  
Suwanee, GA 30024

PROJECT NO.

16-177

ISSUES / REVISIONS

Bidding - Construction 04/30/18

DRAWN BY

WEV

CHECKED BY

WEV

APPROVED BY


JFB

SHEET NAME

HVAC -  
FLOOR PLAN

SHEET NO.

M1-01

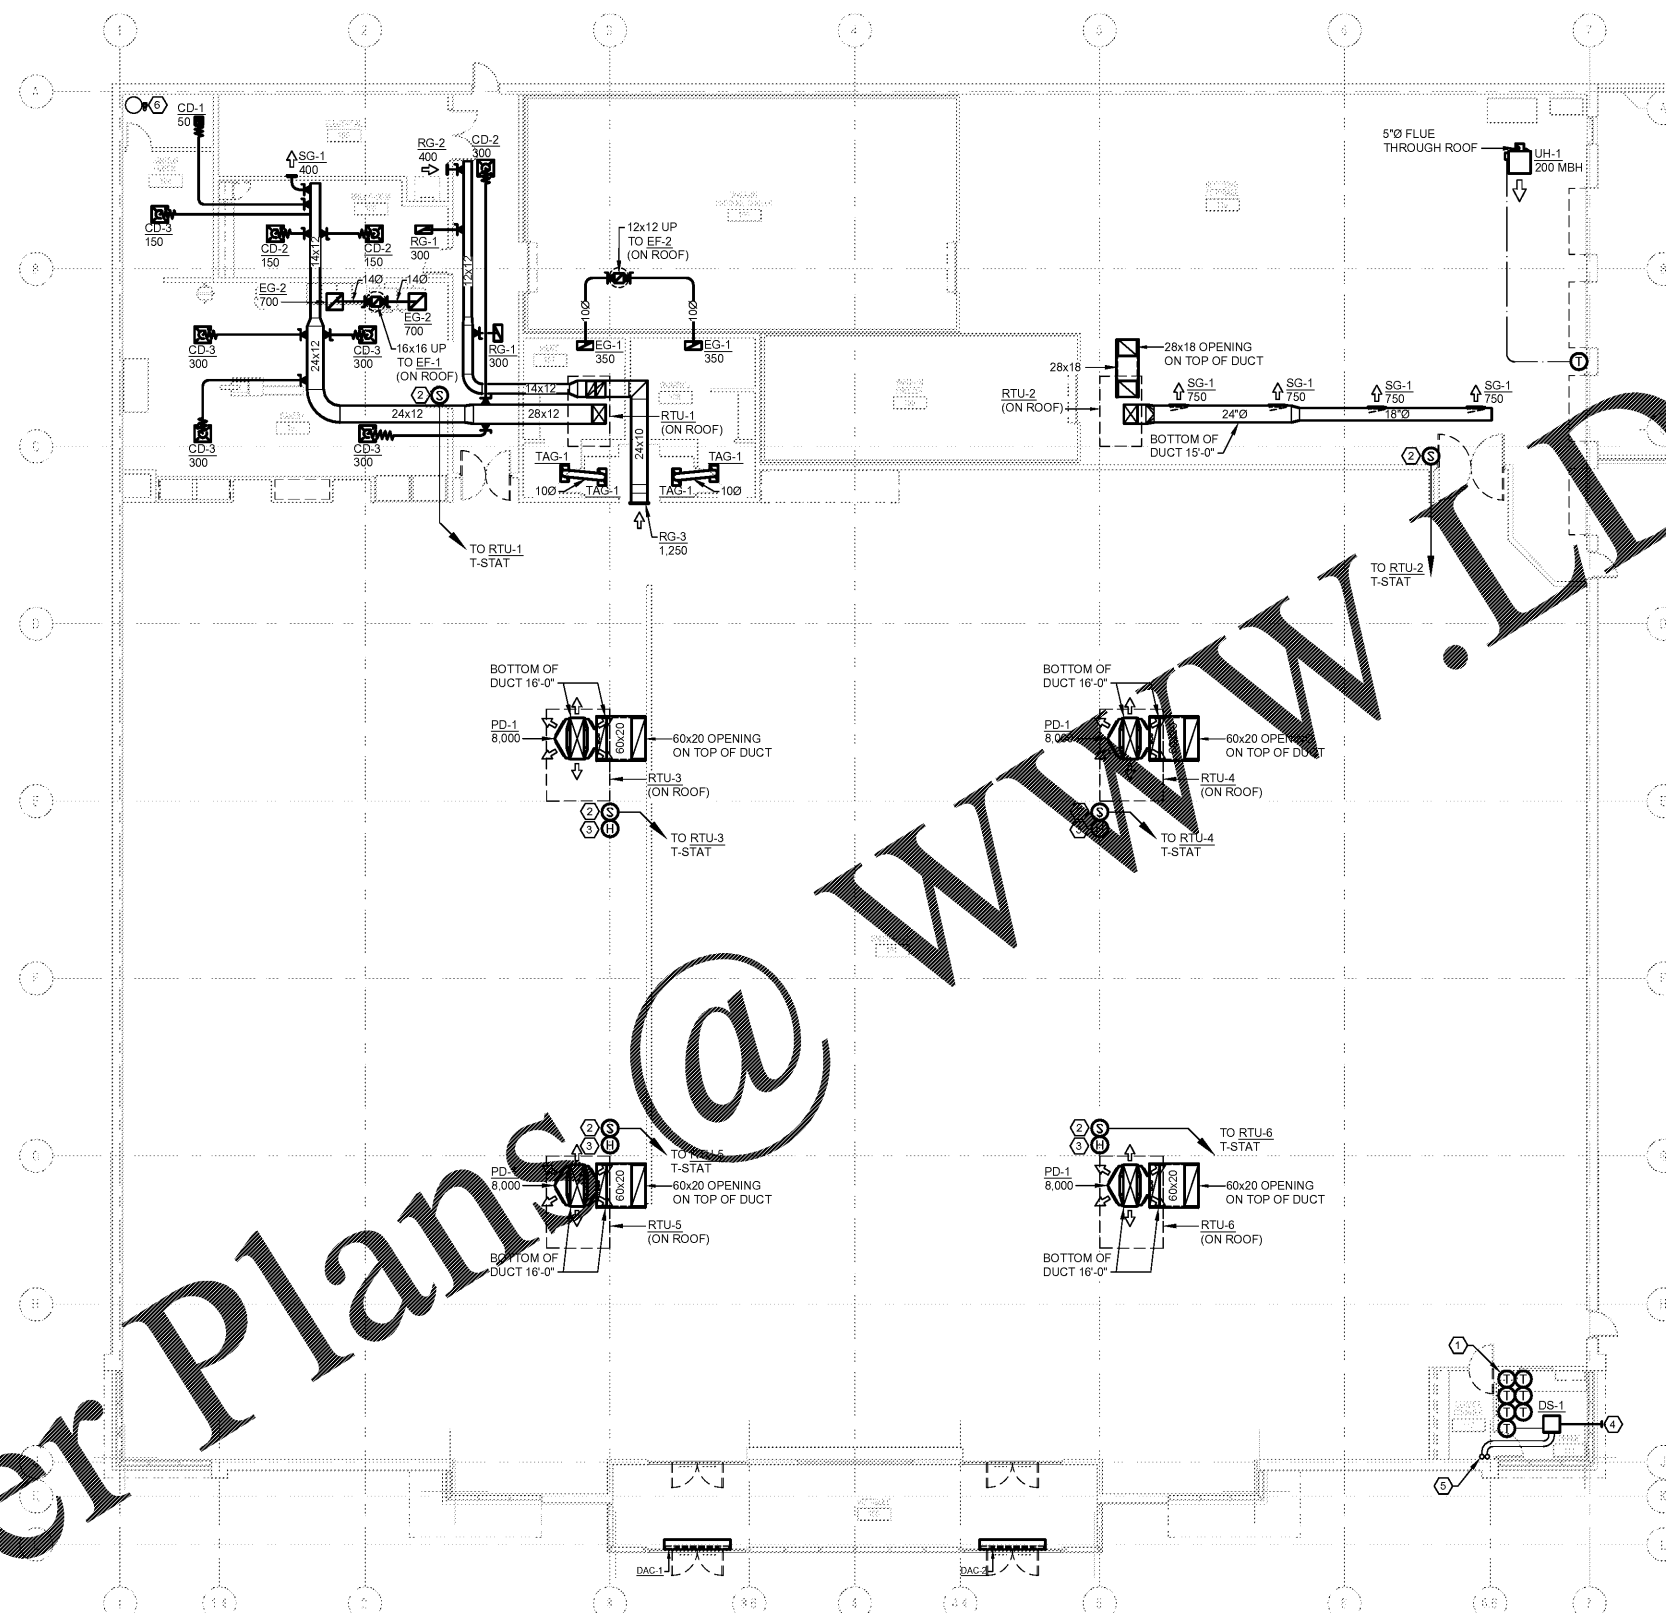

KEYED NOTES: (6)

- (6) ROOFTOP UNIT PROGRAMMABLE DIGITAL THERMOSTATS TO BE LOCATED ON OFFICE WALL. COORDINATE FINAL INSTALLED LOCATION IN FIELD.
- ROOFTOP UNIT REMOTE SPACE TEMPERATURE SENSOR.
- ROOFTOP UNIT DEHUMIDIFICATION CONTROL HUMIDITY SENSOR LOCATED NEXT TO SPACE TEMPERATURE SENSOR IN THIS LOCATION.
- 4" Ø OUTDOOR AIR INTAKE DUCT THROUGH EXTERIOR WALL WITH IMPERIAL MODEL VT0744 BROWN INTAKE HOOD.
- REFRIGERANT LIQUID AND SUCTION LINE SET UP ALONG WALL AND THROUGH ROOF TO HEAT PUMP MOUNTED ON ROOF.
- WATER HEATER 3" Ø FLUE & COMBUSTION AIR PVC PIPE UP TO CONCENTRIC VENT THROUGH ROOF.

1 HVAC - Floor Plan  
3/32" = 1'-0"

Order Plans @ WWW.LDILine.com