

GENERAL NOTES

REFER TO SHEET MP1 FOR GENERAL NOTES PERTAINING TO THIS SHEET


KEYNOTES

15.406 PLUMBING CONTRACTOR TO MAKE ALL NECESSARY DISCONNECTS AND RECONNECTS OF PLUMBING FIXTURES BEING RELOCATED OR NEW



1701 S. GILES RD. SUITE 100 GORDONSVILLE, VA 22983 (800) 525-2223 www.walgreens.com

STIPULATION FOR THE CONTRACTOR: THE CONTRACTOR SHALL VERIFY ALL EXISTING CONDITIONS AND VERIFY ALL UTILITIES ARE CORRECTLY LOCATED AND DEPTHS ARE AS SHOWN ON ALL EXISTING RECORD DRAWINGS. THE CONTRACTOR SHALL BE RESPONSIBLE FOR OBTAINING ALL NECESSARY PERMITS AND APPROVALS FROM ALL APPLICABLE AGENCIES. THE CONTRACTOR SHALL BE RESPONSIBLE FOR OBTAINING ALL NECESSARY PERMITS AND APPROVALS FROM ALL APPLICABLE AGENCIES. THE CONTRACTOR SHALL BE RESPONSIBLE FOR OBTAINING ALL NECESSARY PERMITS AND APPROVALS FROM ALL APPLICABLE AGENCIES.

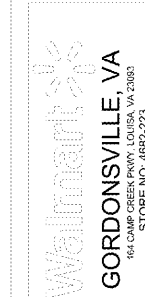

ISSUE BLOCK

Table with 2 columns: Description, Date. Currently empty.

CHECKED BY: RRP
DRAWN BY: COL
PROTO CYCLE: 02/23/18
DOCUMENT DATE: 04/10/18
BG PROJECT NO: 19532


This document originally issued and revised by Roy R. Payne, Jr., P.E. 6039966 on 04/08/2018. This document should not be considered a certified document. NOT FOR CONSTRUCTION

EXISTING CONDITIONS WERE TAKEN FROM ORIGINAL DRAWINGS AND MAY NOT REFLECT EXACT "AS-BUILT" CONDITIONS. CONTRACTOR SHALL FIELD VERIFY ALL EXISTING CONDITIONS PRIOR TO SUBMITTING FINAL BIDS. CONTRACTOR SHALL CAREFULLY COORDINATE NEW WORK AND DEMOLITION WITH ALL OTHER DISCIPLINES AND EXISTING CONDITIONS.

EACH SUBCONTRACTOR IS RESPONSIBLE FOR HAVING A THOROUGH KNOWLEDGE OF ALL DRAWINGS AND SPECIFICATIONS IN THEIR RELATED FIELD. THE FAILURE TO ACQUAINT THEMSELVES WITH THIS KNOWLEDGE DOES NOT RELIEVE THE RESPONSIBILITY OF PERFORMING THE WORK PROPERLY. NO ADDITIONAL COMPENSATION SHALL BE ALLOWED BECAUSE OF CONDITIONS THAT OCCUR DUE TO FAILURE TO FAMILIARIZE WORKERS WITH THIS KNOWLEDGE.

GROCERY PLUMBING PLANS

SHEET: GP1

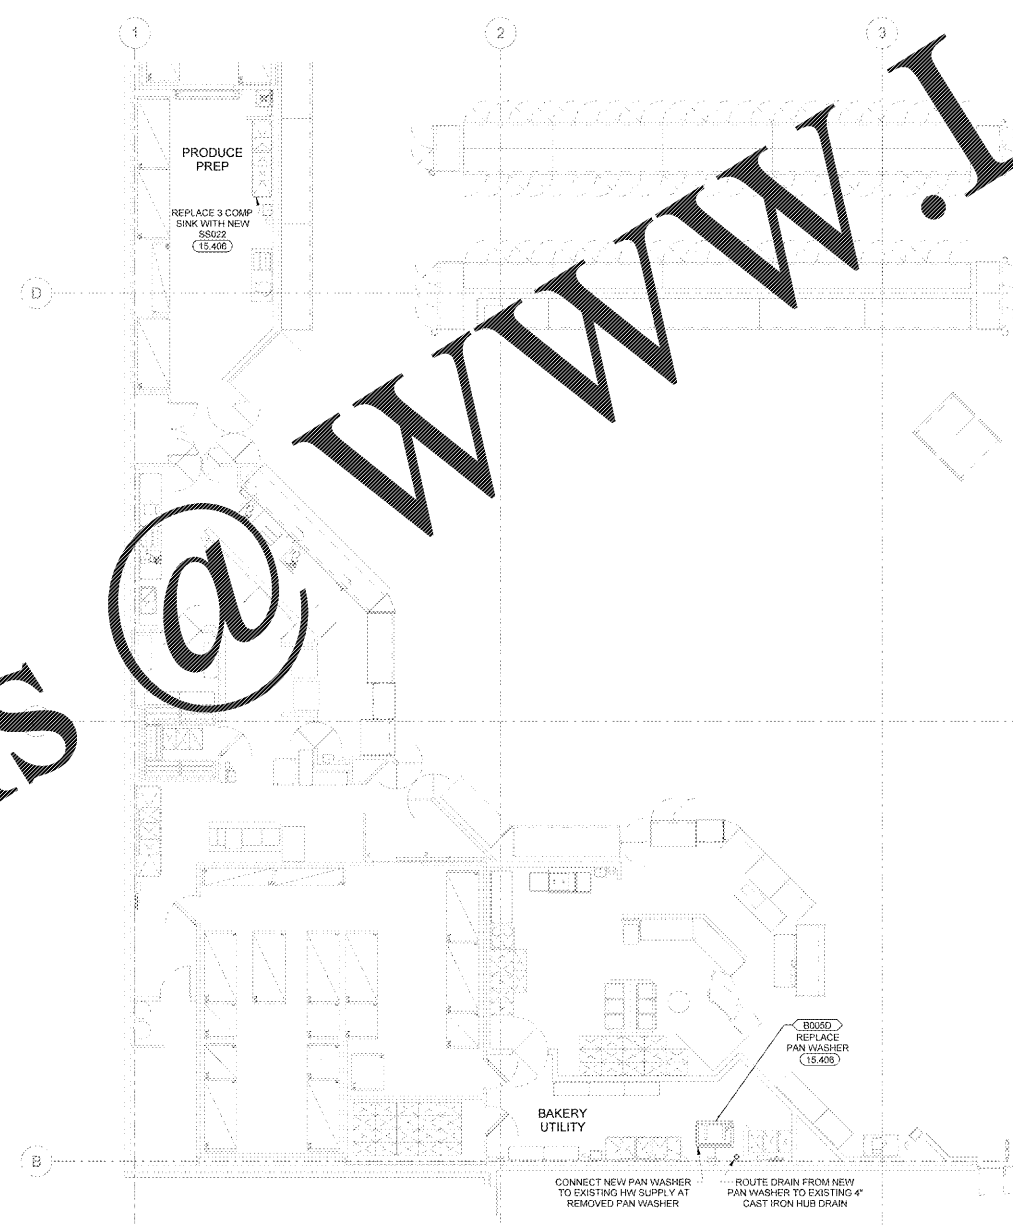

1 FRONT GROCERY PLUMBING PLAN
1/8" = 1'-0"

Order Plans @ www.LDILine.com