

| LUMINAIRE SCHEDULE | | | | | |
|--------------------|--------|--------------|---|-----------------------------------|------------|
| CALLOUT | SYMBOL | LAMP | DESCRIPTION | MODEL | VOLTS |
| A | | (1) 40W LED | 2x4 LED RECESSED TROFFER | LITHONIA 2GTL-4-40L-EZ1 | 120V 1P 2W |
| AE | | (1) 40W LED | 2x4 LED RECESSED TROFFER WITH EMERGENCY BATTERY | LITHONIA 2GTL-4-40L-EZ1 EL7L | 120V 1P 2W |
| D5 | | (1) | SIGN DOWN LIGHT | TO BE SELECTED | 120V 1P 2W |
| E | | (1) LED | ROUND CEILING LIGHTING | TO BE SELECTED | 120V 1P 2W |
| S | | (1) | EXTERIOR SCONCE | TO BE SELECTED | 120V 1P 2W |
| T | | (2) 1.5W LED | EMERGENCY LIGHTING UNIT | LITHONIA ELM2-LED | 120V 1P 2W |
| W | | (1) 32W LED | EXTERIOR WALL PACK | LITHONIA TWR1-LED-1-40K-MVOLT | 120V 1P 2W |
| X | | (1) 5W LED | THERMOPLASTIC EXIT SIGN WITH BACKUP BATTERY | LITHONIA LQM-S-W-3-R-120/E77-EL-N | 120V 1P 2W |
| XC | | (2) 1.5W LED | COMBINATION EXIT/EMERGENCY LIGHTING UNIT | LITHONIA LHQM-LED-R-HO | 120V 1P 2W |
| XR | | (1) INCLUDED | REMOTE LAMP HEAD | LITHONIA ELA-GWP-LO509-5D | 120V 1P 2W |

GENERAL NOTES

- REFER TO ARCHITECTURAL REFLECTED CEILING PLAN FOR EXACT LOCATIONS OF ALL CEILING MOUNTED DEVICES.
- PROVIDE UNSWITCHED HOT LEG OF CIRCUIT TO EMERGENCY LIGHTING AND EXIT SIGNS.
- EXTERIOR FIXTURES TO BE ON LIGHTING CONTRACTOR WITH PHOTOCELL AND TIMER.

KEYNOTES

- Ⓛ EXISTING EXHAUST FANS TO BE SWITCHED WITH LIGHTS.
- Ⓧ DOWN LIGHTING FOR SIGNAGE.



Miller
Architecture and Planning

6534 Spring Street, Douglasville, GA 30134
678-715-1586 | millerap.com | info@millerap.com

The drawings herein represent the physical and intellectual property of Miller Architecture and Planning and may not be reproduced or transmitted in any form without the prior written consent of said firm.

GENERAL CONSTRUCTION NOTES:

- THE CONTRACTOR SHALL GUARANTEE TO THE OWNER ALL WORKMANSHIP AND MATERIALS, WHETHER FURNISHED BY THE CONTRACTOR OR SUB-CONTRACTORS, AGAINST DEFECTS FOR A MINIMUM PERIOD OF ONE (1) YEAR AFTER THE DATE OF FINAL ACCEPTANCE BY OWNER. FAILURE OF ANY SUCH ITEMS SHALL BE MADE GOOD BY THE CONTRACTOR AT THE CONTRACTOR'S OWN EXPENSE.
- THE CONTRACTOR SHALL TAKE ALL NECESSARY PRECAUTIONS TO PROTECT FROM DAMAGE OR DESTRUCTION ALL EXISTING MATERIALS AND FINISHES TO REMAIN IN ADJACENT OR NEARBY AREAS. THE CONTRACTOR SHALL REPLACE ANY DAMAGED OR DESTROYED ITEMS BY OPERATIONS UNDER THIS CONTRACT.
- PRODUCTS, TRADE NAMES AND/OR MANUFACTURERS NOTED WITHIN THESE DOCUMENTS ARE PROVIDED TO ESTABLISH A STANDARD OF QUALITY. UNLESS OTHERWISE INDICATED, APPROVED EQUAL PRODUCTS OF ANOTHER MANUFACTURER MAY BE USED WITH THE WRITTEN PERMISSION OF THE ARCHITECT. IT IS THE RESPONSIBILITY OF THE CONTRACTOR AND SUPPLIER TO PROVE TO THE ARCHITECT BEFORE THE DATE OF BID THAT THEIR PRODUCT IS EQUAL TO OR BETTER THAN THOSE PRODUCTS SPECIFIED. IF AN "OR EQUAL" PRODUCT IS USED, IT IS THE RESPONSIBILITY OF THE CONTRACTOR TO MAKE ANY NECESSARY CHANGES TO THE STRUCTURE AND INTERIOR LAYOUT AT THE CONTRACTOR'S OWN EXPENSE, AFTER OBTAINING THE ARCHITECT'S ACCEPTANCE OF SUCH CHANGES.
- THE CONTRACTOR SHALL COORDINATE WITH THE OWNER A DESIGNATED SITE OR SITES FOR STORAGE OF MATERIALS AND EQUIPMENT FOR THE DURATION OF THE CONSTRUCTION CONTRACT.
- DIMENSIONS SHOWN ON THE DRAWINGS ARE TO ROUGH SURFACES, EXCLUSIVE OF FINISH MATERIALS, EXCEPT AS NOTED OTHERWISE. DO NOT SCALE THE DRAWINGS.
- THE CONTRACTOR SHALL COMPLY WITH ALL RELEVANT AND CURRENTLY ENFORCED BUILDING CODES BY ALL GOVERNING JURISDICTIONS, INCLUDING BUT NOT LIMITED TO ALL PROVISIONS OF THE AMERICAN WITH DISABILITIES ACT.

The contractor shall be responsible for all fees and obtaining all necessary and relevant permits and approvals relating to staging and construction of this project. The contractor shall comply with all relevant building, construction and work safety codes. The contractor shall verify all dimensions and elevations in the field before starting work and immediately report to the architect any discrepancies discovered.




DOUGLAS COUNTY FIRE STATION 3

CLIENT: Owner

DRAWING TITLE: FLOOR PLAN - LIGHTING

ISSUANCE: DATE: DRAWING NO: E-12

COMMISSION: Project Number: DRAWN BY: DC

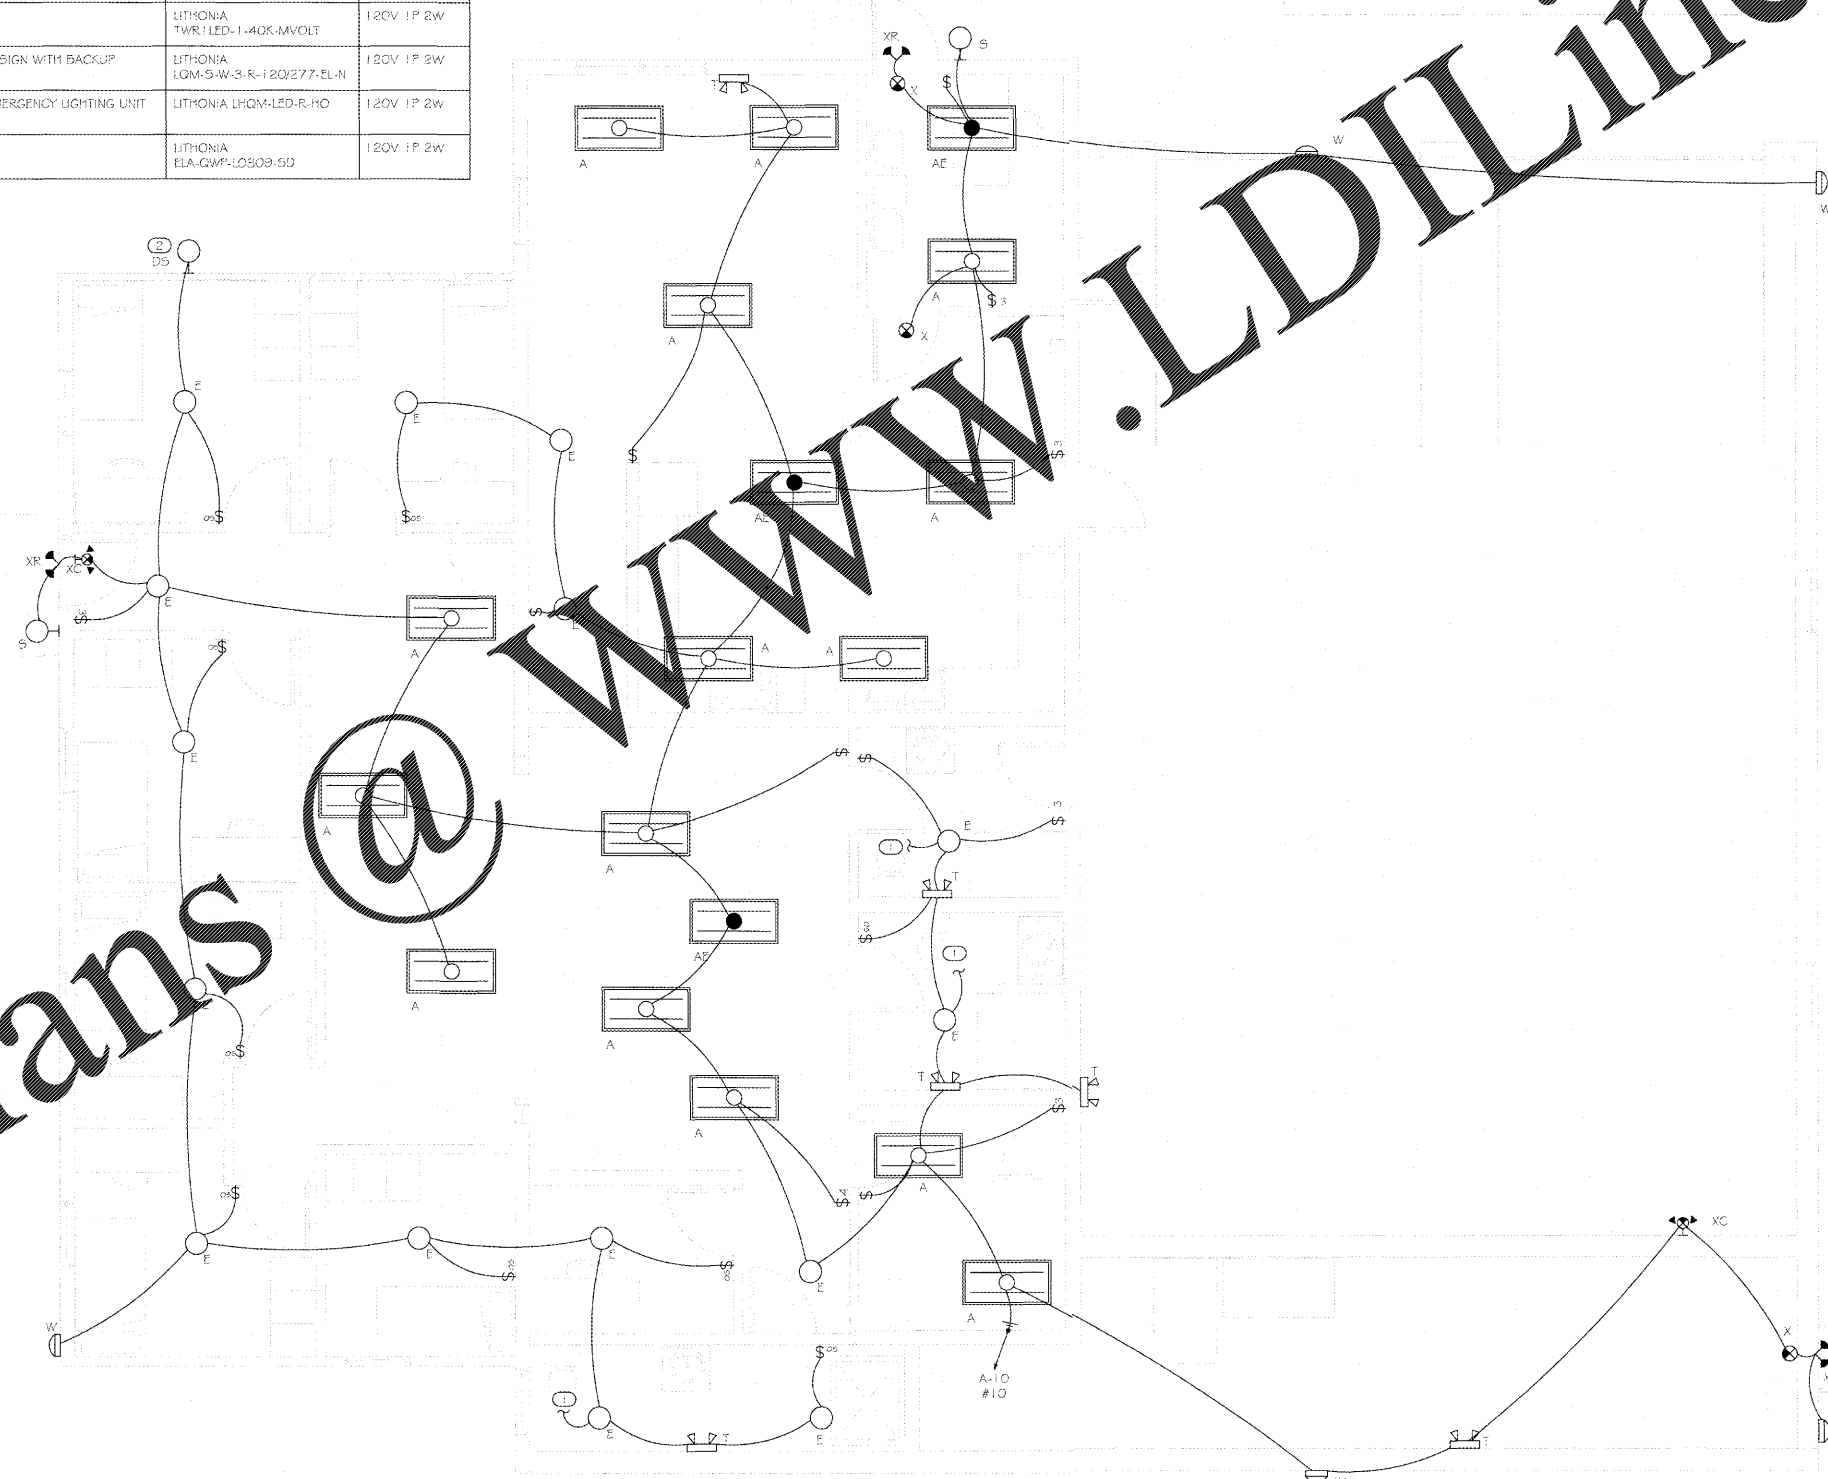

1 FLOOR PLAN - LIGHTING
E-12 1/4" = 1'-0"

Order Plans