

LUMINAIRE SCHEDULE					
CALLOUT	SYMBOL	LAMP	DESCRIPTION	MODEL	VOLTS
A		(1) 40W LED	2x4 LED RECESSED TROFFER	LITHONIA 2GTL-4-40L-EZ1	120V 1P 2W
AE		(1) 40W LED	2x4 LED RECESSED TROFFER WITH EMERGENCY BATTERY	LITHONIA 2GTL-4-40L-EZ1 EL7L	120V 1P 2W
DS		(1)	SIGN DOWN LIGHT	TO BE SELECTED	120V 1P 2W
E		(1) LED	ROUND CEILING LIGHTING	TO BE SELECTED	120V 1P 2W
S		(1)	EXTERIOR SCONCE	TO BE SELECTED	120V 1P 2W
T		(2) 1.5W LED	EMERGENCY LIGHTING UNIT	LITHONIA ELA2-LED	120V 1P 2W
W		(1) 32W LED	EXTERIOR WALL PACK	LITHONIA TWR1-LED-1-40K-MVOLT	120V 1P 2W
X		(1) 5W LED	THERMOPLASTIC EXIT SIGN WITH BACKUP BATTERY	LITHONIA LQM-S-W-3-R-120/E77-EL-N	120V 1P 2W
XC		(2) 1.5W LED	COMBINATION EXIT/EMERGENCY LIGHTING UNIT	LITHONIA LHQM-LED-R-HO	120V 1P 2W
XR		(1) INCLUDED	REMOTE LAMP HEAD	LITHONIA ELA-GWP-LO509-5D	120V 1P 2W

GENERAL NOTES

- REFER TO ARCHITECTURAL REFLECTED CEILING PLAN FOR EXACT LOCATIONS OF ALL CEILING MOUNTED DEVICES.
- PROVIDE UNSWITCHED HOT LEG OF CIRCUIT TO EMERGENCY LIGHTING AND EXIT SIGNS.
- EXTERIOR FIXTURES TO BE ON LIGHTING CONTRACTOR WITH PHOTOCELL AND TIMER.

KEYNOTES

- Ⓛ EXISTING EXHAUST FANS TO BE SWITCHED WITH LIGHTS.
- Ⓧ DOWN LIGHTING FOR SIGNAGE.



Miller
Architecture and Planning

6534 Spring Street, Douglasville, GA 30134
678-715-1586 | millerap.com | info@millerap.com

The drawings herein represent the physical and intellectual property of Miller Architecture and Planning and may not be reproduced or transmitted in any form without the prior written consent of said firm.

GENERAL CONSTRUCTION NOTES:

- THE CONTRACTOR SHALL GUARANTEE TO THE OWNER ALL WORKMANSHIP AND MATERIALS, WHETHER FURNISHED BY THE CONTRACTOR OR SUB-CONTRACTORS, AGAINST DEFECTS FOR A MINIMUM PERIOD OF ONE (1) YEAR AFTER THE DATE OF FINAL ACCEPTANCE BY OWNER. FAILURE OF ANY SUCH ITEMS SHALL BE MADE GOOD BY THE CONTRACTOR AT THE CONTRACTOR'S OWN EXPENSE.
- THE CONTRACTOR SHALL TAKE ALL NECESSARY PRECAUTIONS TO PROTECT FROM DAMAGE OR DESTRUCTION ALL EXISTING MATERIALS AND FINISHES TO REMAIN IN ADJACENT OR NEARBY AREAS. THE CONTRACTOR SHALL REPLACE ANY DAMAGED OR DESTROYED ITEMS BY OPERATIONS UNDER THIS CONTRACT.
- PRODUCTS, TRADE NAMES AND/OR MANUFACTURERS NOTED WITHIN THESE DOCUMENTS ARE PROVIDED TO ESTABLISH A STANDARD OF QUALITY. UNLESS OTHERWISE INDICATED, APPROVED EQUAL PRODUCTS OF ANOTHER MANUFACTURER MAY BE USED WITH THE WRITTEN PERMISSION OF THE ARCHITECT. IT IS THE RESPONSIBILITY OF THE CONTRACTOR AND SUPPLIER TO PROVE TO THE ARCHITECT BEFORE THE DATE OF BID THAT THEIR PRODUCT IS EQUAL TO OR BETTER THAN THOSE PRODUCTS SPECIFIED. IF AN "OR EQUAL" PRODUCT IS USED, IT IS THE RESPONSIBILITY OF THE CONTRACTOR TO MAKE ANY NECESSARY CHANGES TO THE STRUCTURE AND INTERIOR LAYOUT AT THE CONTRACTOR'S OWN EXPENSE, AFTER OBTAINING THE ARCHITECT'S ACCEPTANCE OF SUCH CHANGES.
- THE CONTRACTOR SHALL COORDINATE WITH THE OWNER A DESIGNATED SITE OR SITES FOR STORAGE OF MATERIALS AND EQUIPMENT FOR THE DURATION OF THE CONSTRUCTION CONTRACT.
- DIMENSIONS SHOWN ON THE DRAWINGS ARE TO ROUGH SURFACES, EXCLUSIVE OF FINISH MATERIALS, EXCEPT AS NOTED OTHERWISE. DO NOT SCALE THE DRAWINGS.
- THE CONTRACTOR SHALL COMPLY WITH ALL RELEVANT AND CURRENTLY ENFORCED BUILDING CODES BY ALL GOVERNING JURISDICTIONS, INCLUDING BUT NOT LIMITED TO ALL PROVISIONS OF THE AMERICAN WITH DISABILITIES ACT.

The contractor shall be responsible for all fees and obtaining all necessary and relevant permits and approvals relating to staging and construction of this project. The contractor shall comply with all relevant building, construction and work safety codes. The contractor shall verify all dimensions and elevations in the field before starting work and immediately report to the architect any discrepancies discovered.




DOUGLAS COUNTY FIRE STATION 3

CLIENT: Owner

DRAWING TITLE: FLOOR PLAN - LIGHTING

ISSUANCE:	DATE:	DRAWING NO:
Form 6-01	06/21/17	E-12
COMMISSION:	Project Number:	DRAWN BY:
		UC

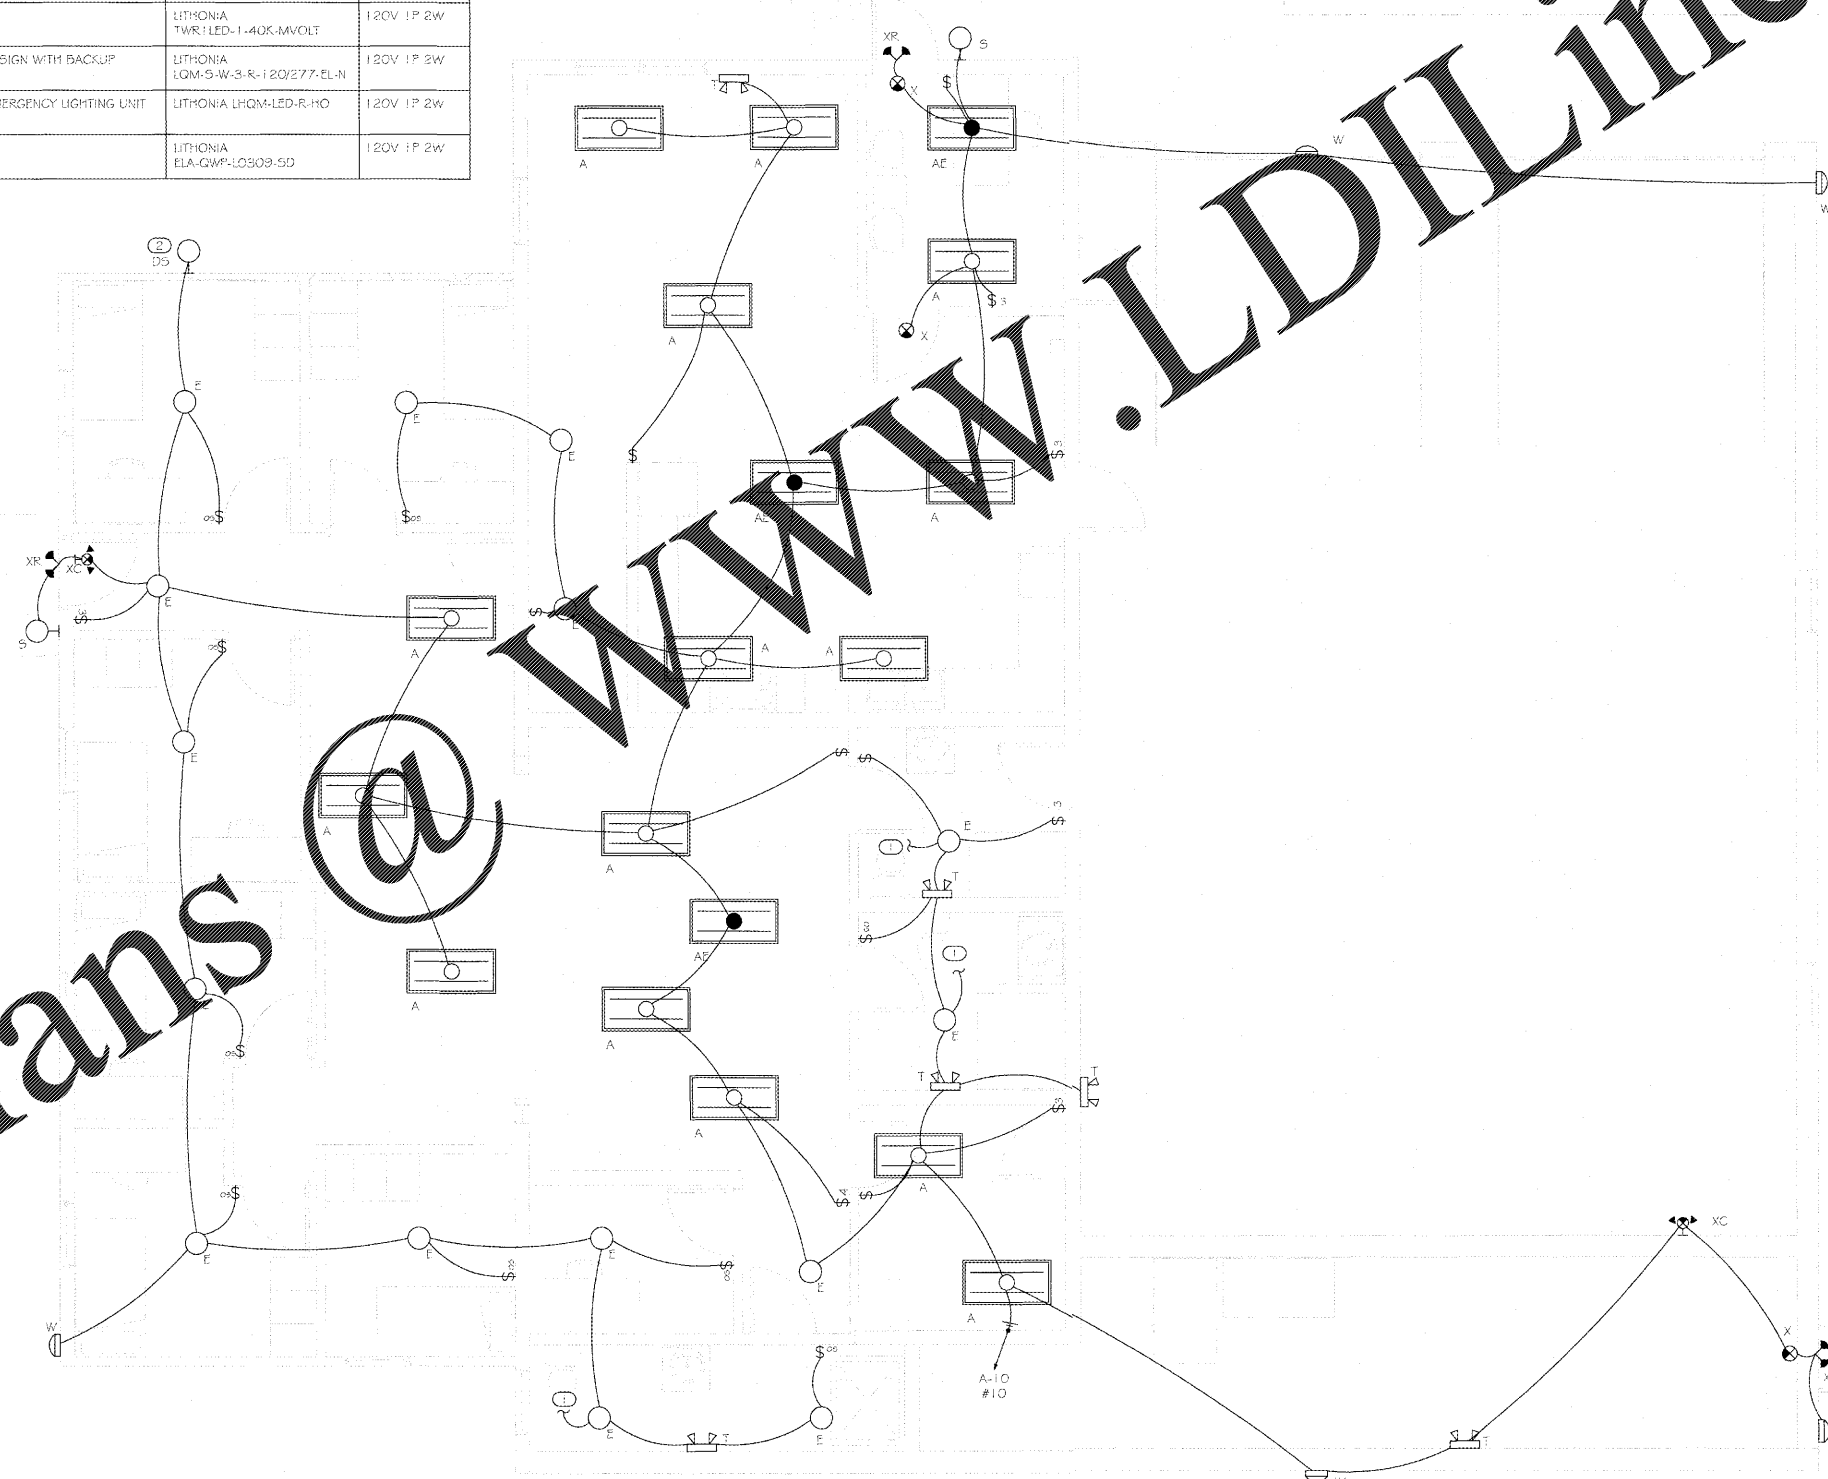

1 FLOOR PLAN - LIGHTING
E-12 1/4" = 1'-0"

Order Plans