


ALL DESIGNS, DRAWINGS AND SPECIFICATIONS DEPICTED ON THIS SHEET ARE PROPERTY OF COAST ARCHITECTS, INC. COPYRIGHT © 2017 ANY UNAUTHORIZED USE OR REPRODUCTION IS SUBJECT TO LEGAL PROSECUTION. POSSESSION IN ANY FORM CONSTITUTES ACCEPTANCE OF THESE CONDITIONS.

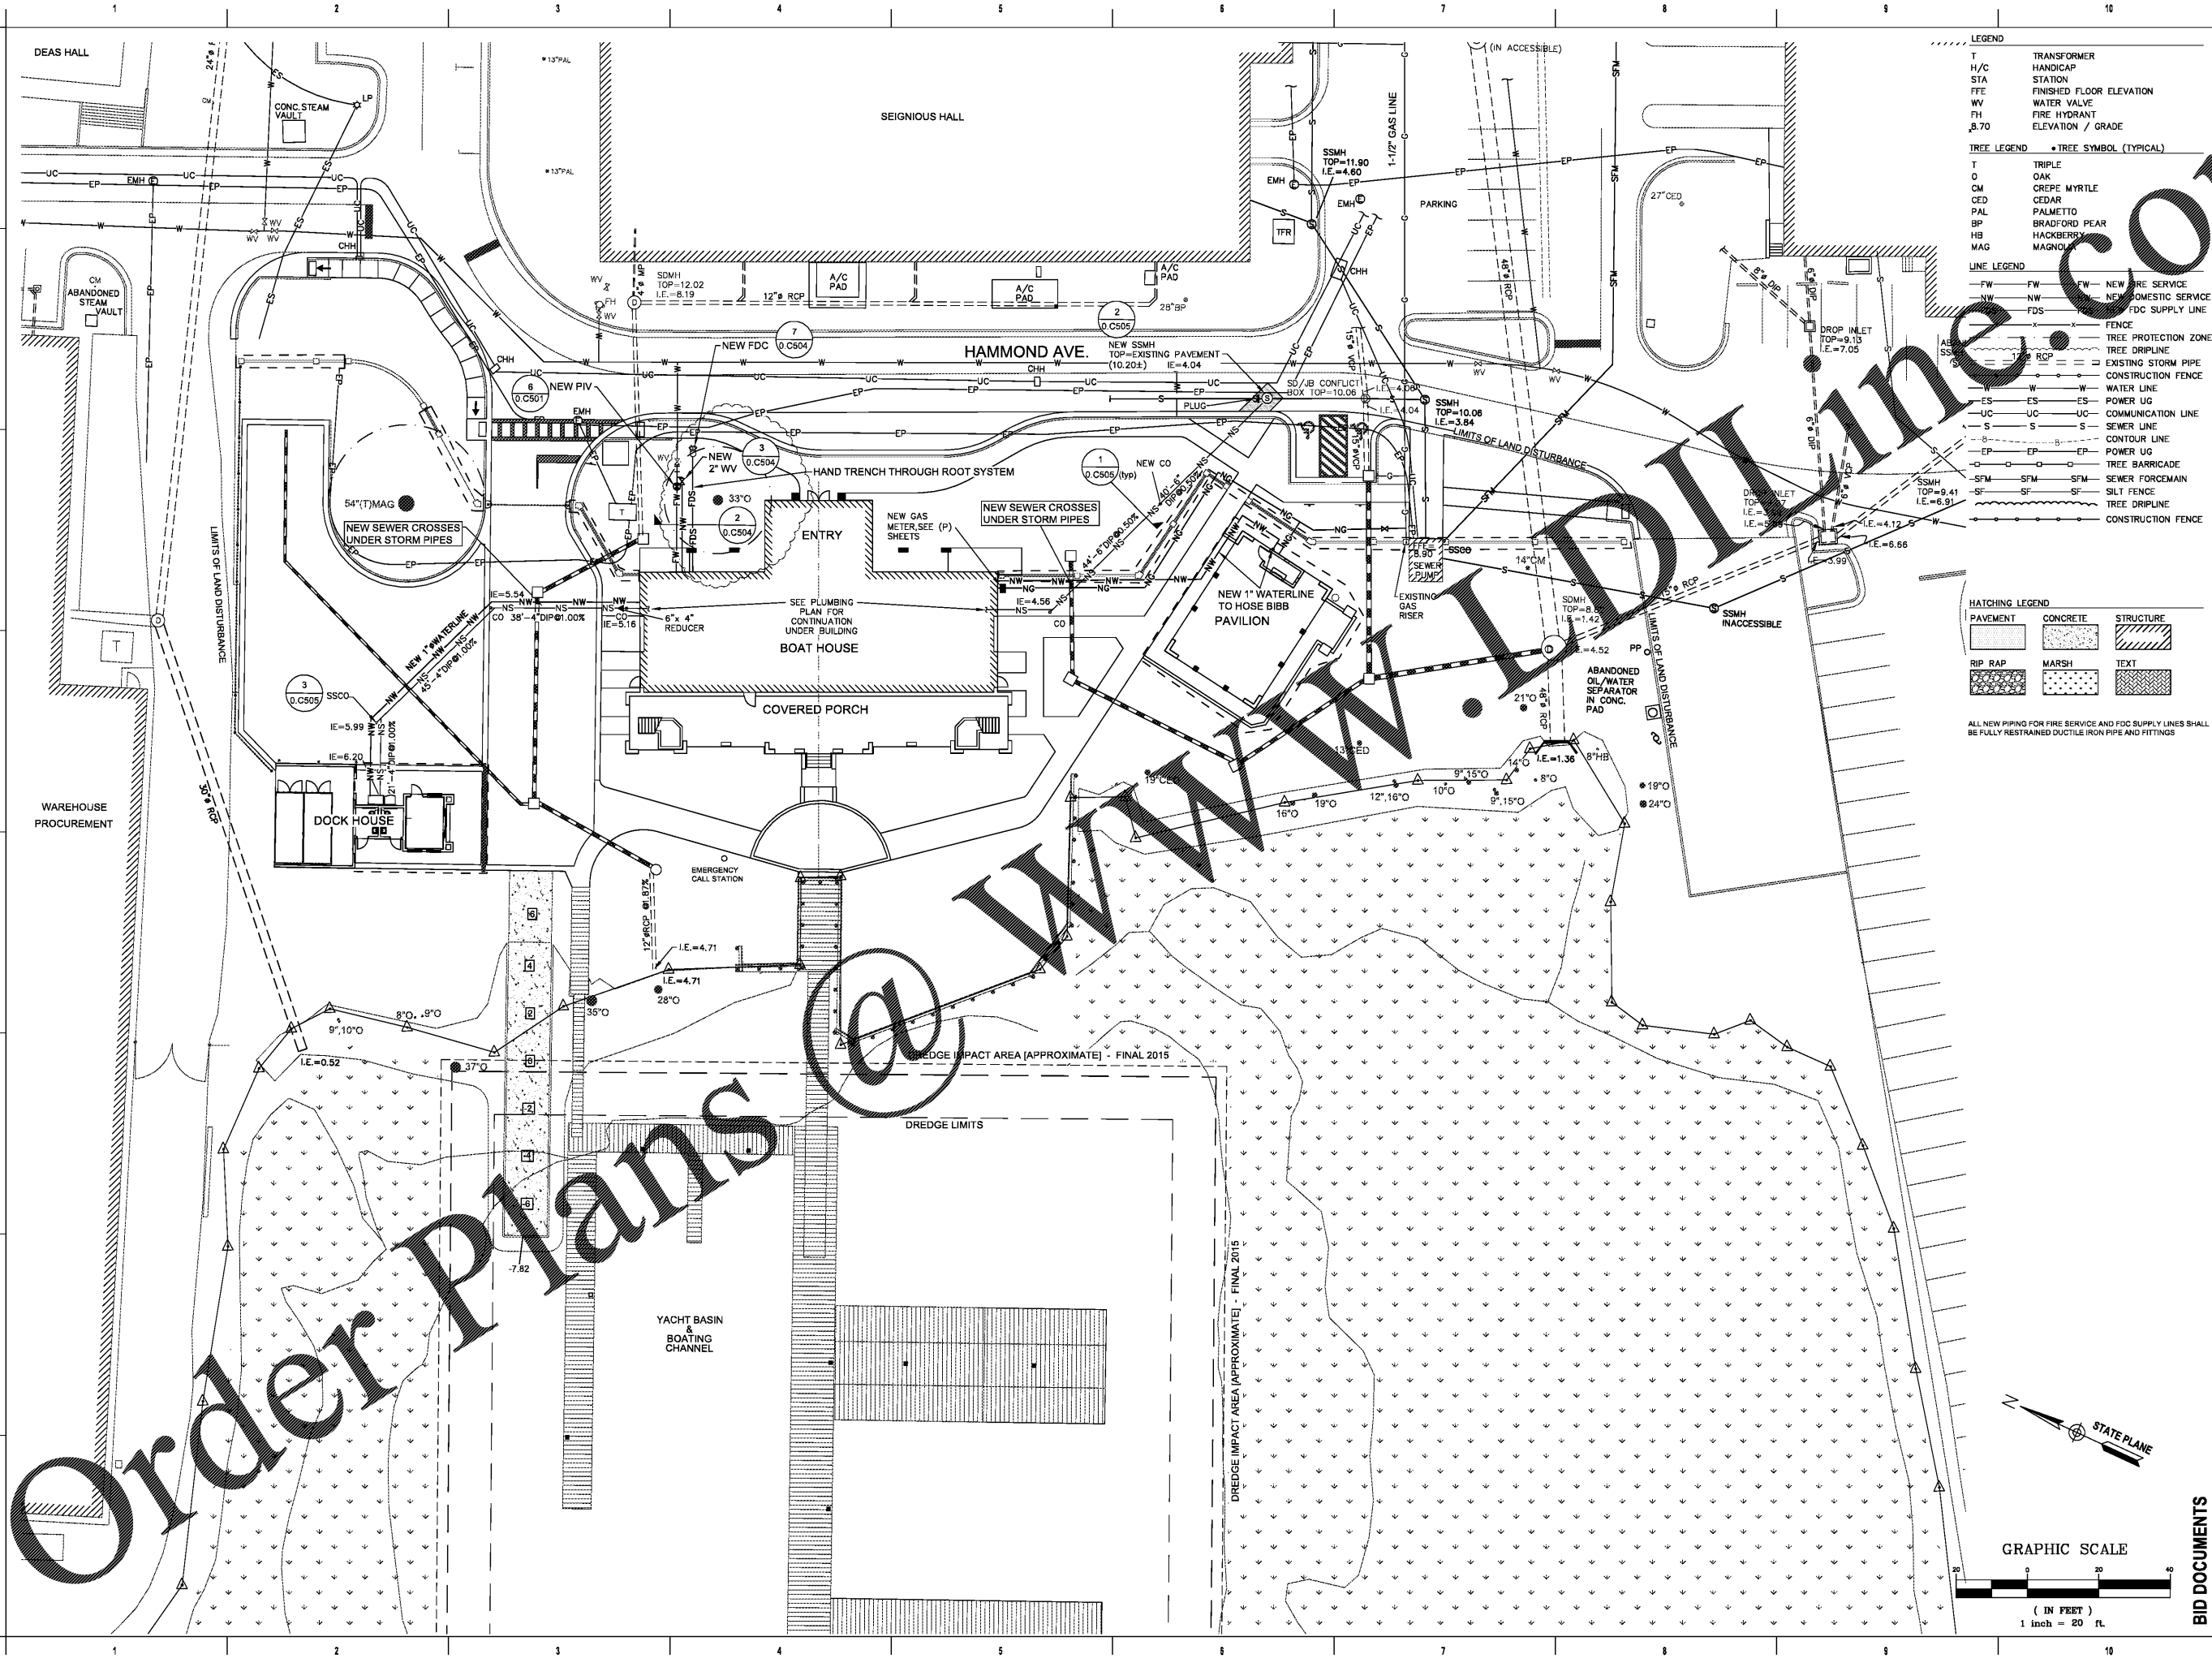

LEGEND

T	TRANSFORMER
H/C	HANDICAP STATION
STA	FINISHED FLOOR ELEVATION
FFE	WATER VALVE
WV	FIRE HYDRANT ELEVATION / GRADE
FH	8.70

TREE LEGEND • TREE SYMBOL (TYPICAL)

T	TRIPLE OAK
O	CREPE MYRTLE
CM	CEDAR
CED	PALMETTO
PAL	BRADFORD PEAR
BP	HACKBERRY
HB	MAGNOLIA

LINE LEGEND



FW	NEW FIRE SERVICE
NW	NEW DOMESTIC SERVICE
FDS	FDC SUPPLY LINE
X	FENCE
---	TREE PROTECTION ZONE
---	TREE DRIFLINE
---	EXISTING STORM PIPE
---	CONSTRUCTION FENCE
W	WATER LINE
ES	POWER UG
UC	COMMUNICATION LINE
S	SEWER LINE
---	CONTOUR LINE
---	POWER UG
---	TREE BARRICADE
---	SEWER FORCEMAIN
---	SILT FENCE
---	TREE DRIFLINE
---	CONSTRUCTION FENCE

HATCHING LEGEND

[Pattern]	PAVEMENT	[Pattern]	CONCRETE	[Pattern]	STRUCTURE
[Pattern]	RIP RAP	[Pattern]	MARSH	[Pattern]	TEXT

ALL NEW PIPING FOR FIRE SERVICE AND FDC SUPPLY LINES SHALL BE FULLY RESTRAINED DUCTILE IRON PIPE AND FITTINGS

coast architects
 671 St. Andrews Blvd., Charleston, SC 29407
 Phone: 843.763.7064 Fax: 843.763.7061
 www.coastarchitects.net

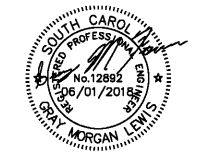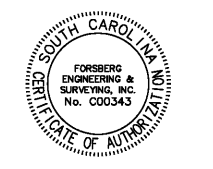

FORSBERG ENGINEERING AND SURVEYING, INC.
 1587 SAVANNAH HIGHWAY, SUITE B
 P.O. BOX 30575
 CHARLESTON, SOUTH CAROLINA 29417
 (843) 571-2622 FAX (843) 571-6780
 CIVIL ENGINEERING, SURVEYING AND LAND PLANNING


**BOATING CENTER REDEVELOPMENT
 SWAIN BOATING CENTER
 H09-9617-PG-C**

CITADEL
 THE MILITARY COLLEGE OF SOUTH CAROLINA

11 HAMMOND AVENUE
 CHARLESTON, SC

Revisions	
Rev. No.	Rev. Date

DRAWN BY: WFS
 CHECKED BY: DCF
 DATE: 06-01-2018
 COAST PROJECT NO.: 1722.00

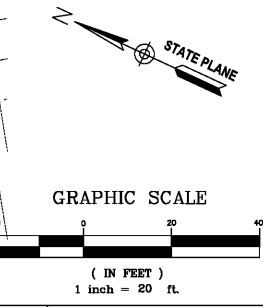

BID DOCUMENTS

CIVIL SITE
 UTILITY PLAN
0.C401
 JOB# 4727-1