


ALL DESIGNS, DRAWINGS AND SPECIFICATIONS DEPICTED ON THIS SHEET ARE PROPERTY OF COAST ARCHITECTS, INC. COPYRIGHT © 5/30/2018 ANY UNAUTHORIZED USE OR REPRODUCTION IS SUBJECT TO LEGAL PROSECUTION. POSSESSION IN ANY FORM CONSTITUTES ACCEPTANCE OF THESE CONDITIONS.  
 2:56:30 PM

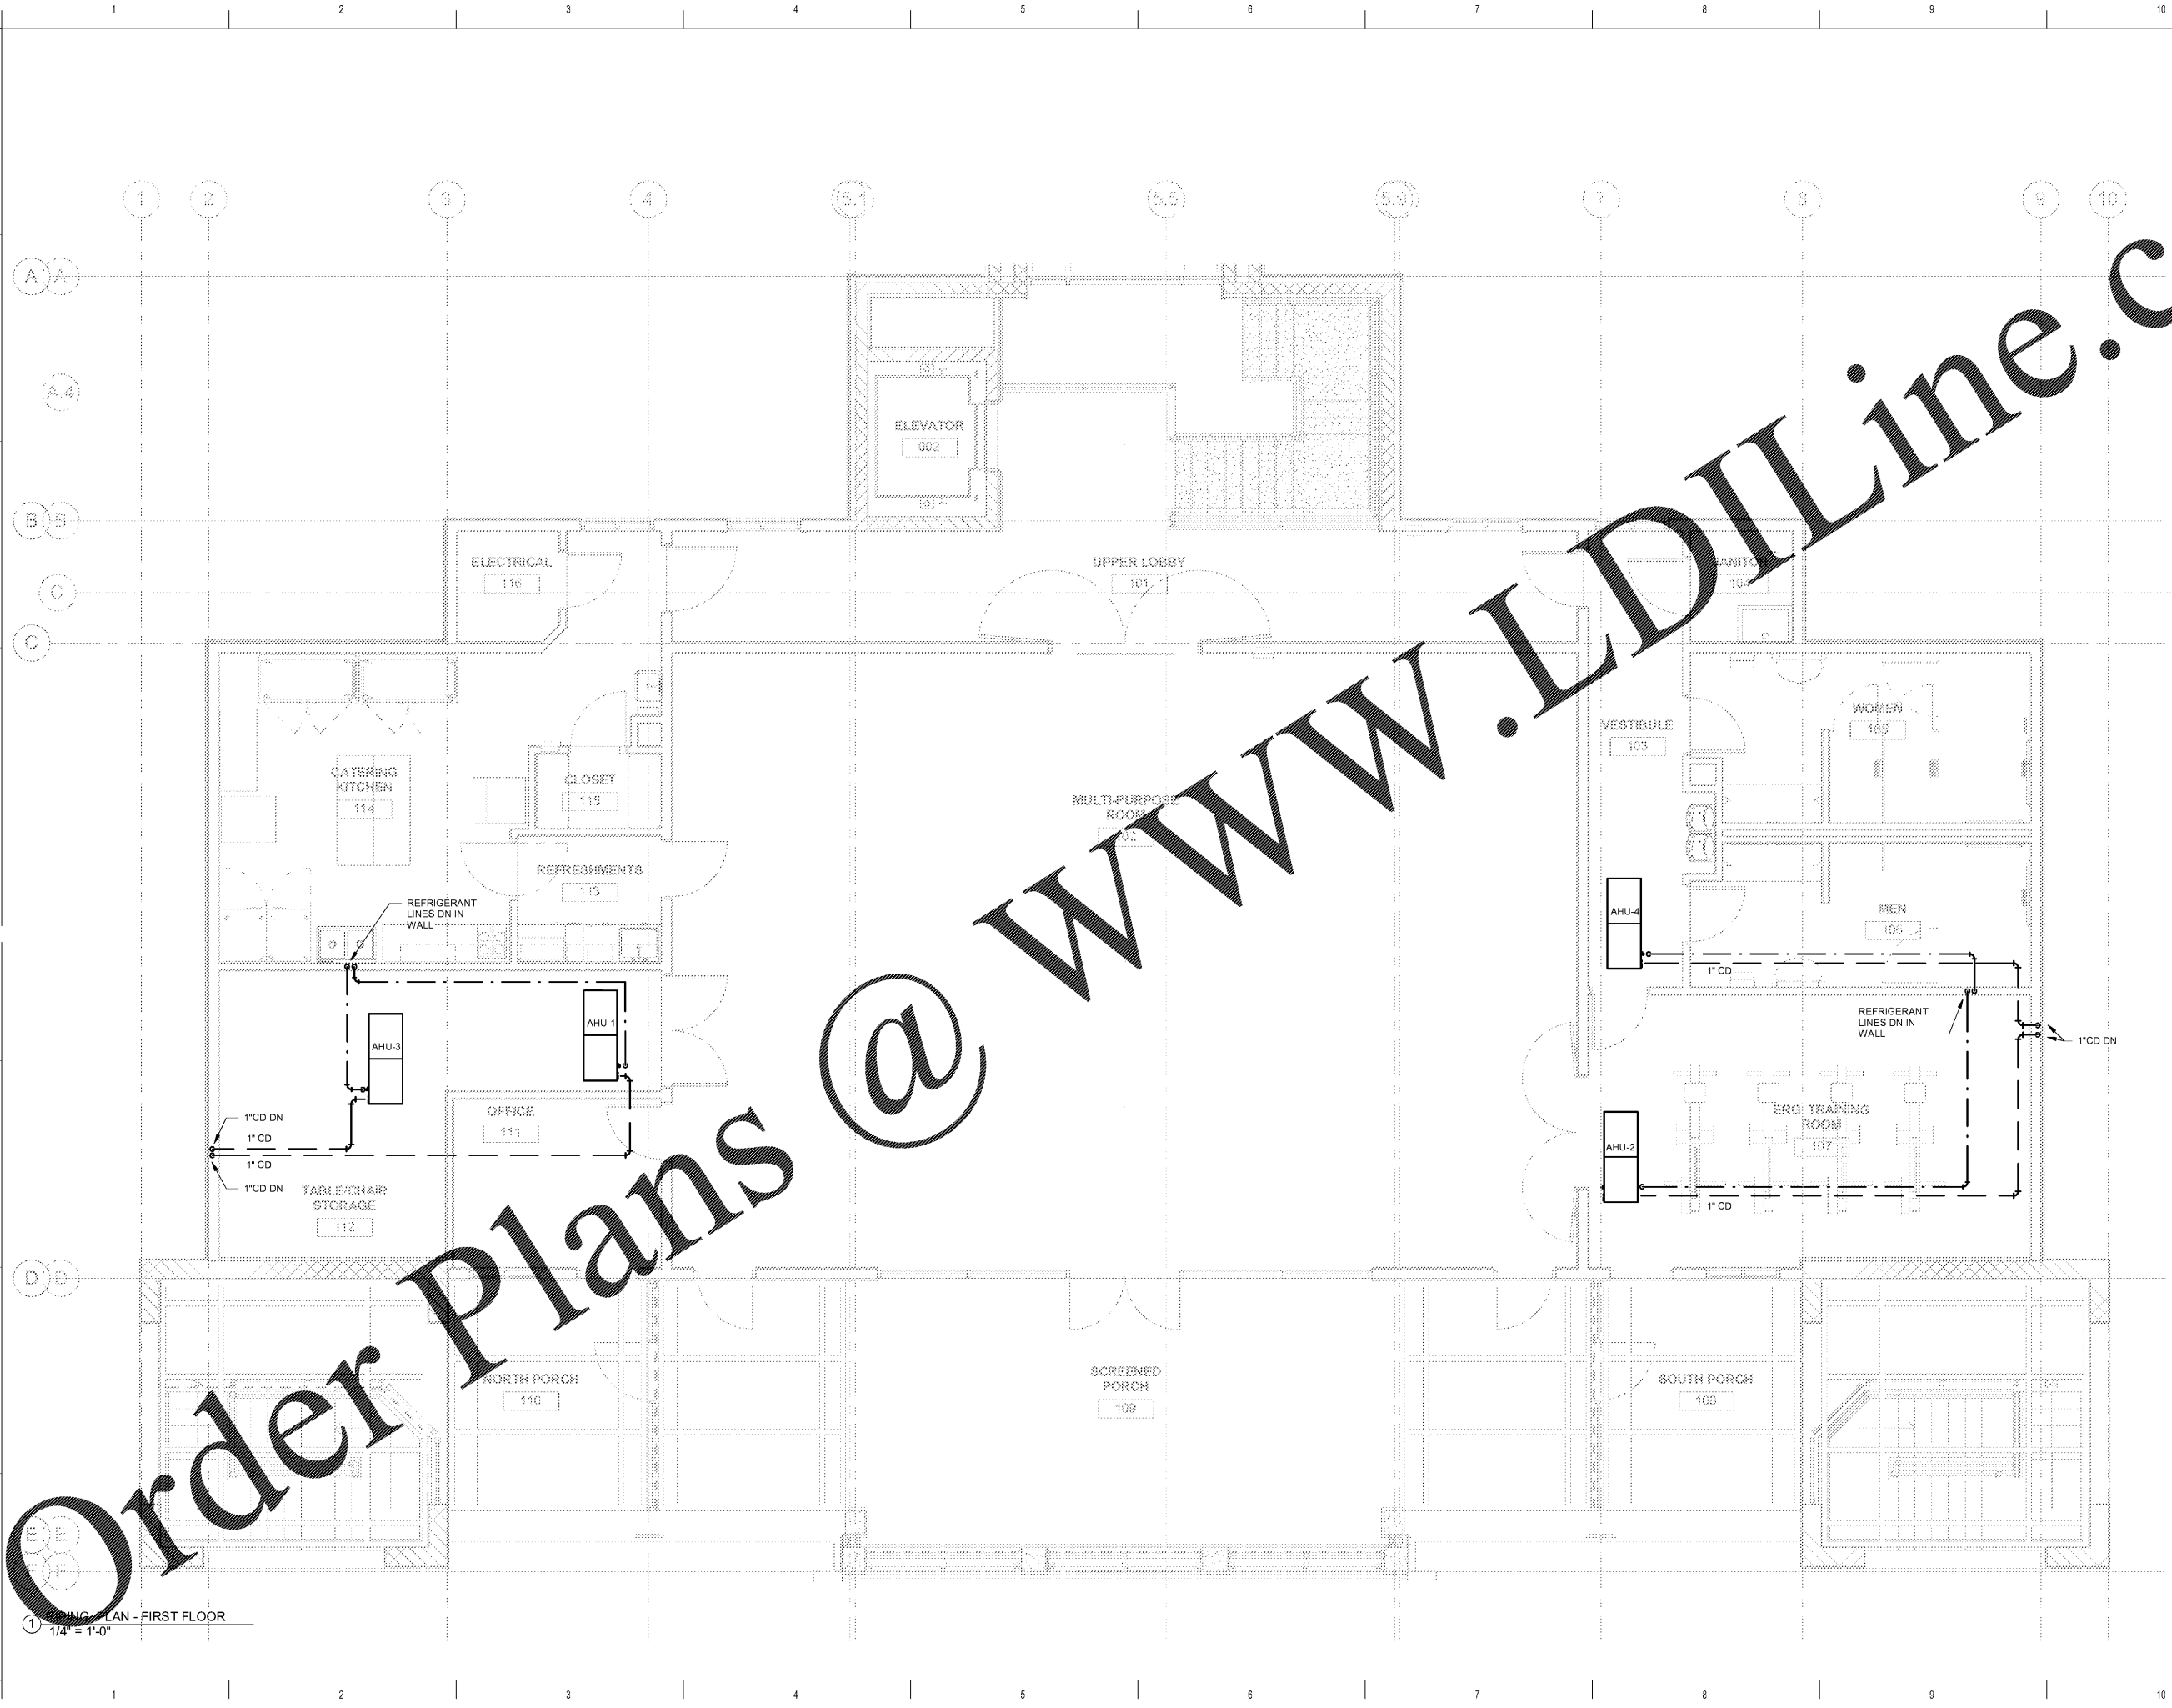

1 MECHANICAL PLAN - FIRST FLOOR  
 1/4" = 1'-0"

Order Plans @ WWW.LDILine.com


BID DOCUMENTS

MECHANICAL PIPING PLAN

COAST PROJECT NO: 17-069

DATE: 06.01.2018  
 CHECKED BY: CJC  
 DRAWN BY: TJR



Revisions	
Rev. No.	Rev. Date

 

THE CITADEL  
 THE MILITARY COLLEGE OF SOUTH CAROLINA  
 11 HAMMOND AVENUE  
 CHARLESTON, SC  
 H09-9617-PG-C

BOATING CENTER REDEVELOPMENT - SWAIN BOATING CENTER

CONSTANTINE ENGINEERING ASSOCIATES, LLC  
 1428 Savannah Hwy #111, Charleston, SC 29407  
 Phone: 843.529.7979, Fax: 843.529.9844

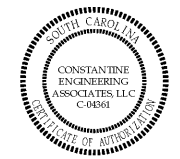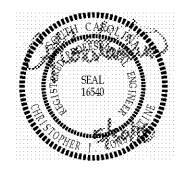

coast architects  
 671 St. Andrews Blvd., Charleston, SC 29407  
 Phone: 843.763.7064 Fax: 843.763.7061  
 www.coastarchitects.net