


ALL DESIGNS, DRAWINGS AND SPECIFICATIONS DEPICTED ON THIS SHEET ARE PROPERTY OF COAST ARCHITECTS, INC. COPYRIGHT ©2010. ANY UNAUTHORIZED USE OR REPRODUCTION IS SUBJECT TO LEGAL PROSECUTION. POSSESSION IN ANY FORM CONSTITUTES ACCEPTANCE OF THESE CONDITIONS.

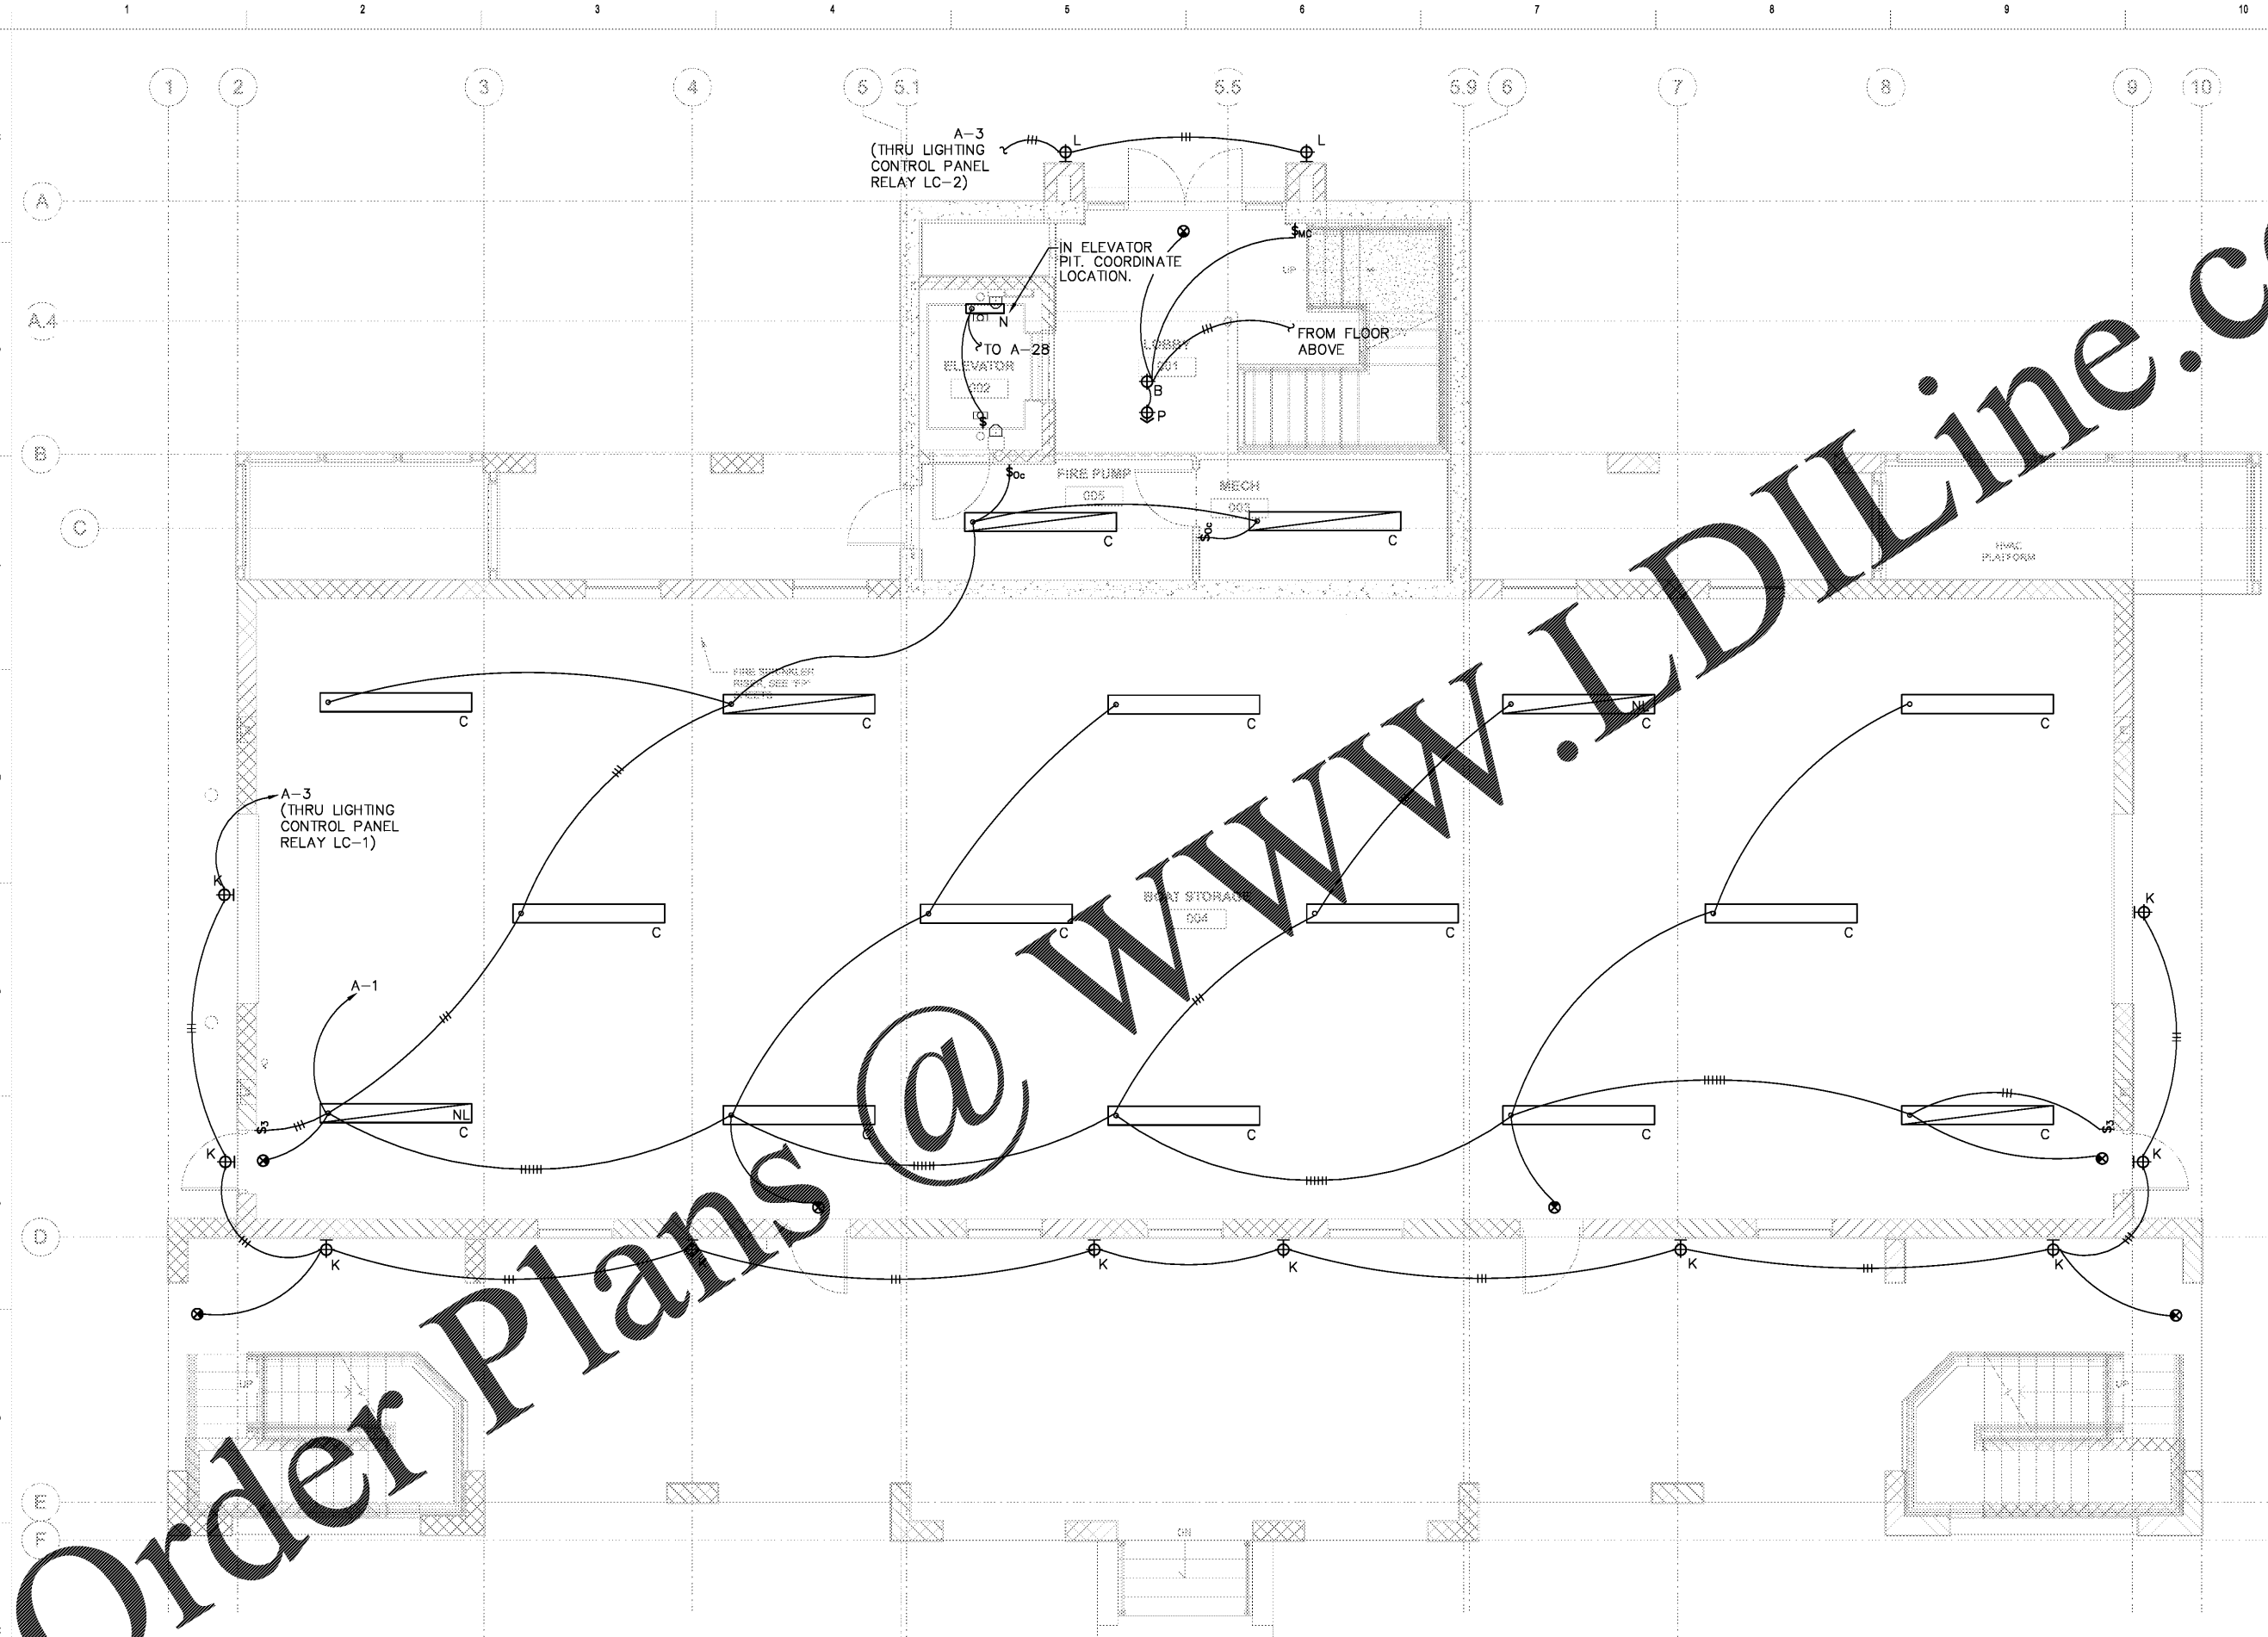

GROUND FLOOR LIGHTING PLAN
SCALE: 1/4" = 1'-0"

Order Plans @ WWW.LDILine.com

WWW.LDILine.com

coast
architects
671 St. Andrews Blvd., Charleston, SC 29407
Phone: 843.763.7064 Fax: 843.763.7061
www.coastarchitects.net



DAVID F. WILSON, P.E.
1421 BRIAN ROAD
CHARLESTON, SC 29407
TEL: (843) 225-7191

BOATING CENTER REDEVELOPMENT-
SWAIN BOATING CENTER
H09-9617-PG-C

THE CITADEL
THE MILITARY COLLEGE OF SOUTH CAROLINA
11 HAMMOND AVENUE
CHARLESTON, SC

Revisions	
Rev. No.	Rev. Date

DRAWN BY: DFW
CHECKED BY: DFW
DATE: 06.01.2018

COAST PROJECT NO.: 1722.00

GROUND FLOOR LIGHTING PLAN

BID DOCUMENTS

1.E101