


ALL DESIGNS, DRAWINGS AND SPECIFICATIONS DEPICTED ON THIS SHEET ARE PROPERTY OF COAST ARCHITECTS, INC. COPYRIGHT ©2010. ANY UNAUTHORIZED USE OR REPRODUCTION IS SUBJECT TO LEGAL PROSECUTION. POSSESSION IN ANY FORM CONSTITUTES ACCEPTANCE OF THESE CONDITIONS.

NOTES:

1. JUNCTION BOX FOR FUTURE ACCESS CONTROL. PROVIDE EMPTY CONDUIT BACK TO NETWORK RACK IN ELECTRICAL ROOM.
2. PROVIDE SIX CEILING MOUNTED CORD REELS, HUBBELL MODEL HBLC40123TT OR EQUAL BY GLEASON OR MOLEX.
3. MAKE FINAL ELECTRICAL POWER CONNECTION TO FIRE PUMP CONTROLLER AND FIRE PUMP. COORDINATE ALL WORK WITH FIRE SYSTEM INSTALLER.

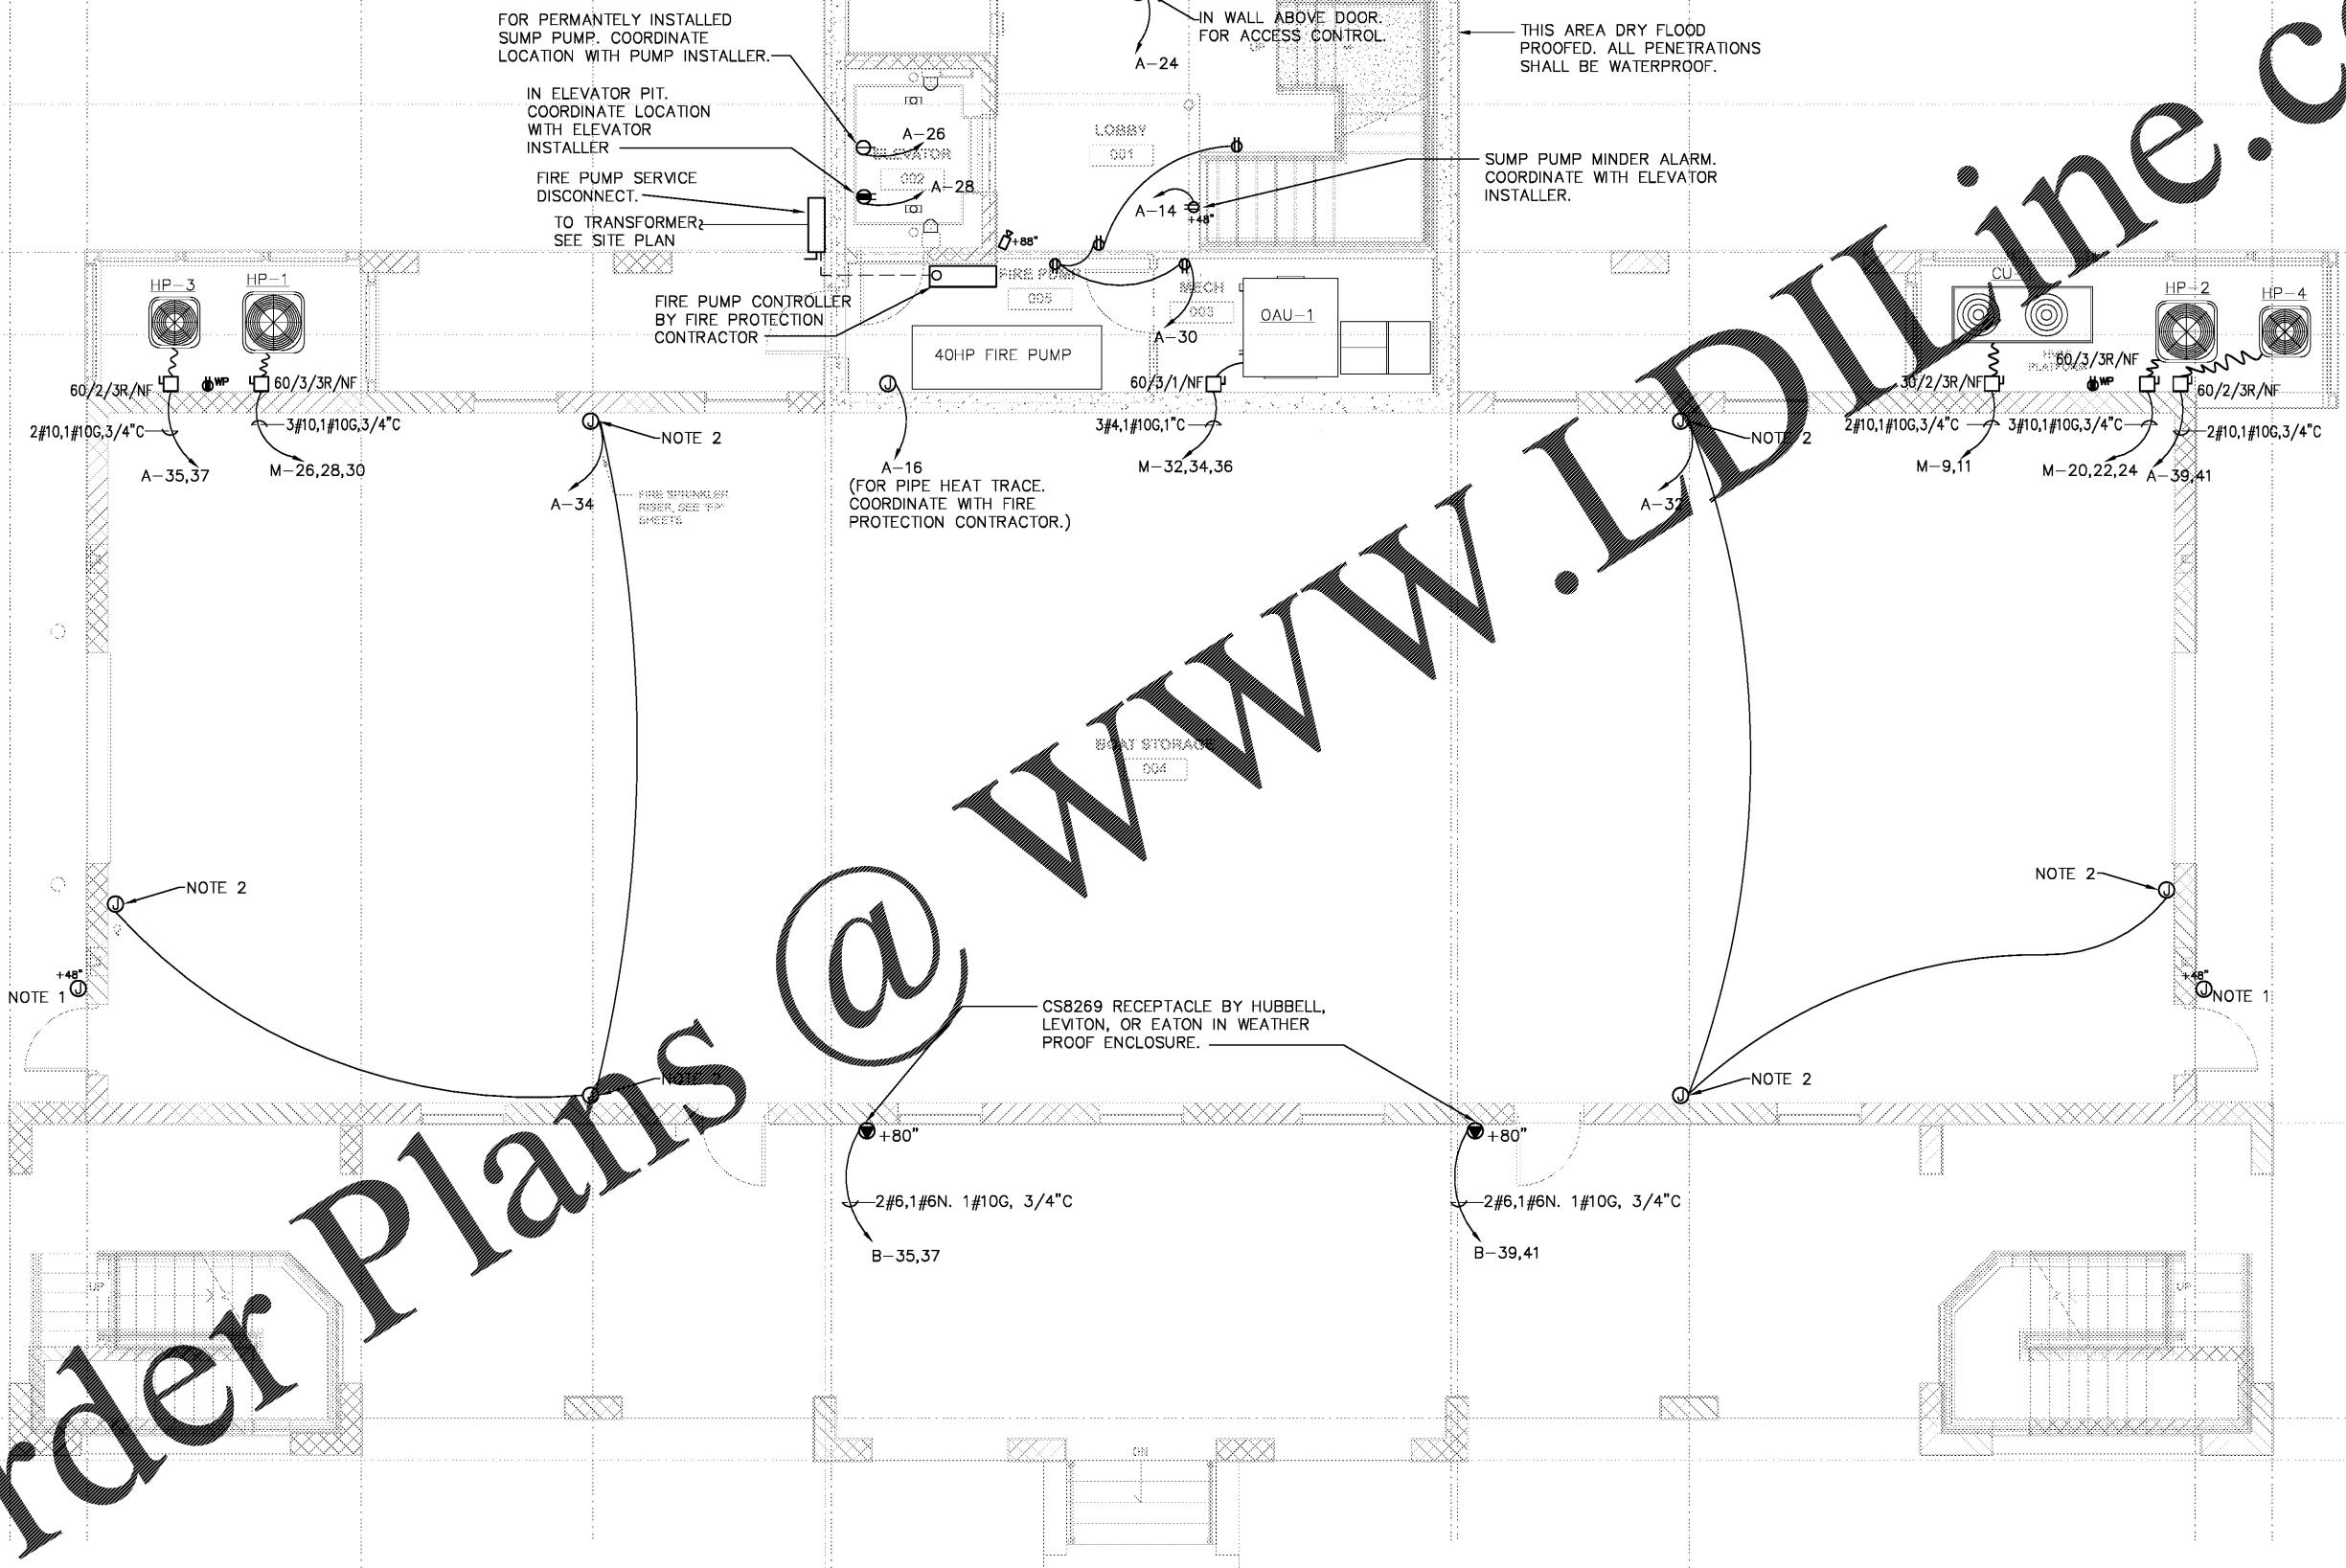

GROUND FLOOR POWER PLAN
SCALE: 1/4" = 1'-0"

Order Plans @ www.LDOnline.com

coast architects
671 St. Andrews Blvd., Charleston, SC 29407
Phone: 843.763.7064 Fax: 843.763.7061
www.coastarchitects.net



DAVID F. WILSON, P.E.
1421 BRIAN ROAD
CHARLESTON, SC 29407
TEL: (843) 225-7191

**BOATING CENTER REDEVELOPMENT-
SWAIN BOATING CENTER
H09-9617-PG-C**

THE CITADEL
11 HAMMOND AVENUE
CHARLESTON, SC

THE MILITARY COLLEGE OF SOUTH CAROLINA

Revisions	
Rev. No.	Rev. Date

DRAWN BY: DFW
CHECKED BY: DFW
DATE: 06.01.2018

COAST PROJECT NO.: 1722.00

**GROUND FLOOR
POWER PLAN**

BID DOCUMENTS

1.E103