


ALL DESIGNS, DRAWINGS AND SPECIFICATIONS DEPICTED ON THIS SHEET ARE PROPERTY OF COAST ARCHITECTS, INC. COPYRIGHT ©2010. ANY UNAUTHORIZED USE OR REPRODUCTION IS SUBJECT TO LEGAL PROSECUTION. POSSESSION IN ANY FORM CONSTITUTES ACCEPTANCE OF THESE CONDITIONS.

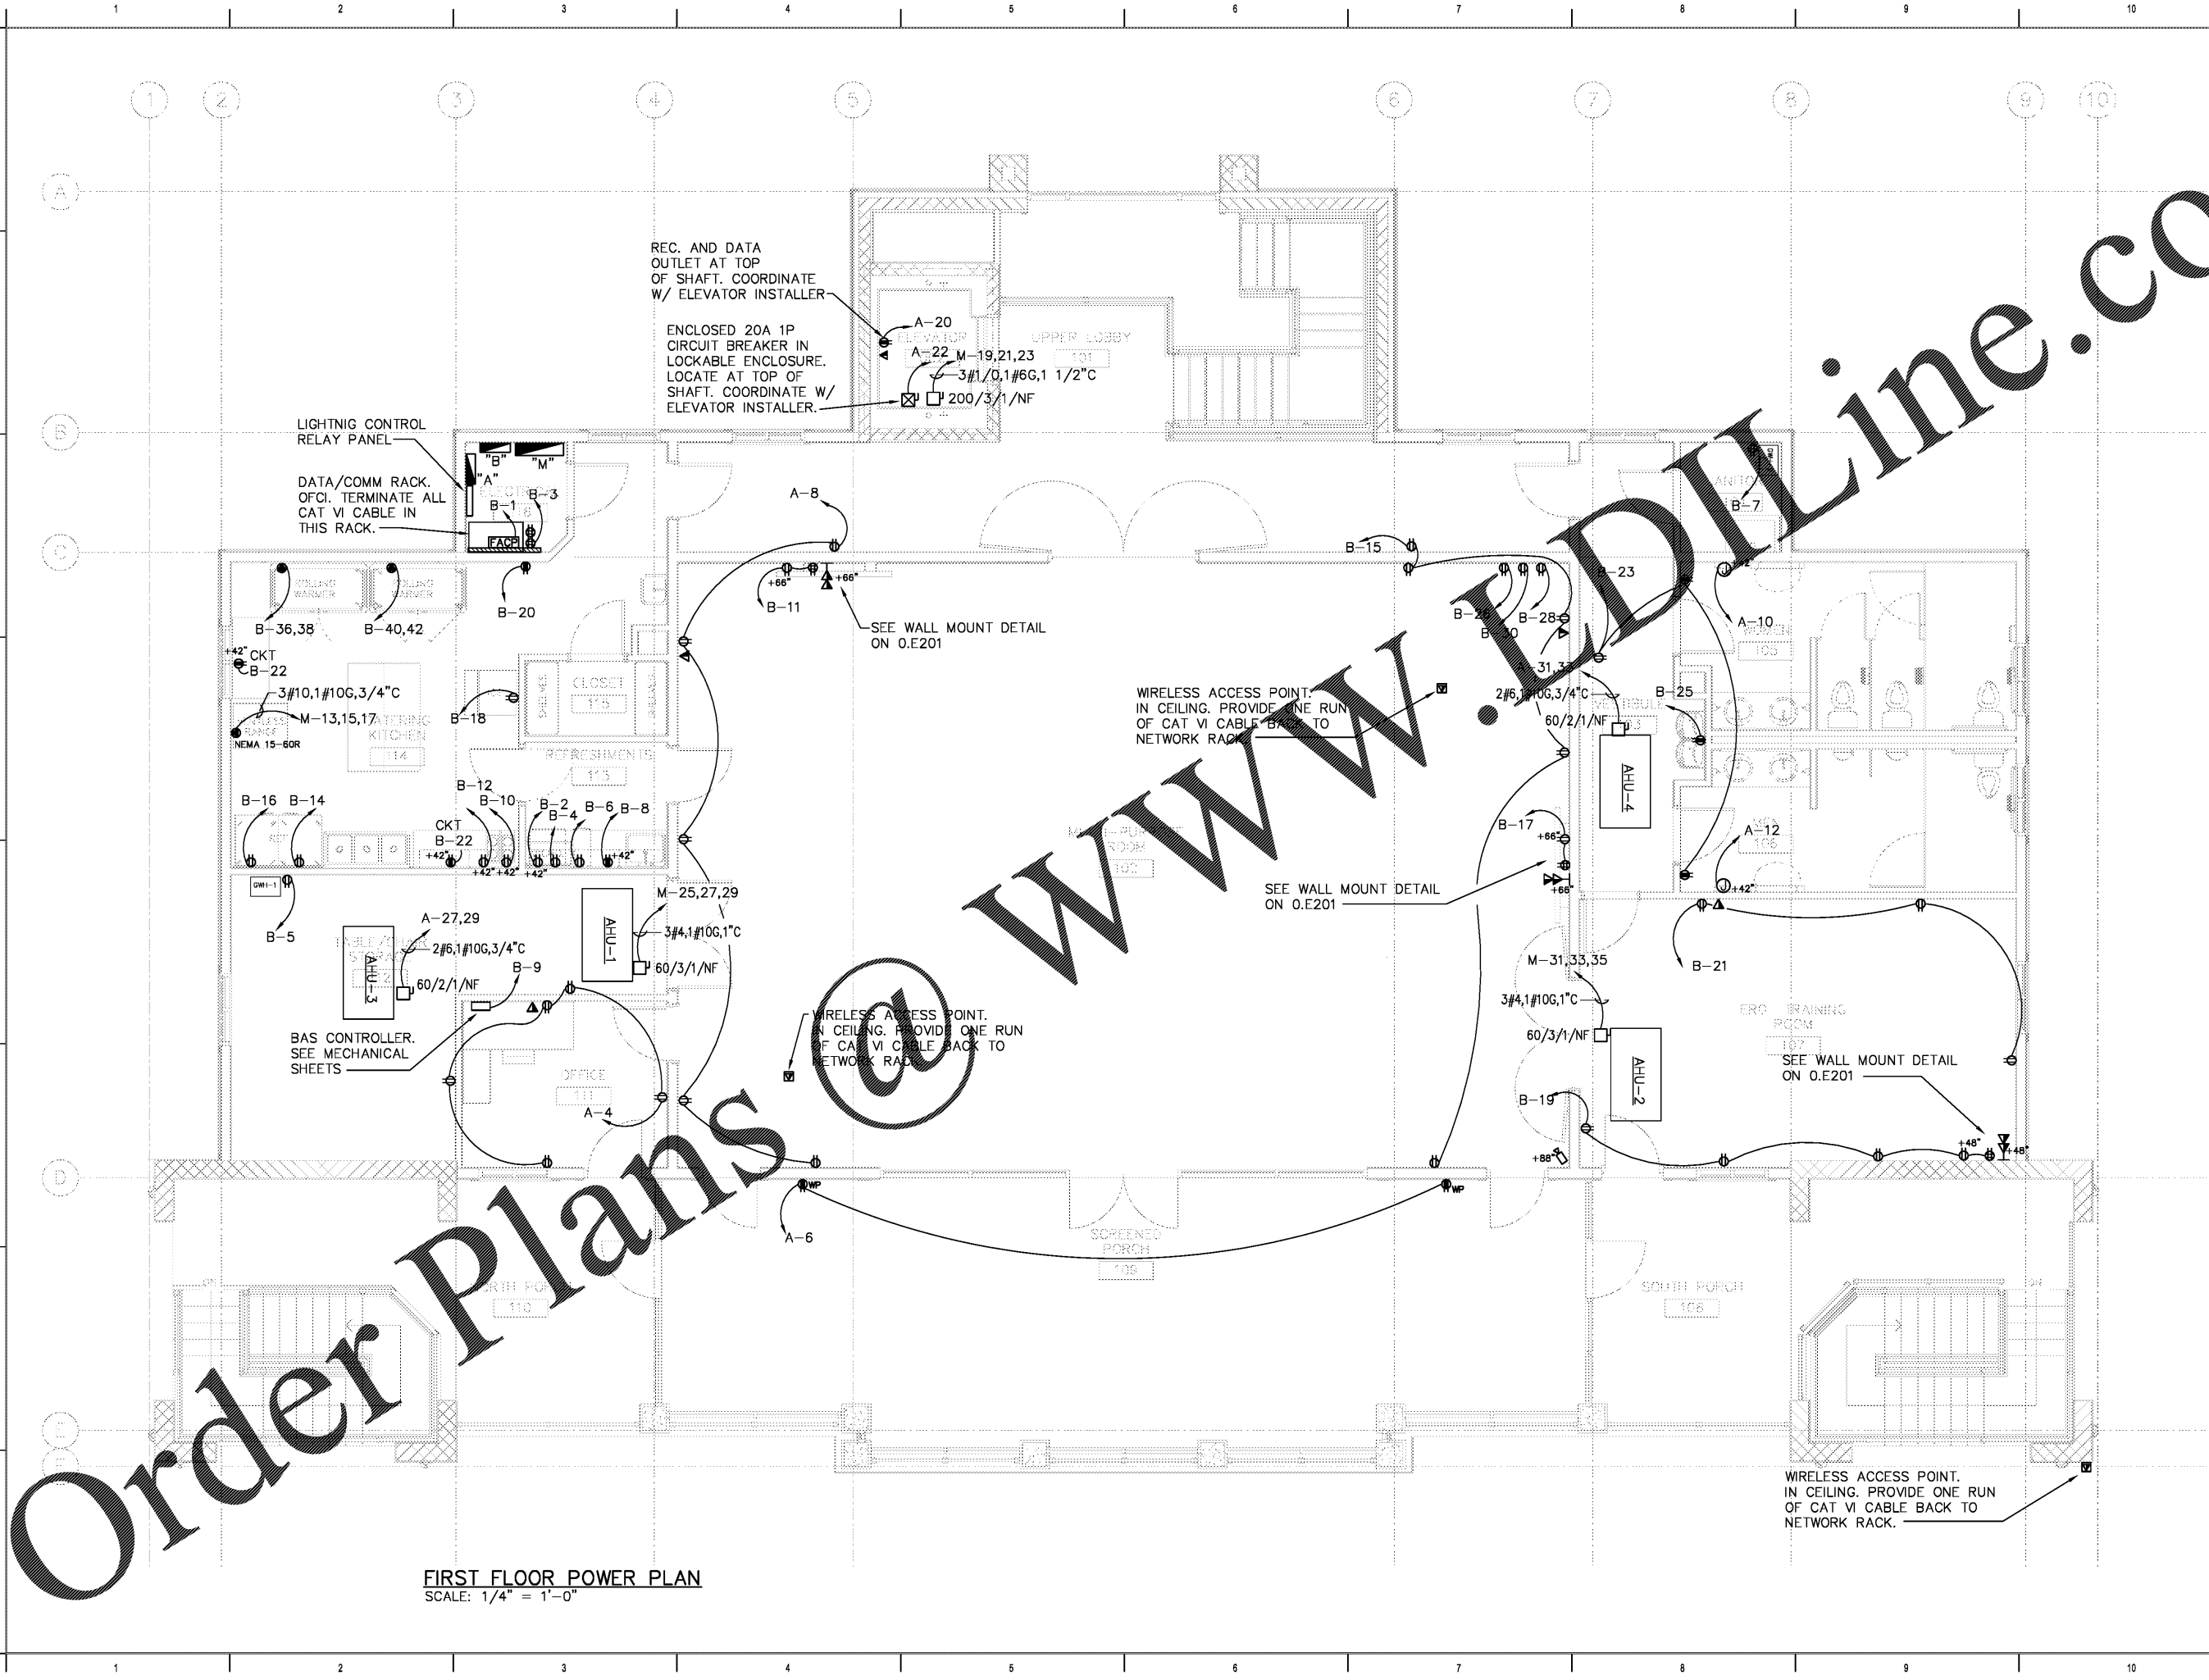

FIRST FLOOR POWER PLAN  
SCALE: 1/4" = 1'-0"

Order Plans @ WWW.DLine.com

**coast**  
architects  
671 St. Andrews Blvd., Charleston, SC 29407  
Phone: 843.763.7064 Fax: 843.763.7061  
www.coastarchitects.net



DAVID F. WILSON, P.E.  
1421 BRIAN ROAD  
CHARLESTON, SC 29407  
TEL: (843) 225-7191

BOATING CENTER REDEVELOPMENT-  
SWAIN BOATING CENTER  
H09-9617-PG-C



Revisions

Rev. No.	Rev. Date
----------	-----------

DRAWN BY: DFW  
CHECKED BY: DFW  
DATE: 06.01.2018

COAST PROJECT NO.: 1722.00

FIRST FLOOR  
POWER PLAN

BID DOCUMENTS

1.E104