






 





ALL DESIGNS, DRAWINGS AND SPECIFICATIONS DEPICTED ON THIS SHEET ARE PROPERTY OF COAST ARCHITECTS, INC. COPYRIGHT ©2010. ANY UNAUTHORIZED USE OR REPRODUCTION IS SUBJECT TO LEGAL PROSECUTION. POSSESSION IN ANY FORM CONSTITUTES ACCEPTANCE OF THESE CONDITIONS.

FIRE ALARM LEGEND

-  FIRE ALARM REMOTE ANNUNCIATOR.
-  FIRE ALARM CONTROL PANEL
-  FIRE ALARM HORN WITH STROBE FLASHER
-  FIRE ALARM STROBE FLASHER
-  FIRE ALARM MANUAL PULL STATION
-  FIRE ALARM DUCT SMOKE DETECTOR
PROVIDE DETECTOR APPROPRIATE FOR
UNIT CFM LEVELS INDICATED
-  SUPERVISED RELAY
-  FIRE ALARM SMOKE DETECTOR
-  FIRE SPRINKLER RISER TAMPER SWITCH
-  FIRE SPRINKLER RISER FLOW SWITCH

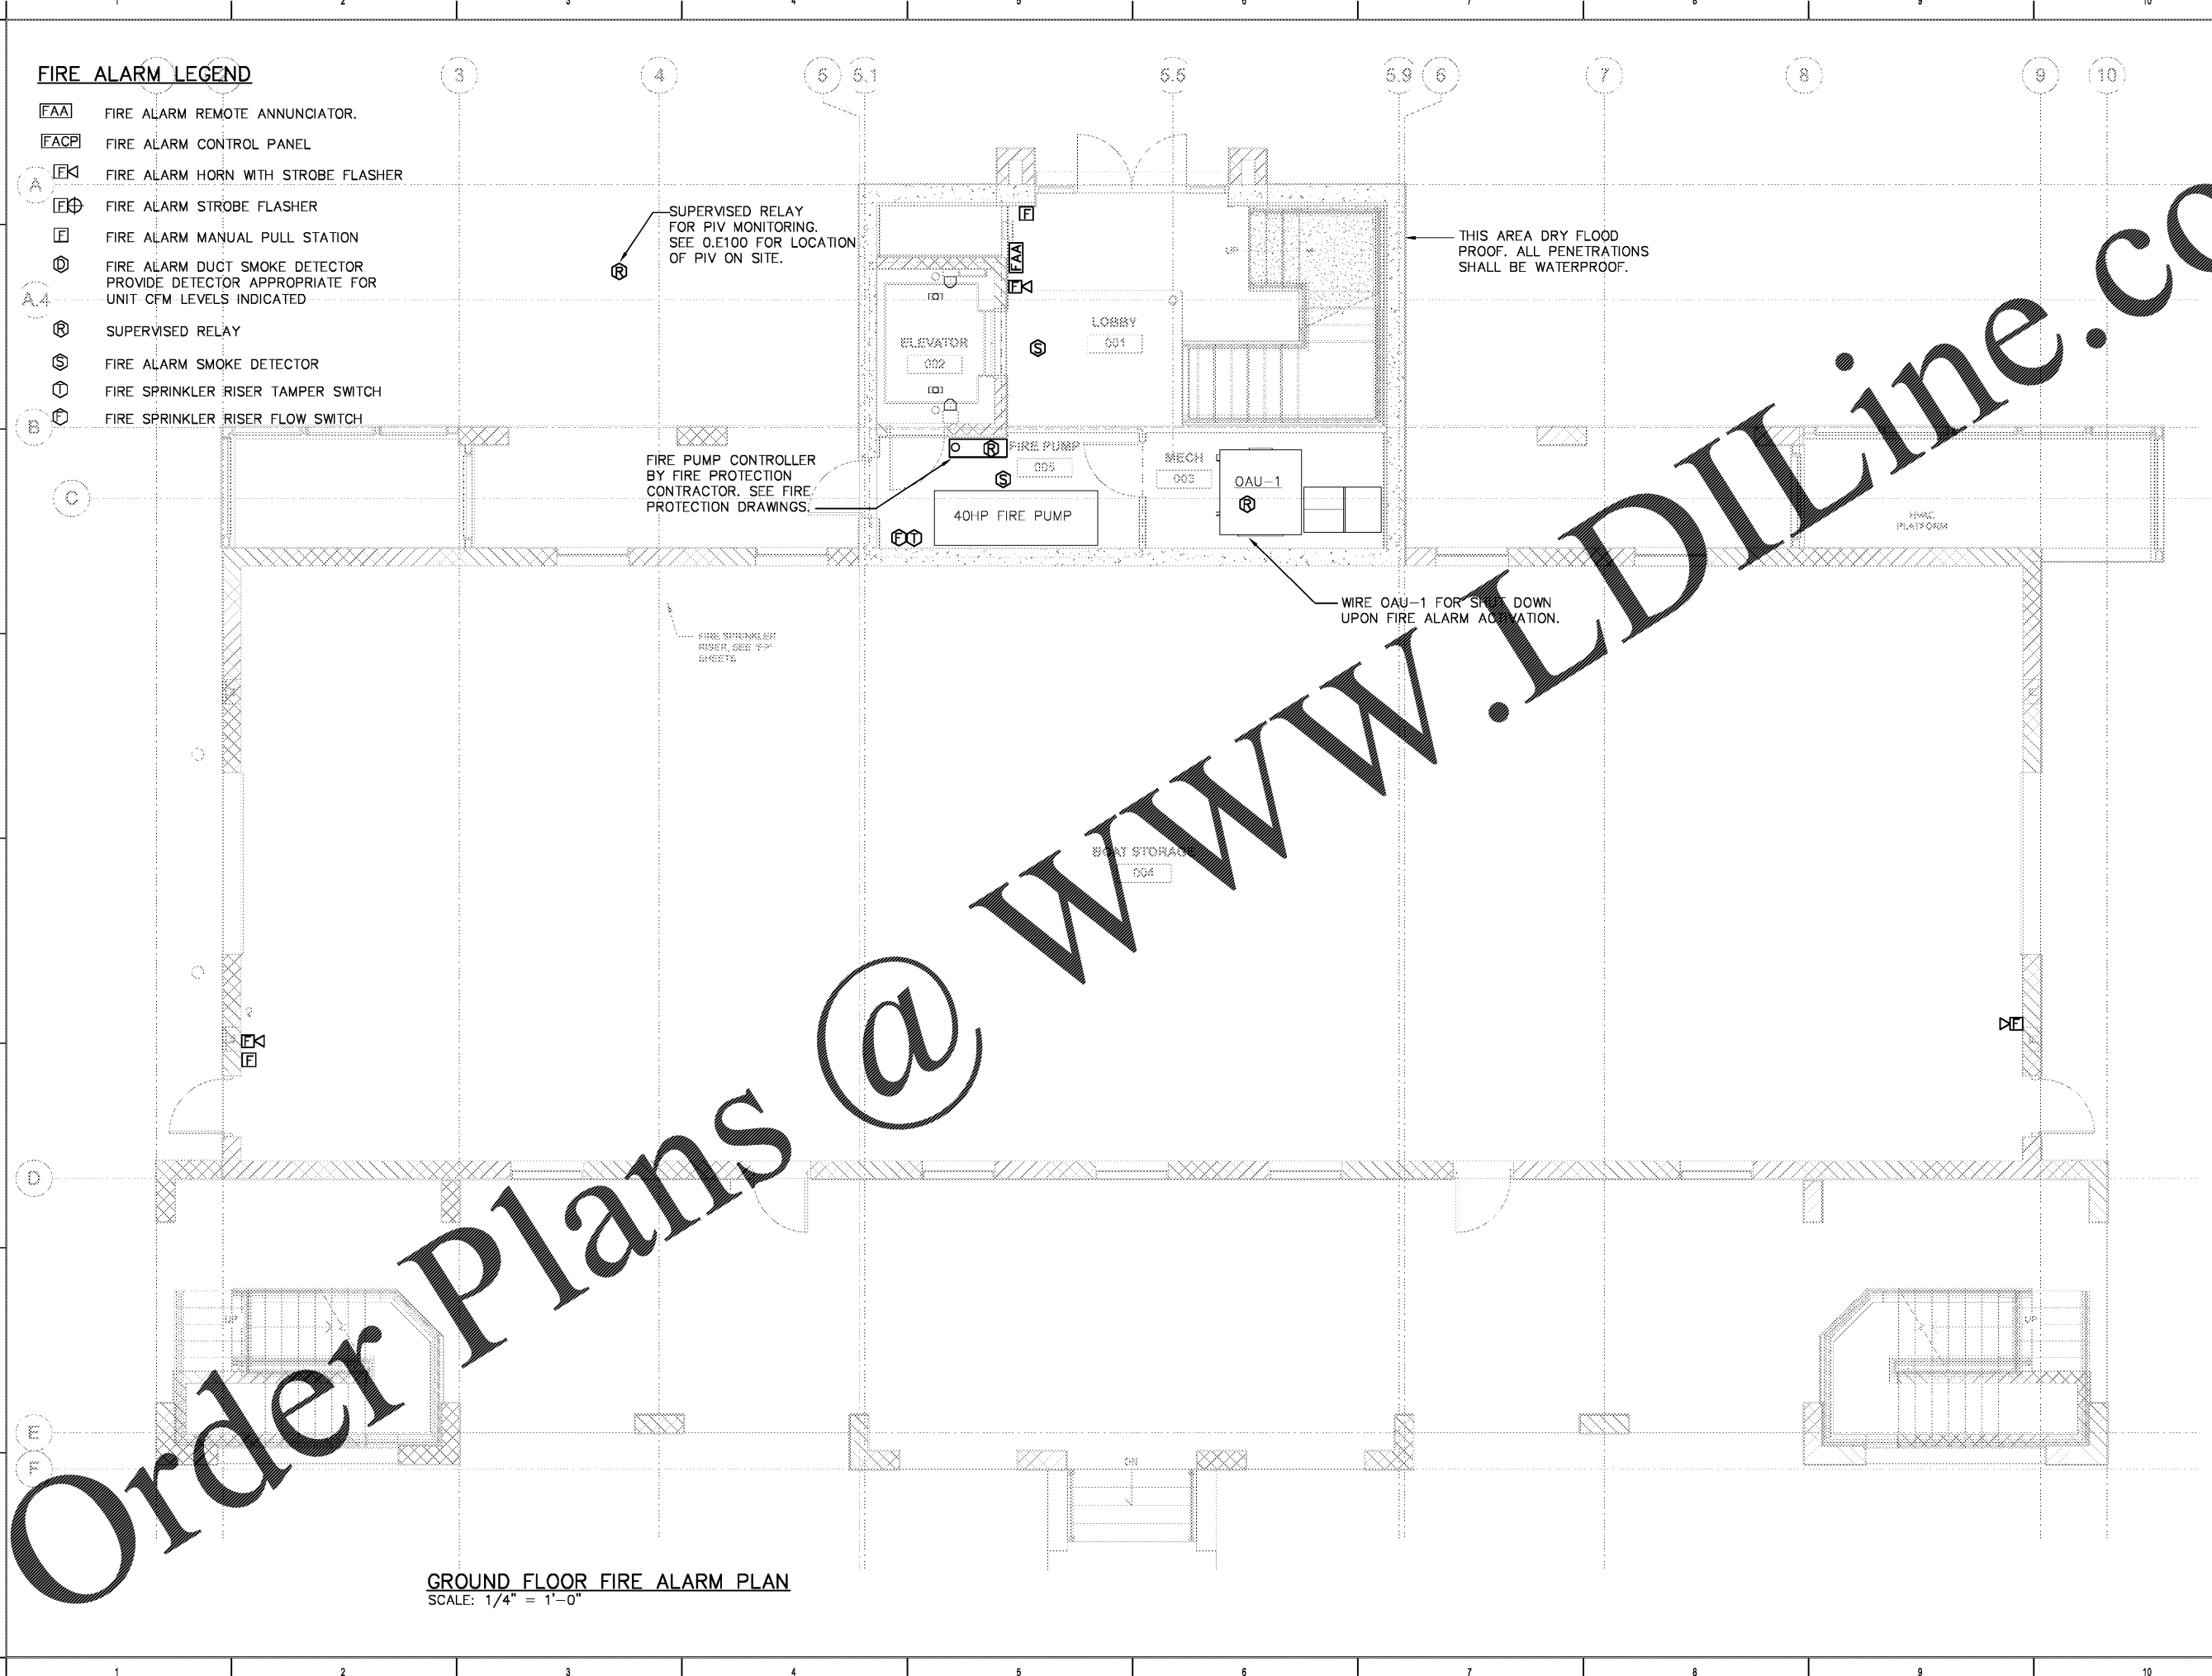

GROUND FLOOR FIRE ALARM PLAN
SCALE: 1/4" = 1'-0"

Order Plans @ www.LDILine.com

coast architects
 671 St. Andrews Blvd., Charleston, SC 29407
 Phone: 843.763.7064 Fax: 843.763.7061
www.coastarchitects.net



DAVID F. WILSON, P.E.
 1421 BRIAN ROAD
 CHARLESTON, SC 29407
 TEL: (843) 225-7191

**BOATING CENTER REDEVELOPMENT-
 SWAIN BOATING CENTER
 H09-9617-PG-C**

THE CITADEL
 11 HAMMOND AVENUE
 CHARLESTON, SC
THE MILITARY COLLEGE OF SOUTH CAROLINA

Revisions	
Rev. No.	Rev. Date

DRAWN BY: DFW
 CHECKED BY: DFW
 DATE: 06.01.2018

COAST PROJECT NO.: 1722.00

GROUND FLOOR
FIRE ALARM
PLAN

1.E301

BID DOCUMENTS