



ALL DESIGNS, DRAWINGS AND SPECIFICATIONS DEPICTED ON THIS SHEET ARE PROPERTY OF COAST ARCHITECTS, INC. COPYRIGHT ©2010. ANY UNAUTHORIZED USE OR REPRODUCTION IS SUBJECT TO LEGAL PROSECUTION. POSSESSION IN ANY FORM CONSTITUTES ACCEPTANCE OF THESE CONDITIONS.

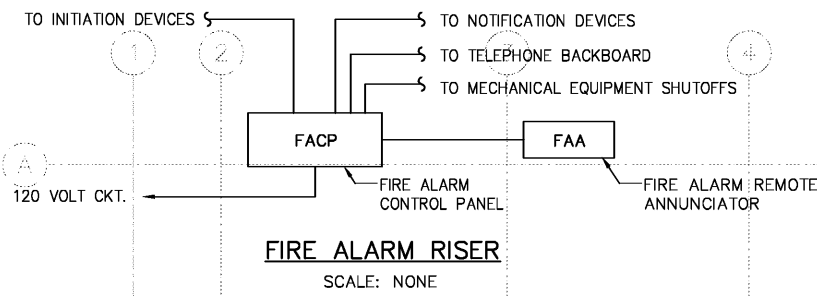

- NOTES:
1. SEE FLOOR PLAN FOR QUANTITY AND TYPE OF INITIATION DEVICES.
  2. SEE FLOOR PLAN ON THIS SHEET FOR QUANTITY AND TYPE OF NOTIFICATION DEVICES.
  3. PROVIDE SUPERVISED RELAY AND MONITOR FIRE SUPPRESSION SYSTEM FOR BUILT-IN APPLIANCE HOOD. COORDINATE WITH INSTALLER.
  4. SEE MECHANICAL PLANS FOR EXACT LOCATIONS OF AIR HANDLERS. SYSTEM SHALL SHUT DOWN ALL AIR HANDLERS IN THE EVENT ANY ONE DUCT DETECTOR INITIATES THE SYSTEM.
  5. DUCT DETECTORS SHALL BE RATED FOR AIR VOLUMES OF EACH AIR HANDLER. SEE MECHANICAL PLANS FOR AIR VOLUMES.
  6. SEE SITE PLAN AND O.E100 FOR LOCATION OF PIV. PROVIDE SUPERVISED RELAY FOR MONITORING OF VALVE POSITION.

**Order Plans @**

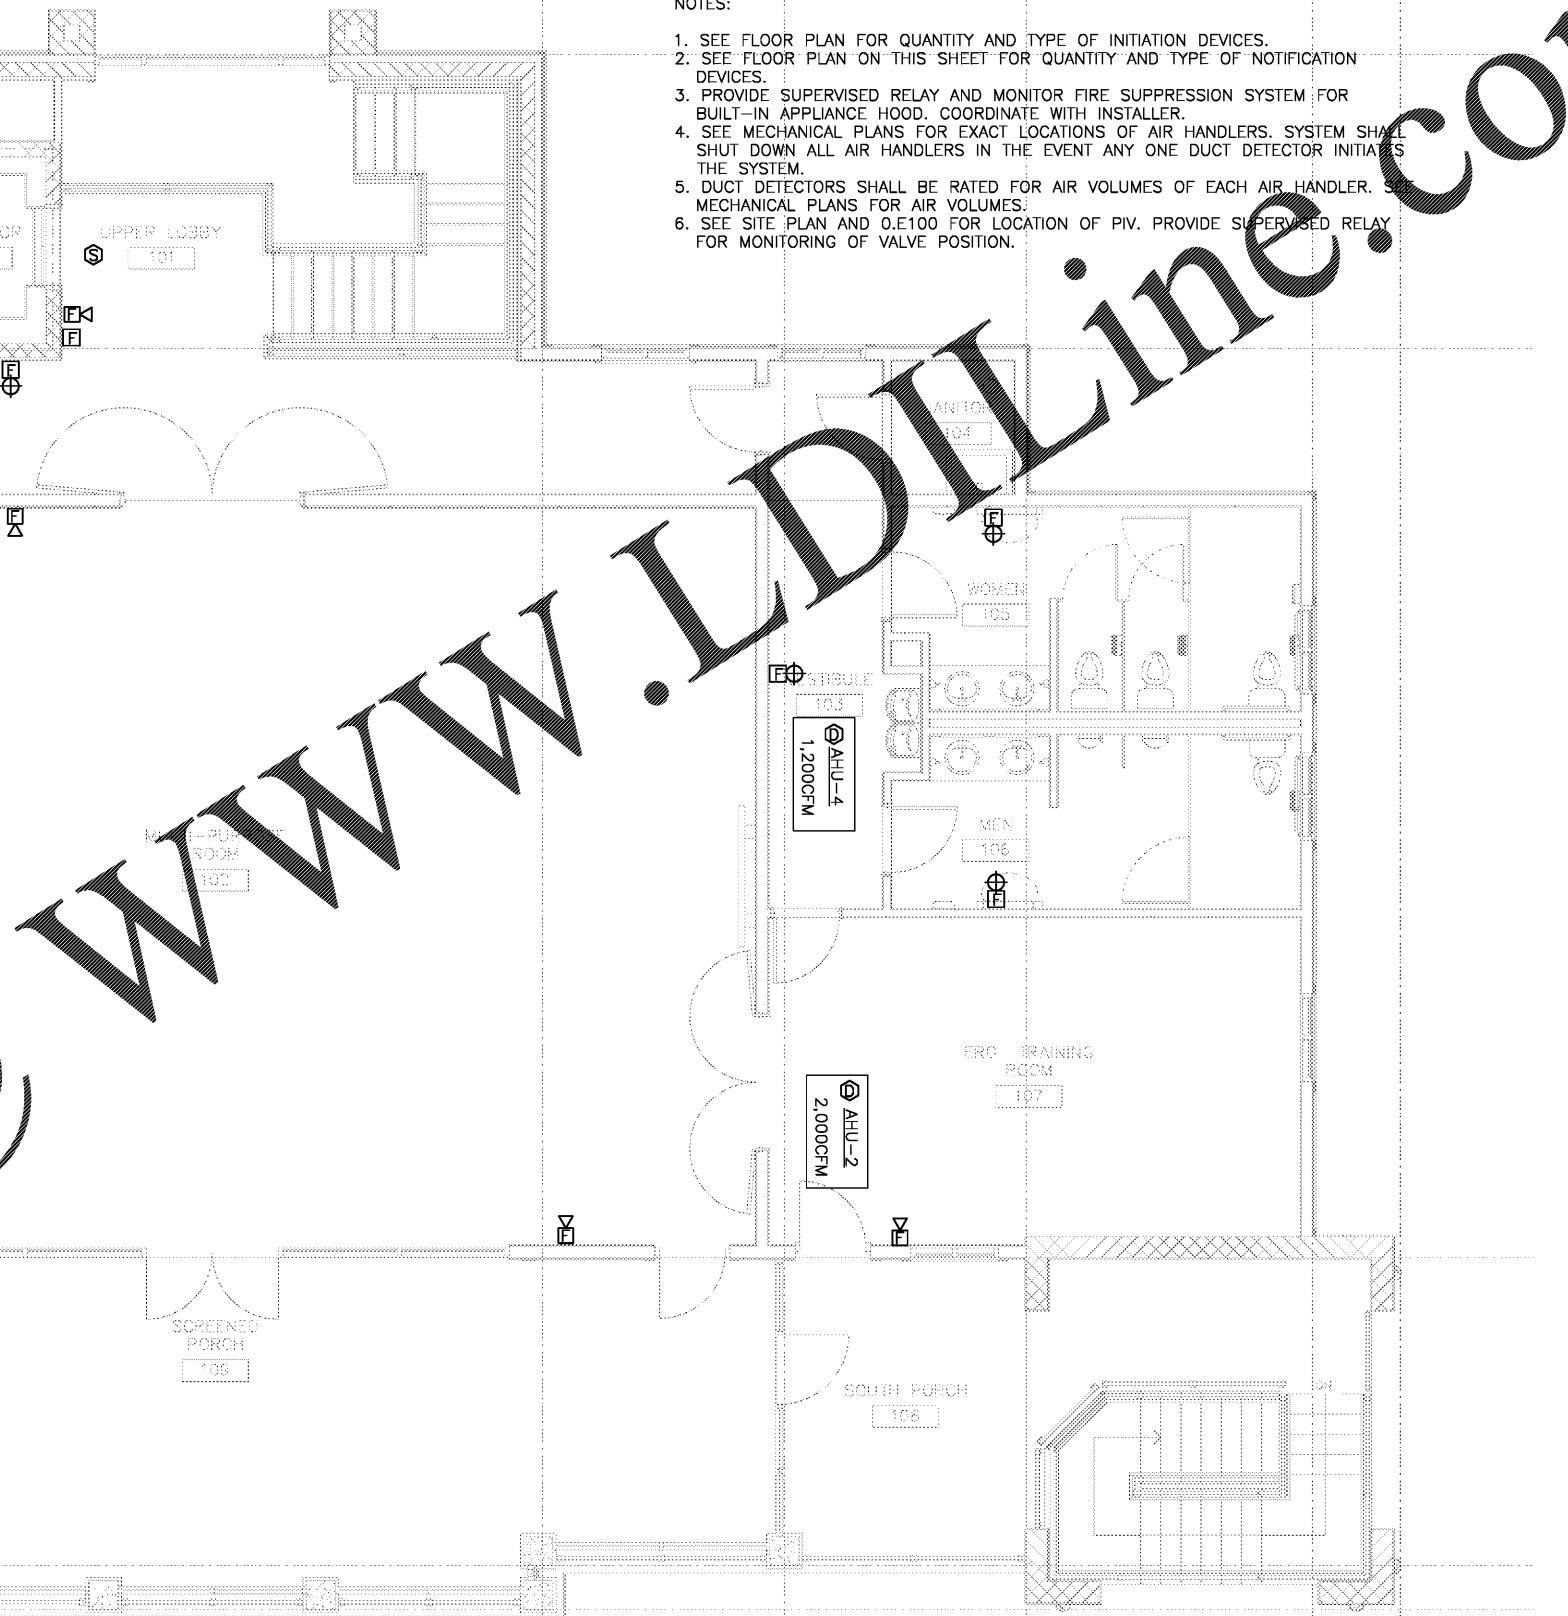

**FIRST FLOOR FIRE ALARM PLAN**  
SCALE: 1/4" = 1'-0"

**coast architects**  
671 St. Andrews Blvd., Charleston, SC 29407  
Phone: 843.763.7064 Fax: 843.763.7061  
www.coastarchitects.net



**DAVID F. WILSON, P.E.**  
1421 BRIAN ROAD  
CHARLESTON, SC 29407  
TEL: (843) 225-7191

**BOATING CENTER REDEVELOPMENT-  
SWAIN BOATING CENTER**  
H09-9617-PG-C

**THE CITADEL**  
11 HAMMOND AVENUE  
CHARLESTON, SC

THE MILITARY COLLEGE OF SCIENTIFIC CAROLINA

Revisions	
Rev. No.	Rev. Date

DRAWN BY: DFW  
CHECKED BY: DFW  
DATE: 06.01.2018

COAST PROJECT NO.: 1722.00

FIRST FLOOR  
FIRE ALARM  
PLAN

BID DOCUMENTS

1.E302