


ALL DESIGNS, DRAWINGS AND SPECIFICATIONS DEPICTED ON THIS SHEET ARE PROPERTY OF COAST ARCHITECTS, INC. COPYRIGHT © 2018 ANY UNAUTHORIZED USE OR REPRODUCTION IS SUBJECT TO LEGAL PROSECUTION. POSSESSION IN ANY FORM CONSTITUTES ACCEPTANCE OF THESE CONDITIONS.
 2:55:45 PM

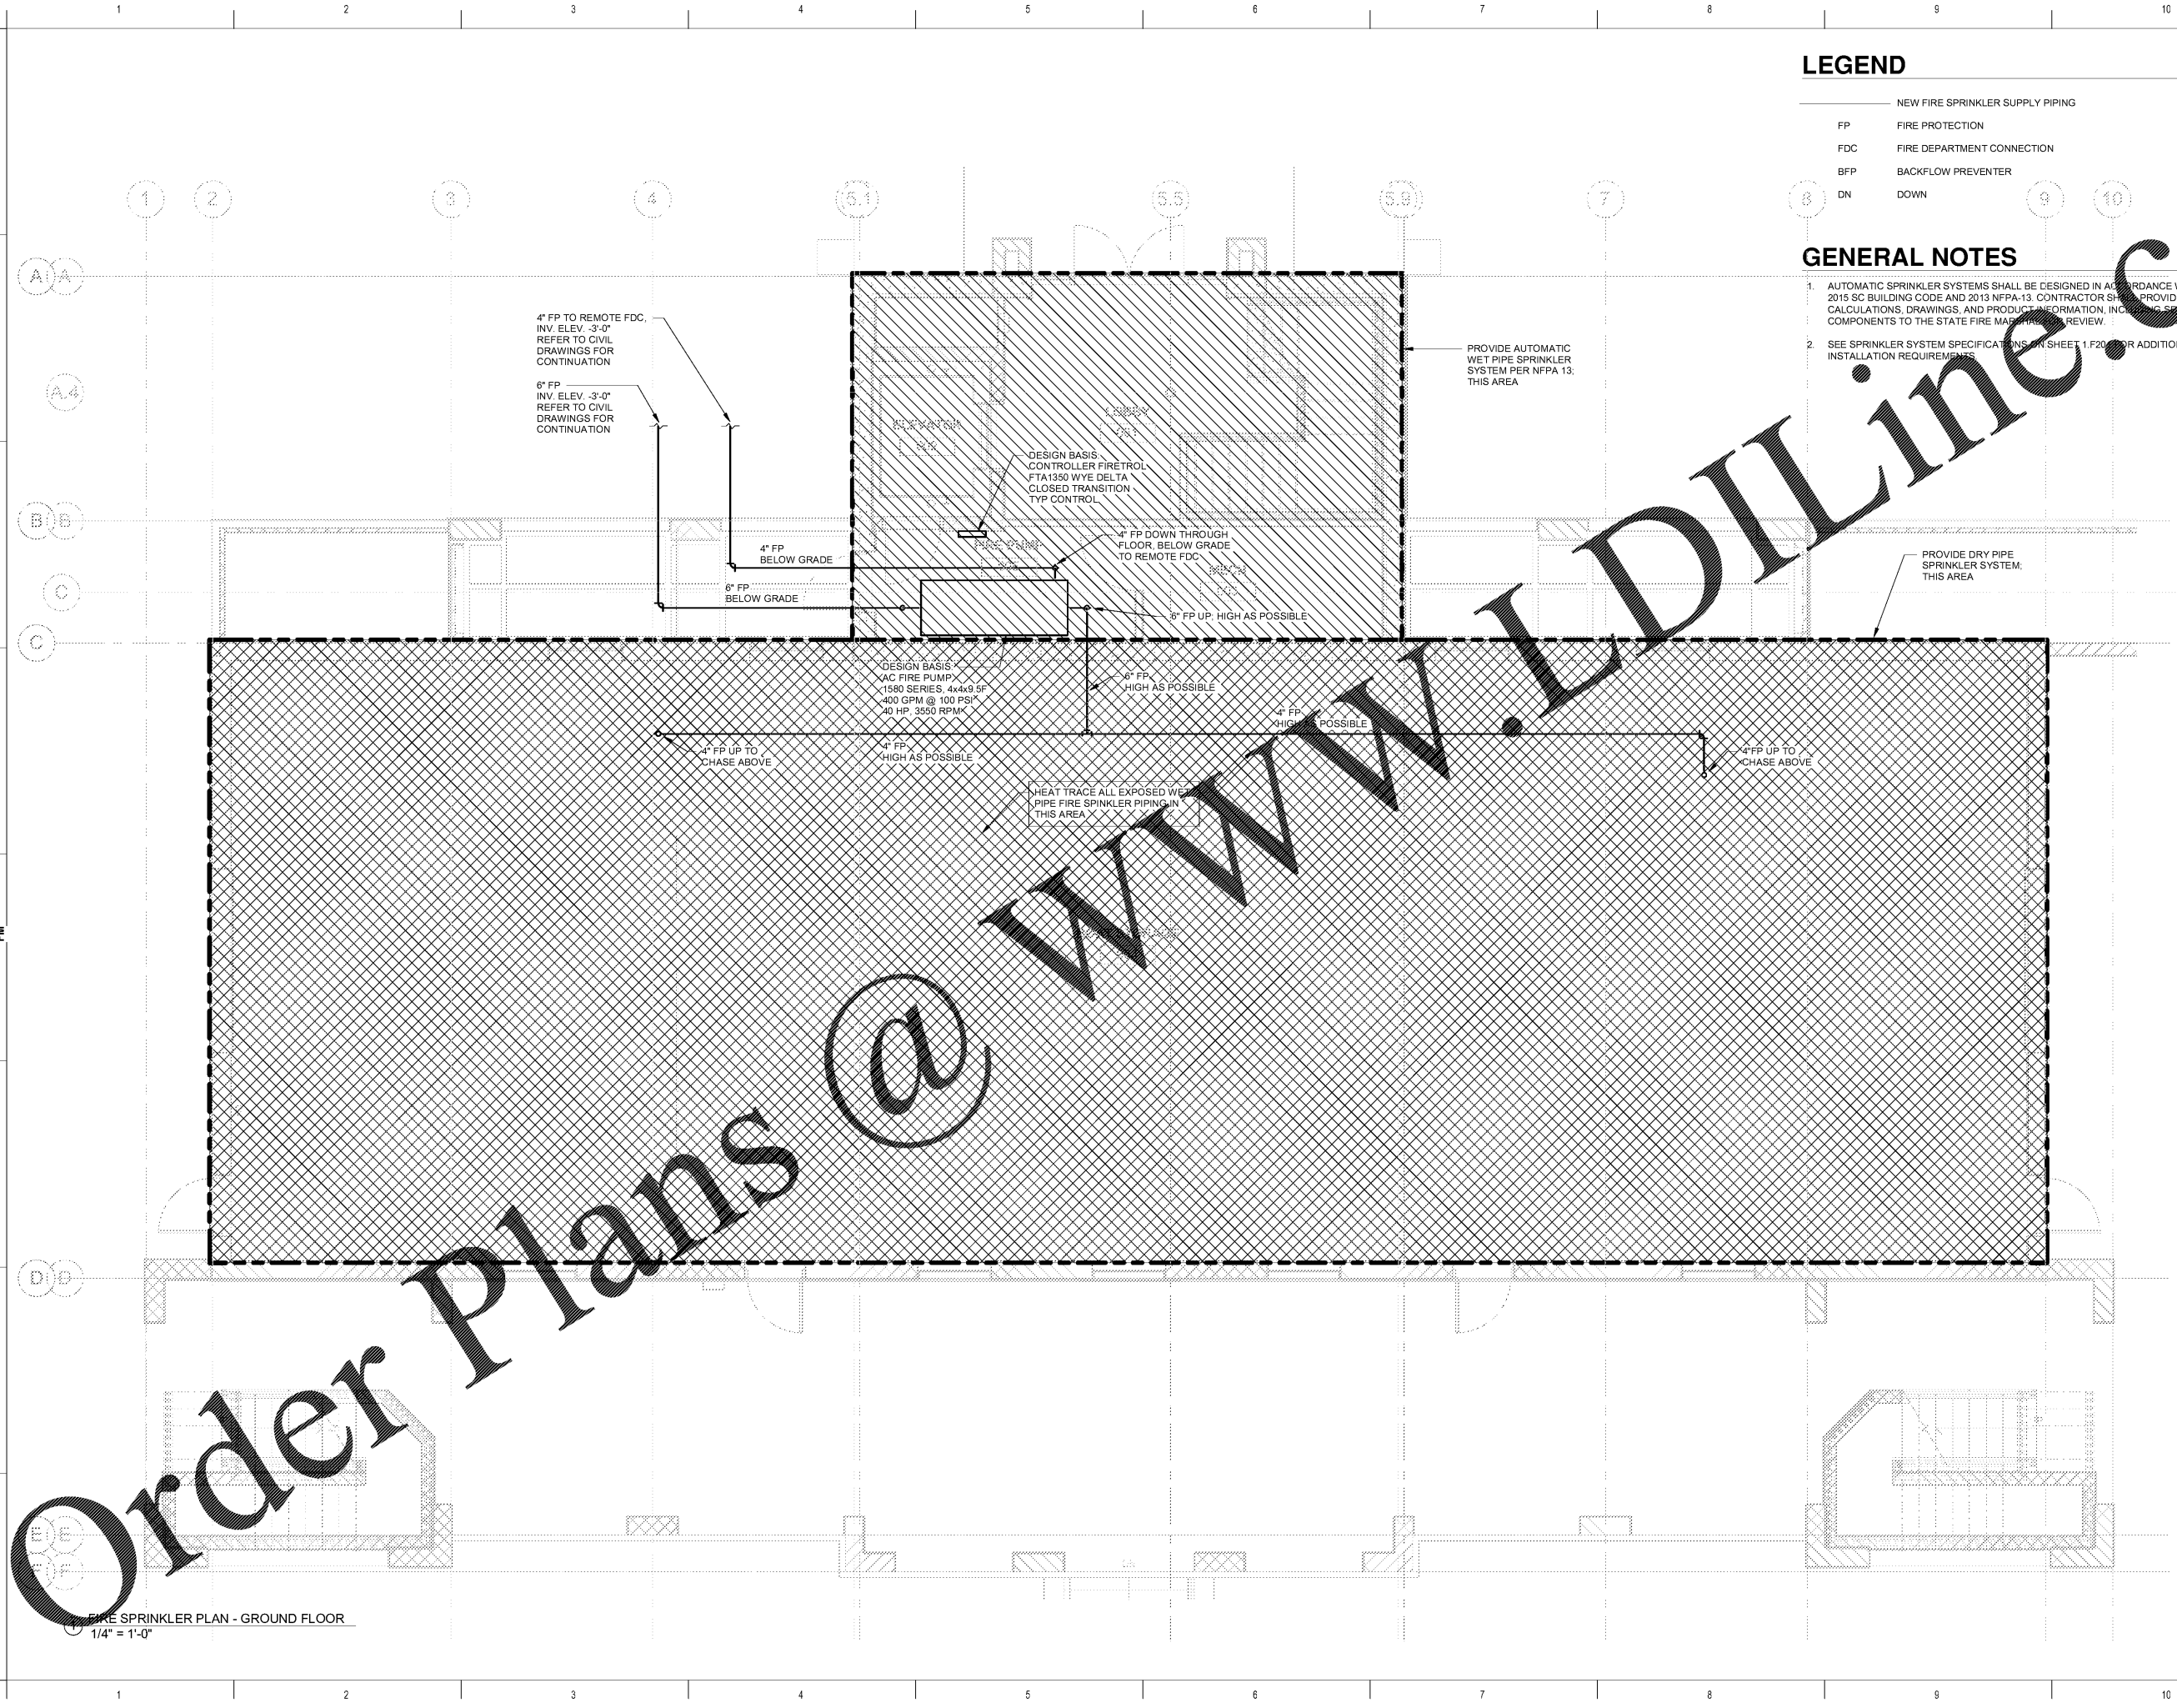

LEGEND

- NEW FIRE SPRINKLER SUPPLY PIPING
- FP FIRE PROTECTION
- FDC FIRE DEPARTMENT CONNECTION
- BFP BACKFLOW PREVENTER
- DN DOWN


GENERAL NOTES

1. AUTOMATIC SPRINKLER SYSTEMS SHALL BE DESIGNED IN ACCORDANCE WITH THE 2015 SC BUILDING CODE AND 2013 NFPA-13. CONTRACTOR SHALL PROVIDE DESIGN CALCULATIONS, DRAWINGS, AND PRODUCT INFORMATION, INCLUDING SPECIFIC COMPONENTS TO THE STATE FIRE MARSHAL FOR REVIEW.
2. SEE SPRINKLER SYSTEM SPECIFICATIONS ON SHEET 1.F20 FOR ADDITIONAL INSTALLATION REQUIREMENTS.


Order Plans @ WWW.LDILine.com

FIRE SPRINKLER PLAN - GROUND FLOOR
 1/4" = 1'-0"

coast architects
 671 St. Andrews Blvd., Charleston, SC 29407
 Phone: 843.763.7064 Fax: 843.763.7061
 www.coastarchitects.net

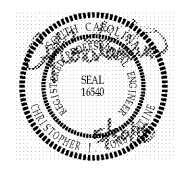

CONSTANTINE ENGINEERING ASSOCIATES, LLC
 1433 Savannah Hwy #114, Charleston, SC 29407
 Phone: 843.629.7979, Fax: 843.629.9781

BOATING CENTER REDEVELOPMENT - SWAIN BOATING CENTER
 H09-9617-PG-C
 **THE CITADEL**
 11 HAMMOND AVENUE
 CHARLESTON, SC

Revisions	
Rev. No.	Rev. Date

DRAWN BY: TJR
 CHECKED BY: CJC
 DATE: 06.01.2018
 COAST PROJECT NO: 17-069

FIRE SPRINKLER PLAN
1.F101

BID DOCUMENTS