

ALL DESIGNS, DRAWINGS AND SPECIFICATIONS DEPICTED ON THIS SHEET ARE PROPERTY OF COAST ARCHITECTS, INC. COPYRIGHT © 2018 ANY UNAUTHORIZED USE OR REPRODUCTION IS SUBJECT TO LEGAL PROSECUTION. POSSESSION IN ANY FORM CONSTITUTES ACCEPTANCE OF THESE CONDITIONS.  
 2:59:47 PM

PLUMBING FIXTURE SCHEDULE								
NOTE: MODELS SHOWN ARE BASIS OF DESIGN. EQUIVALENT PRODUCTS BY OTHER MANUFACTURER'S MAY BE ACCEPTED.								
MARK	DESCRIPTION	MFR	MODEL	CW	HW	WASTE	VENT	NOTES
WH	FROST PROOF WALL HYDRANT		LFFHB	3/4"				


**PLUMBING LEGEND**

- WH WALL HYDRANT
- COLD WATER LINE, CW
- GAS LINE, G
- ⊕ BALL VALVE

**PLUMBING GENERAL NOTES**

- G1 PROVIDE LABOR, EQUIPMENT AND MATERIALS TO COMPLETE THE PLUMBING WORK INDICATED ON THESE DRAWINGS AS REQUIRED BY LOCAL CODE AND ORDINANCES.
- G2 INCLUDE DOMESTIC COLD WATER PIPING, AS INDICATED ON THESE DRAWINGS AS WELL AS HOOKUP OF FIXTURES AND INSULATION OF PIPING.
- G3 INCLUDE ITEMS, SUCH AS FITTINGS, ETC. NOT MENTIONED BUT UNDERSTOOD TO BE NECESSARY TO COMPLETE THE PLUMBING SYSTEM.
- G4 WATER PIPING MATERIALS MUST MEET OR EXCEED LOCAL CODES. PROVIDE WATER SUMP ARRESTERS IN ACCORDANCE WITH THE SOUTH CAROLINA PLUMBING CODE AND LOCAL ORDINANCES.
- G5 LOCATE PLUMBING FIXTURES PER ARCHITECTURAL DRAWINGS. PIPING IS SHOWN IN GENERAL LOCATION. EXACT LOCATION WILL BE DETERMINED BY JOB CONDITIONS.
- G6 COMPLETE WORK IN ACCORDANCE WITH THE SOUTH CAROLINA PLUMBING CODE AND LOCAL ORDINANCES. SEE SPECIFICATIONS FOR PRODUCT AND INSTALLATION REQUIREMENTS. GUARANTEE WORK UNDER THIS CONTRACT TO BE FREE FROM DEFECTIVE WORKMANSHIP, MATERIALS AND EQUIPMENT FOR ONE YEAR AFTER ACCEPTANCE OF THE BUILDING BY THE OWNER. SHOULD SUCH DEFECTS OCCUR DURING THE ONE YEAR PERIOD, REPAIR AND/OR REPLACE DEFECTIVE ITEMS AND DAMAGE RESULTING FROM THE FAILURE OF THESE ITEMS AT NO EXPENSE WHATSOEVER TO THE OWNER.
- G9 COORDINATE BONDING OF METALLIC PIPES (GAS, WATER, ETC.) WITH ELECTRICAL.

**coast architects**  
 671 St. Andrews Blvd., Charleston, SC 29407  
 Phone: 843.763.7064 Fax: 843.763.7061  
 www.coastarchitects.net

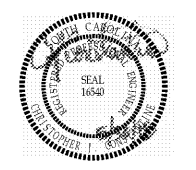

**CONSTANTINE ENGINEERING ASSOCIATES, LLC**  
 1438 Savannah Hwy #111, Charleston, SC 29407  
 Phone: 843.629.7979, Fax: 843.624.9784

**BOATING CENTER REDEVELOPMENT - SWAIN BOATING CENTER**  
 H09-9617-PG-C



Revisions	
Rev. No.	Rev. Date

DRAWN BY: DDF  
 CHECKED BY: CJC  
 DATE: 06.01.2018


COAST PROJECT NO: 17-069

**PLUMBING PLAN**

**2.P101**

BID DOCUMENTS

Order Plans @ WWW.LDILLING.COM

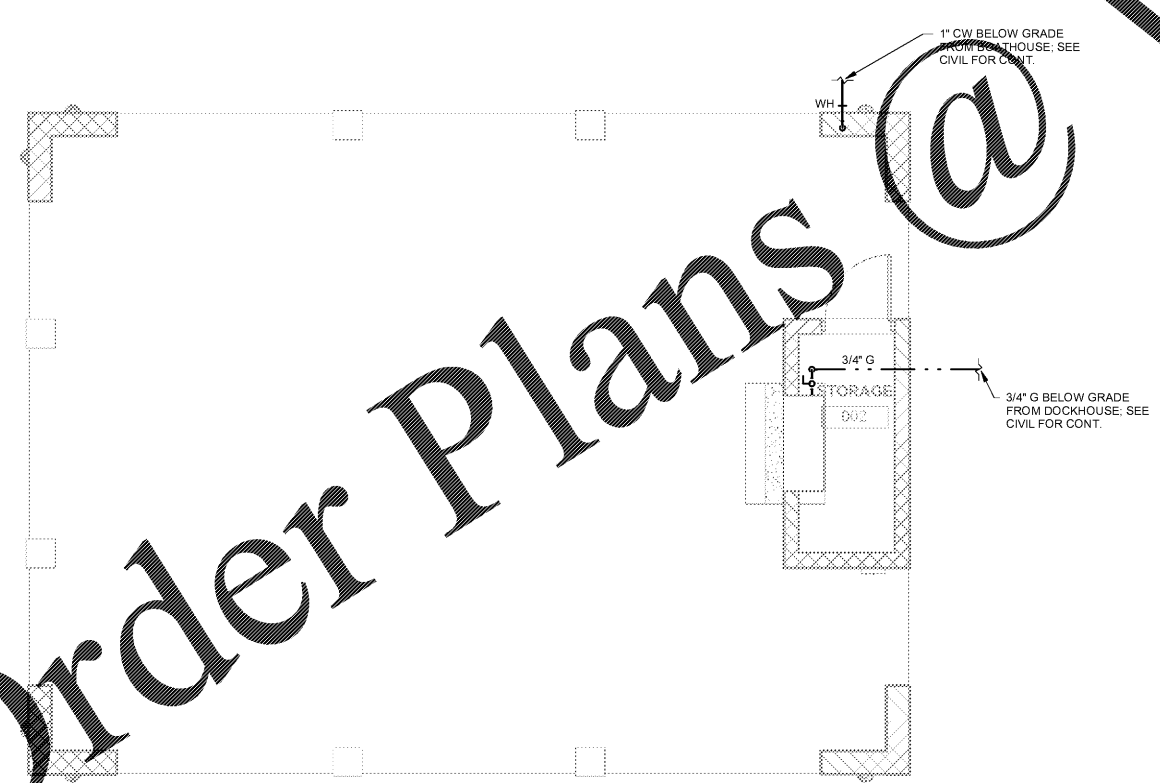

1 PLUMBING PLAN  
 1/4" = 1'-0"