



Order Plans @

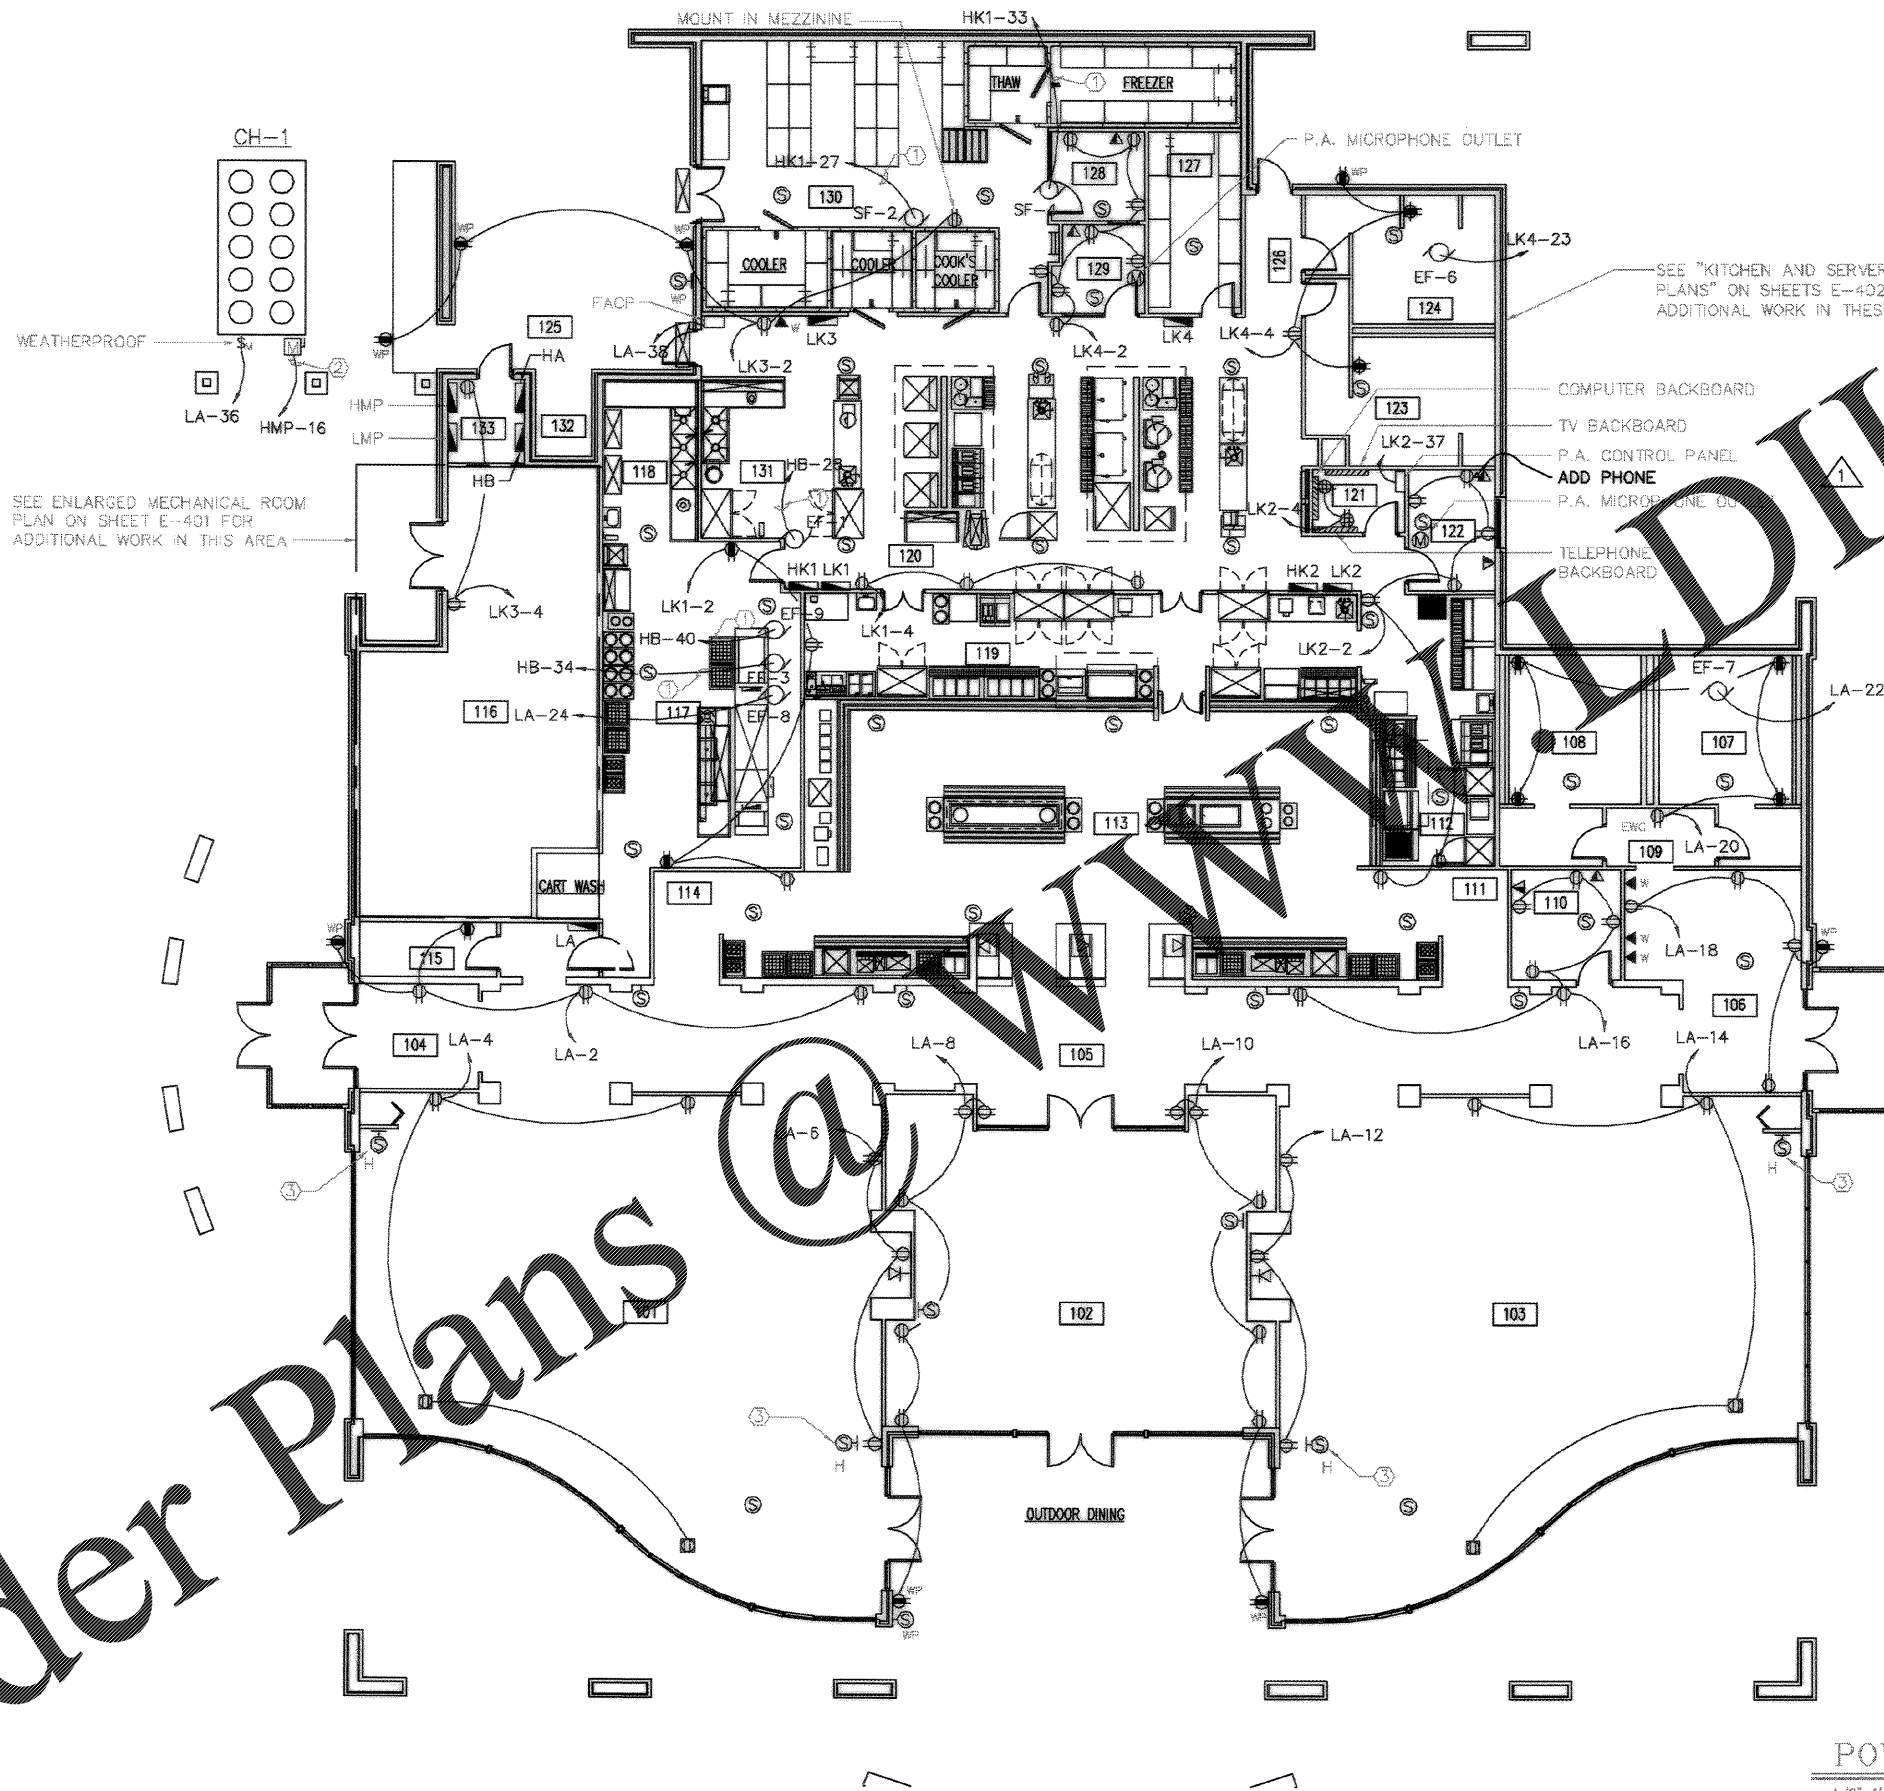

- KEYED NOTES (THIS SHEET ONLY)
- ① 3#12, 1#12G, 1/2" C
 - ② 3#4/0, 1#4G, 2" C
 - ③ MOUNT AS HIGH AS PRACTICAL ON WALL.

POWER PLAN
1/8"=1'-0"

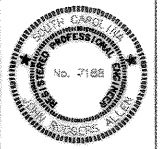

RECORD DRAWING DATE	9/27/14
CODE ID NO.	8081
DRAWING SIZE	D
SPEC. NO. D6-88-0338	
CONSTN. CONTR. NO. N62467-88-C-0339	
NAVFAC DRAWING NO. 535799B	
SHEET 173 OF 184	
E-105	

Naval Facilities Engineering Command
Southern Division
Charleston, South Carolina

CHARLESTON AIR FORCE BASE CHARLESTON, SOUTH CAROLINA
DINING FACILITY
POWER PLAN
APPROVED: [Signature] DATE: 9/27/14

DESIGNER	DR. SCOTT W. ALLEN
CHECKED BY	DR. SCOTT W. ALLEN
DATE	9/27/14
PROJECT NO.	535799B
DRAWING NO.	E-105
SHEET NO.	173 OF 184
SCALE	1/8"=1'-0"
PROJECT	CHARLESTON AIR FORCE BASE
LOCATION	CHARLESTON, SOUTH CAROLINA
CONTRACT NO.	N62467-88-C-0339
CONTRACTOR	EPIC ENGINEERING INC.
ENGINEER	DR. SCOTT W. ALLEN
REGISTERED PROFESSIONAL ENGINEER	NO. 000259
STATE OF SOUTH CAROLINA	

SEE "KITCHEN AND SERVERY ELECTRICAL PLANS" ON SHEETS E-402 AND E-403 FOR ADDITIONAL WORK IN THESE AREAS.

COMPUTER BACKBOARD
TV BACKBOARD
P.A. CONTROL PANEL
ADD PHONE
P.A. MICROPHONE OUTLET
TELEPHONE BACKBOARD

SEE ENLARGED MECHANICAL ROOM PLAN ON SHEET E-401 FOR ADDITIONAL WORK IN THIS AREA.

WEATHERPROOF