


Order Plans

WWW.DILine.com

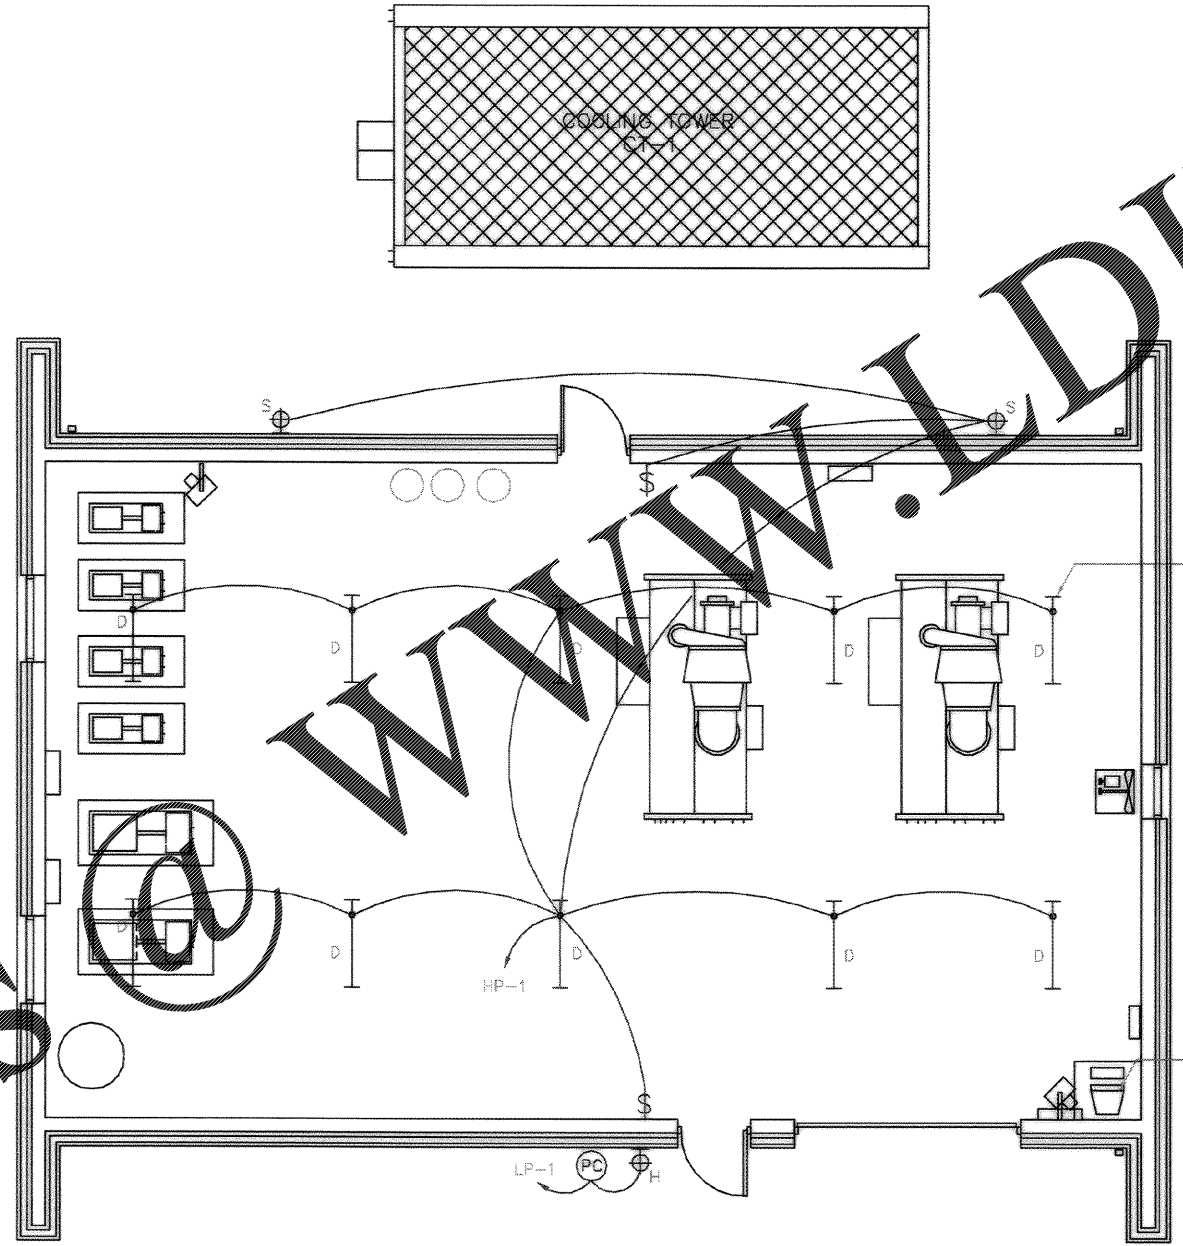


CHILLER PLANT LIGHTING PLAN (CHILLER PLANT REPLACEMENT OPTION)  
SCALE: 1/4"=1'-0"

Glick/Boehm & Assoc.  
247 Meeting St.  
Charleston, S.C. 29403  
6377

Rev.	Description	Prep. By	Date	Appr.
1	AS-BUILT DRAWING TO CONCRETE	WJW	5/11/04	WJW

CHARLESTON AIR FORCE BASE  
CHARLESTON, SOUTH CAROLINA  
DINING FACILITY  
CHILLER PLANT LIGHTING PLAN  
APPROVED: *[Signature]* DATE: 5/11/04  
EPIC, 808 COMMANDEE, MAFAC

Naval Facilities Engineering Command  
Southern Division  
Charleston, South Carolina

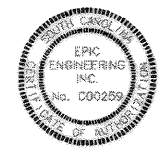

RECORD DRAWING DATE	9/27/84
CODE LB. NO.	BOES1
DRAWING SIZE	D
SPEC. NO.	06-98-09.38
CONFIRM. CONTR. NO.	NS2487-98-C-09.38
NAVFAC DRAWING NO.	5357939
SHEET	174 OF 194

E-106