


Order Plans

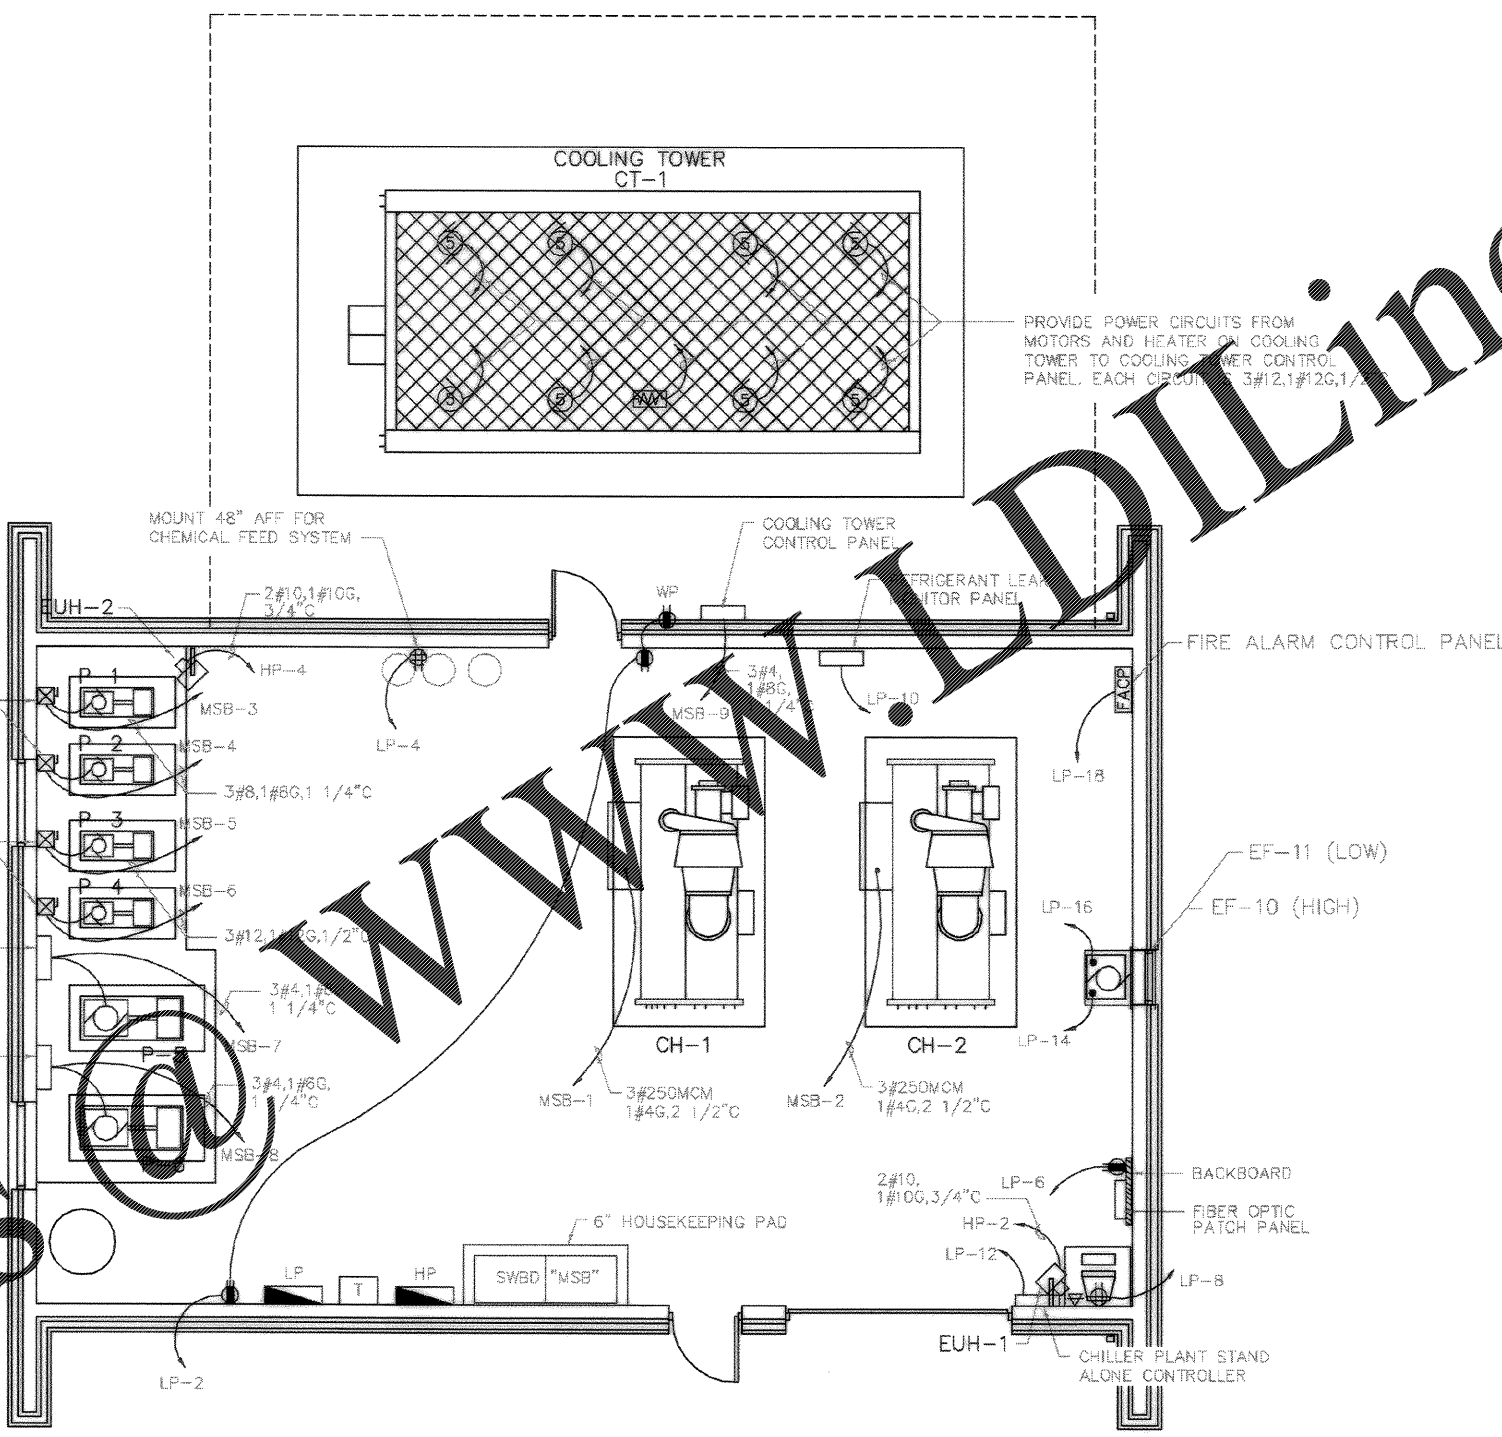

CHILLER PLANT POWER PLAN (CHILLER PLANT REPLACEMENT OPTION)  
SCALE: 1/4" = 1'-0"

WWW.LDILine.com

Glick/Boehm & Associates, Inc. 247 Meeting Street Charleston, S.C. 29401 (803) 577-6377	
Prep By: <b>LDI</b> Date: <b>11/14/14</b>	Approved: <b>LDI</b> Date: <b>11/14/14</b>
Description: <b>AS-BUILT WITH NO CORRECTIONS</b>	
Rev. <b>1</b> Description: <b>AS-BUILT WITH NO CORRECTIONS</b>	Date: <b>11/14/14</b> Drawn: <b>LDI</b> Checked: <b>LDI</b> In Charge: <b>LDI</b> Technician: <b>LDI</b>
APPROVED: <b>LDI</b> DATE: <b>11/14/14</b>	
CHARLESTON AIR FORCE BASE CHARLESTON, SOUTH CAROLINA DINING FACILITY CHILLER PLANT POWER PLAN	
Naval Facilities Engineering Command Southern Division Charleston, South Carolina	
EPIC ENGINEERING INC. No. C00259	
RECORD DRAWING DATE: <b>9/27/14</b> CODE I.D. NO.: <b>B0051</b> DRAWING SIZE: <b>D</b> SPEC. NO.: <b>06-98-0939</b> CONSTR. CONTR. NO.: <b>102467-98-C-0939</b> NAVFAC DRAWING NO.: <b>5388000</b> SHEET 175 OF 194	
<b>E-107</b>	