


NOTE: RUN REFRIGERATION LINES
IN WALL AT THIS AREA.

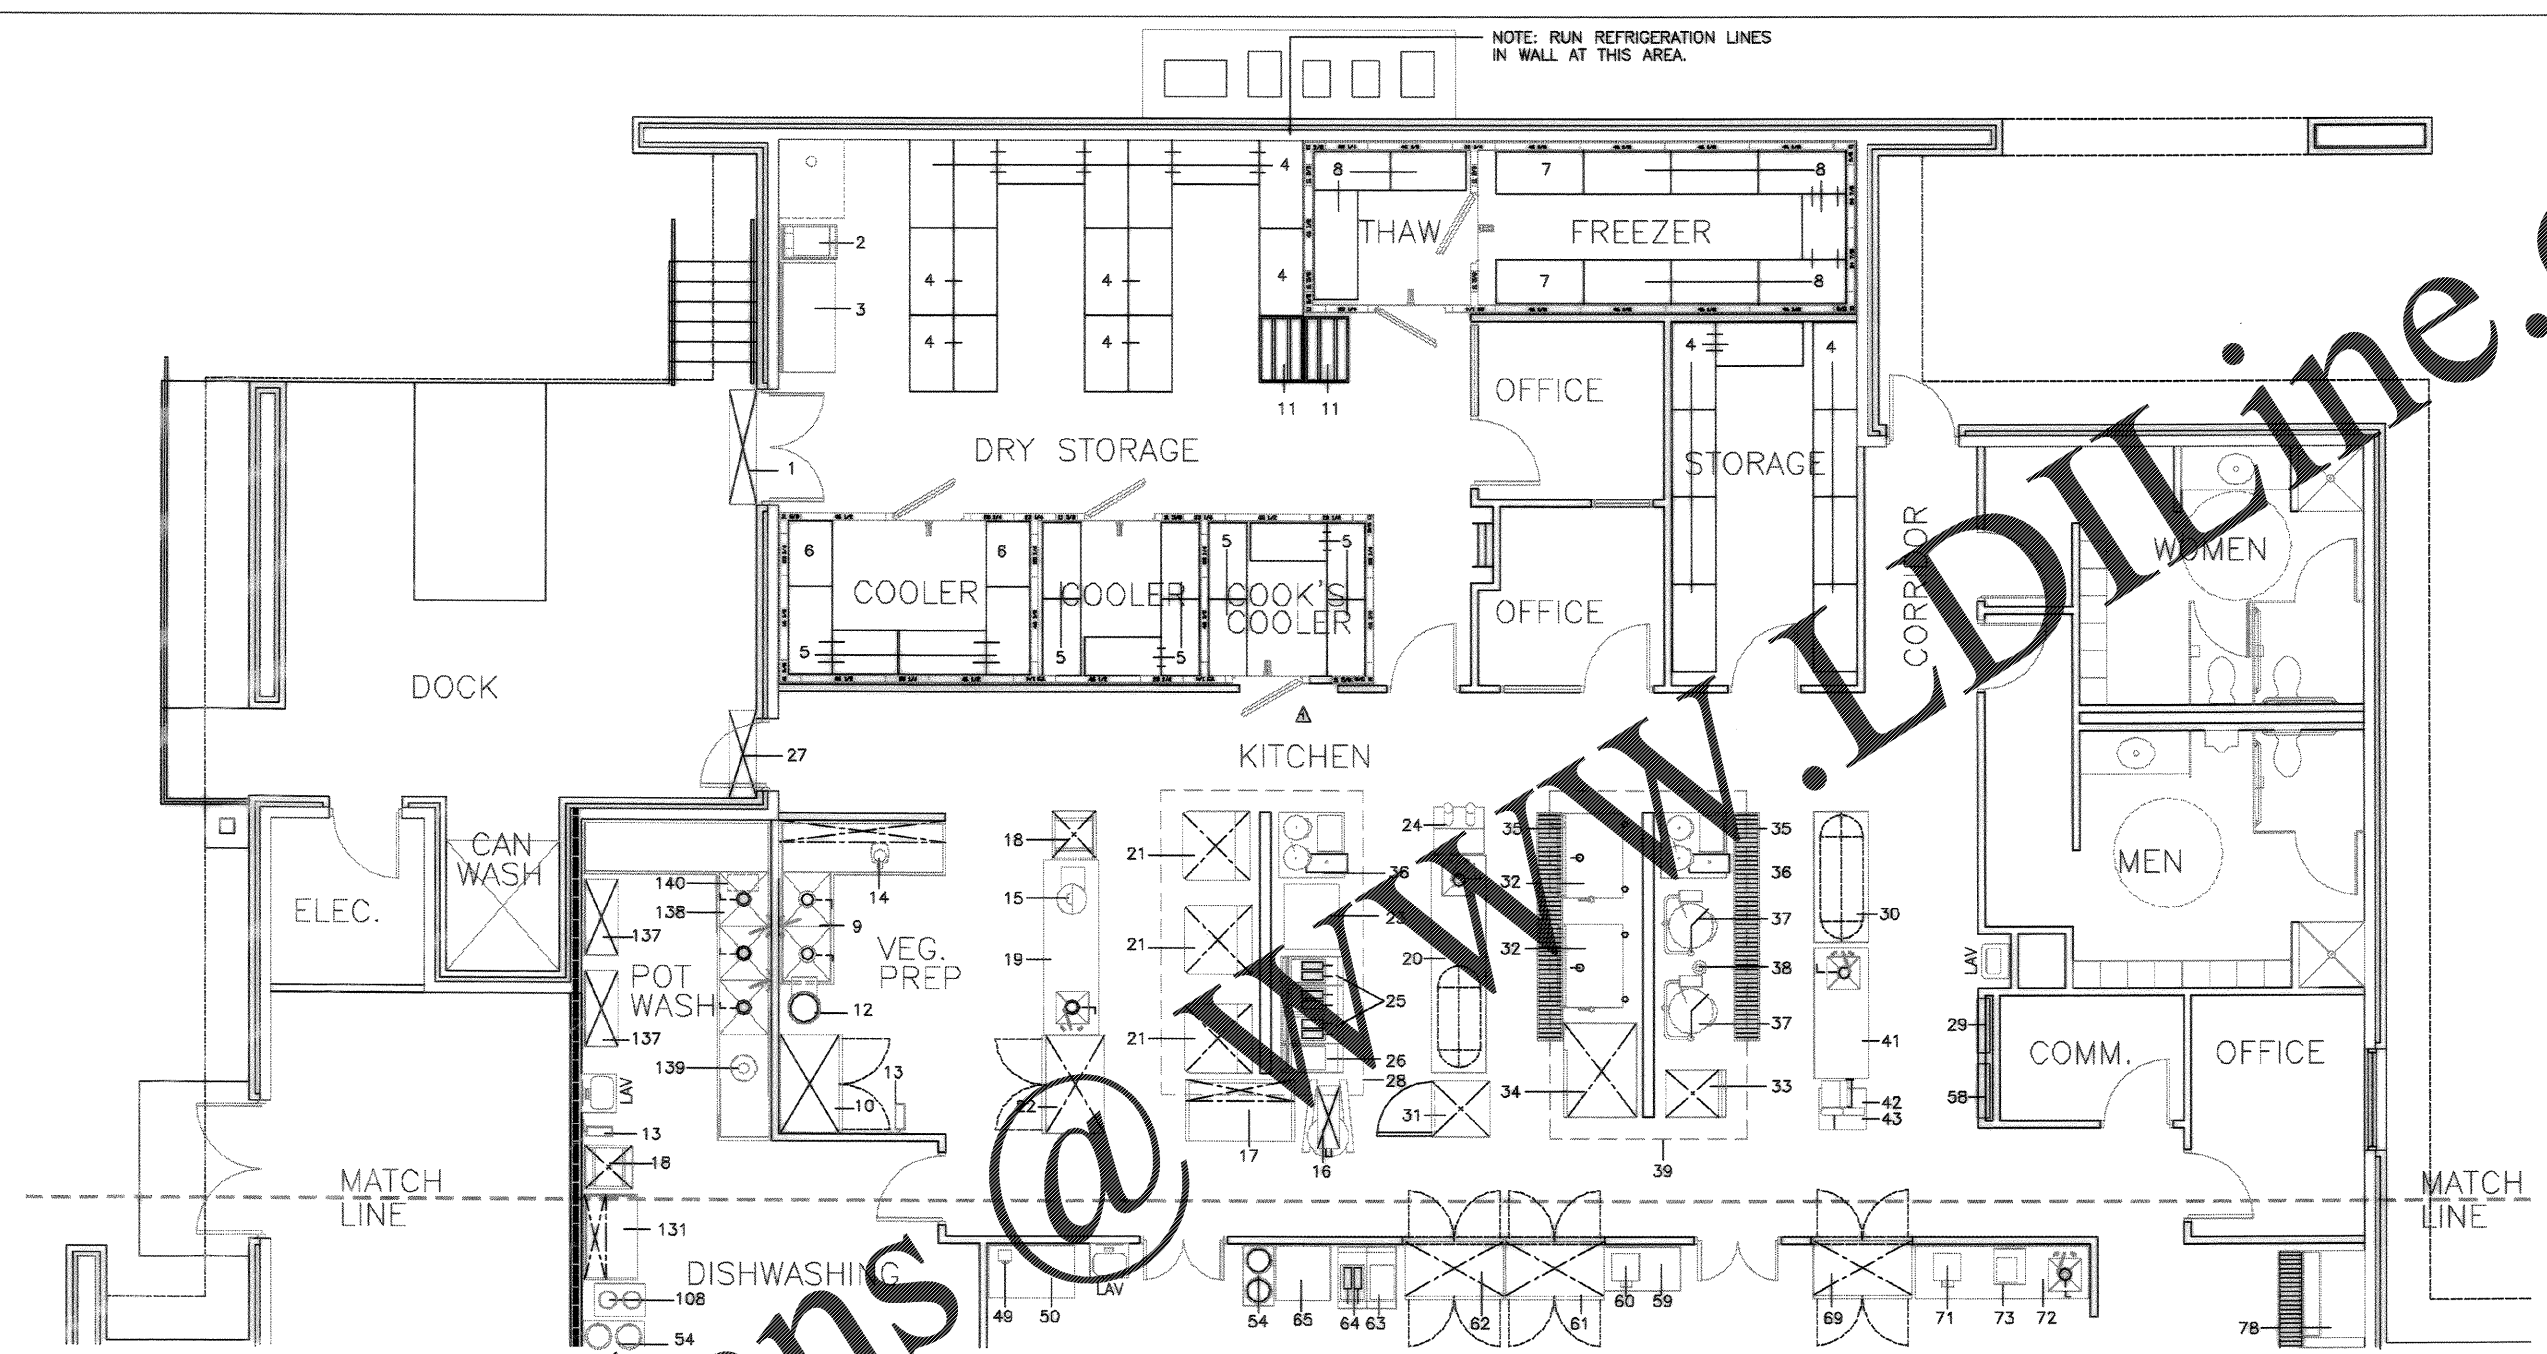

1 KITCHEN AND SERVERY FLOOR PLAN
K102 1/4"=1'-0"

Glick/Backin & Associates, Inc. 247 Meeting Street, Suite 200 Charleston, S.C. 29403 (803) 733-6377							
DRAWING REVISIONS Description 1 DRWG. CORRECTED TO AS-BUILT	Date Approved 11/27/14	Prepped By MLL/AB/ML	Checked By MLL/AB/ML	Submitted By MLL/AB/ML	Scale AS SHOWN	Date 11/27/14	Project No. 14-001
CHARLESTON AIR FORCE BASE CHARLESTON, SOUTH CAROLINA		DINING FACILITY KITCHEN AND SERVERY FLOOR PLAN		APPROVED: <i>[Signature]</i> DATE: 1/14/14 ESD FOR COMMANDER, MAFAC		Naval Facilities Engineering Command Southern Division Charleston, South Carolina	
RECORD DRAWING DATE 9/27/14		CODE I.D. NO. 80091		DRAWING SIZE: 11		SPEC. NO. 06-98-09.59 CONSTR. CONTR. NO. 162467-98-C-09.59 NAVFAC DRAWING NO. 5357925	
SHEET 100 OF 194		K102					

Order Plans @ WWW.LDLINE.COM