



PLUMBING LEGEND & SYMBOLS	
● CW	COLD WATER
● HW	HOT WATER
● V	WASTE/DRAIN
□ FD	FLOOR DRAIN
□ HD	HUB DRAIN
○ G	GAS
○ S	STEAM
○ SR	STEAM RETURN
□ EX	EXHAUST DUCT
— AFF	ABOVE FINISHED FLOOR

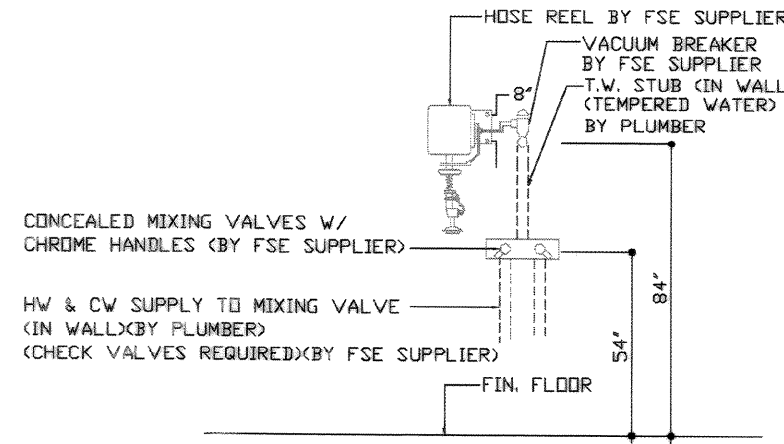

1 TYPICAL HOSE REEL DETAIL
 K301 NOT TO SCALE

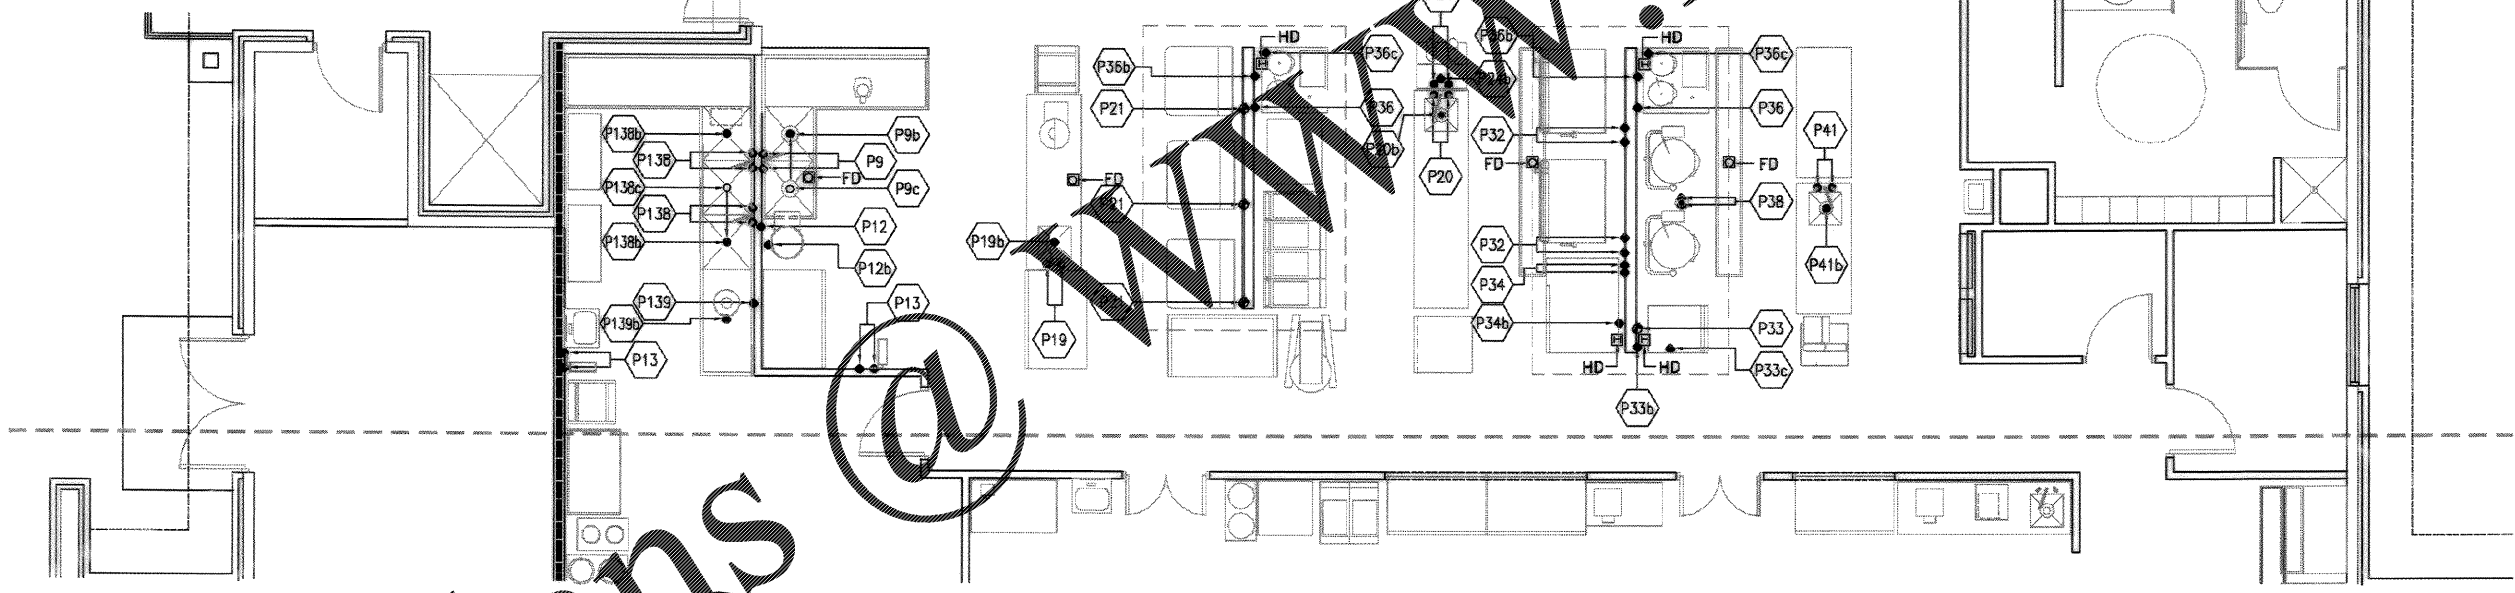

1 PARTIAL PLUMBING CONNECTION PLAN
 K301 1/4"=1'-0"

PLUMBING CONNECTION NOTES

- P9- 1/2" HW & CW OUT OF WALL, 16" AFF, CONNECT TO FAUCET INLETS, 39" AFF.
- P9b- 2" WASTE, 20" AFF.
- P9c- 2" WASTE, 20" AFF, CONNECT TO MAIN DRAIN.
- P12- 1/2" CW OUT OF WALL, 16" AFF, CONNECT TO INLET, 25" AFF.
- P12b- 1-1/2" WASTE, 8" AFF.
- P13- 1/2" HW & CW OUT OF WALL, 5" AFF, EXTEND THRU MIXING VALVE AND VACUUM BREAKER AND CONNECT TO INLET, 84" AFF. (SEE DETAIL)
- P13b- 1/2" HW & CW OUT OF WALL, 5" AFF, EXTEND THRU MIXING VALVE AND VACUUM BREAKER AND CONNECT TO INLET, 84" AFF.
- P13c- 1/2" CW OUT OF WALL, 16" AFF, EXTEND THRU SOLENOID VALVE AND VACUUM BREAKER AND CONNECT TO INLET ON DISPOSER.
- P19- 1/2" HW & CW, STUB-UP AND CONNECT TO FAUCET INLETS, 34" AFF.
- P19b- 2" WASTE, 20" AFF.
- P20- 1/2" HW & CW, STUB-UP AND CONNECT TO FAUCET INLETS, 34" AFF.
- P20b- 2" WASTE, 20" AFF.
- P21- 3/4" GAS INLET, 110,000 BTU, 10" AFF.
- P24- 1/2" HW & CW, STUB-UP AND CONNECT TO INLETS, 8" AFF.
- P24b- 1-1/2" WASTE, 20" AFF.
- P32- 1/2" HW & CW OUT OF WALL, 16" AFF, CONNECT TO FAUCET INLETS, 28" AFF.
- P33- 3/4" GAS INLET, 200,000 BTU, 3" AFF.
- P33b- 1/2" CW OUT OF WALL, 8" AFF, REDUCE TO 1/4" AND CONNECT TO INLET, 8" AFF.
- P33c- 3-1/2" WASTE, 5" AFF, EXTEND TO HUB DRAIN.
- P34- 3/4" HW & CW HOSE CONNECTION, 10" AFF.
- P34b- 2" WASTE, 8" AFF, EXTEND TO HUB DRAIN.
- P36- 1/2" HW OUT OF WALL, 8" AFF, CONNECT TO INLET, 8" AFF.
- P36b- 1/2" CW OUT OF WALL, 8" AFF, REDUCE TO 1/4" AND CONNECT TO INLET, 27" AFF.
- P36c- 2" WASTE, 8" AFF, EXTEND TO HUB DRAIN.
- P38- 1/2" HW & CW, STUB-UP AND CONNECT TO INLETS, 4" AFF.
- P41- 1/2" HW & CW, STUB-UP AND CONNECT TO FAUCET INLETS, 34" AFF.
- P41b- 2" WASTE, 20" AFF.
- P138- 1/2" HW & CW OUT OF WALL, 16" AFF, CONNECT TO FAUCET INLETS, 39" AFF.
- P138b- 2" WASTE, 20" AFF.
- P138c- 2" WASTE, 20" AFF, CONNECT TO MAIN DRAIN.
- P139- 1/2" CW OUT OF WALL, 16" AFF, EXTEND THRU SOLENOID VALVE AND VACUUM BREAKER AND CONNECT TO INLET ON DISPOSER.
- P139b- 2" WASTE, 20" AFF.

HOT WATER REQUIREMENTS		
ITEM	DESCRIPTION	GPH
9	VEG. PREP. TABLE W/ SINK	74
19	WORK TABLE W/ SINK	11
20	WORK TABLE W/ SINK	11
24	HAND SANITIZER	XXX
41	WORK TABLE W/ SINK	11
138	POT & PAN SINK	111
	LAV. @ 5 GAL. EA.	10

IT IS THE INTENT OF THIS DRAWING TO SHOW PLUMBING AND MECHANICAL CONNECTION POINTS. FOR FINAL ROUGH-IN DRAWINGS, SEE CONTRACTORS DETAIL SHOP DRAWINGS. ALLOWANCES SHALL BE MADE FOR TRIM, FITTINGS AND ACCESSORIES

Naval Facilities Engineering Command
 Southern Division
 Charleston, South Carolina

RECORD DRAWING DATE: 7/27/84
 CODE NO.: 60091
 DRAWING SIZE: D
 SPEC. NO. 06-98-0939
 CONSTR. CONTR. NO. M62467-98-C-0939
 NAVFAC DRAWING NO. 5357931
 SHEET 106 OF 194

K301

Order Plans @

WorldLine.com