


ELECTRICAL LEGEND & SYMBOLS	
W	WATTS
KW	KILOWATTS
HP	HORSEPOWER
AMPS.	AMPERES
REC'PT.	RECEPTACLE
V	VOLTS
⊕	PHASE
⊙	SINGLE RECEPTACLE
⊕⊙	DUPLEX RECEPTACLE
⊙	CONVENIENCE RECEPTACLE
⊙	STUB-UP/SPECIAL
⊙	FLEXIBLE CONDUIT
⊙	JUNCTION BOX
⊙	ABOVE FINISHED FLOOR

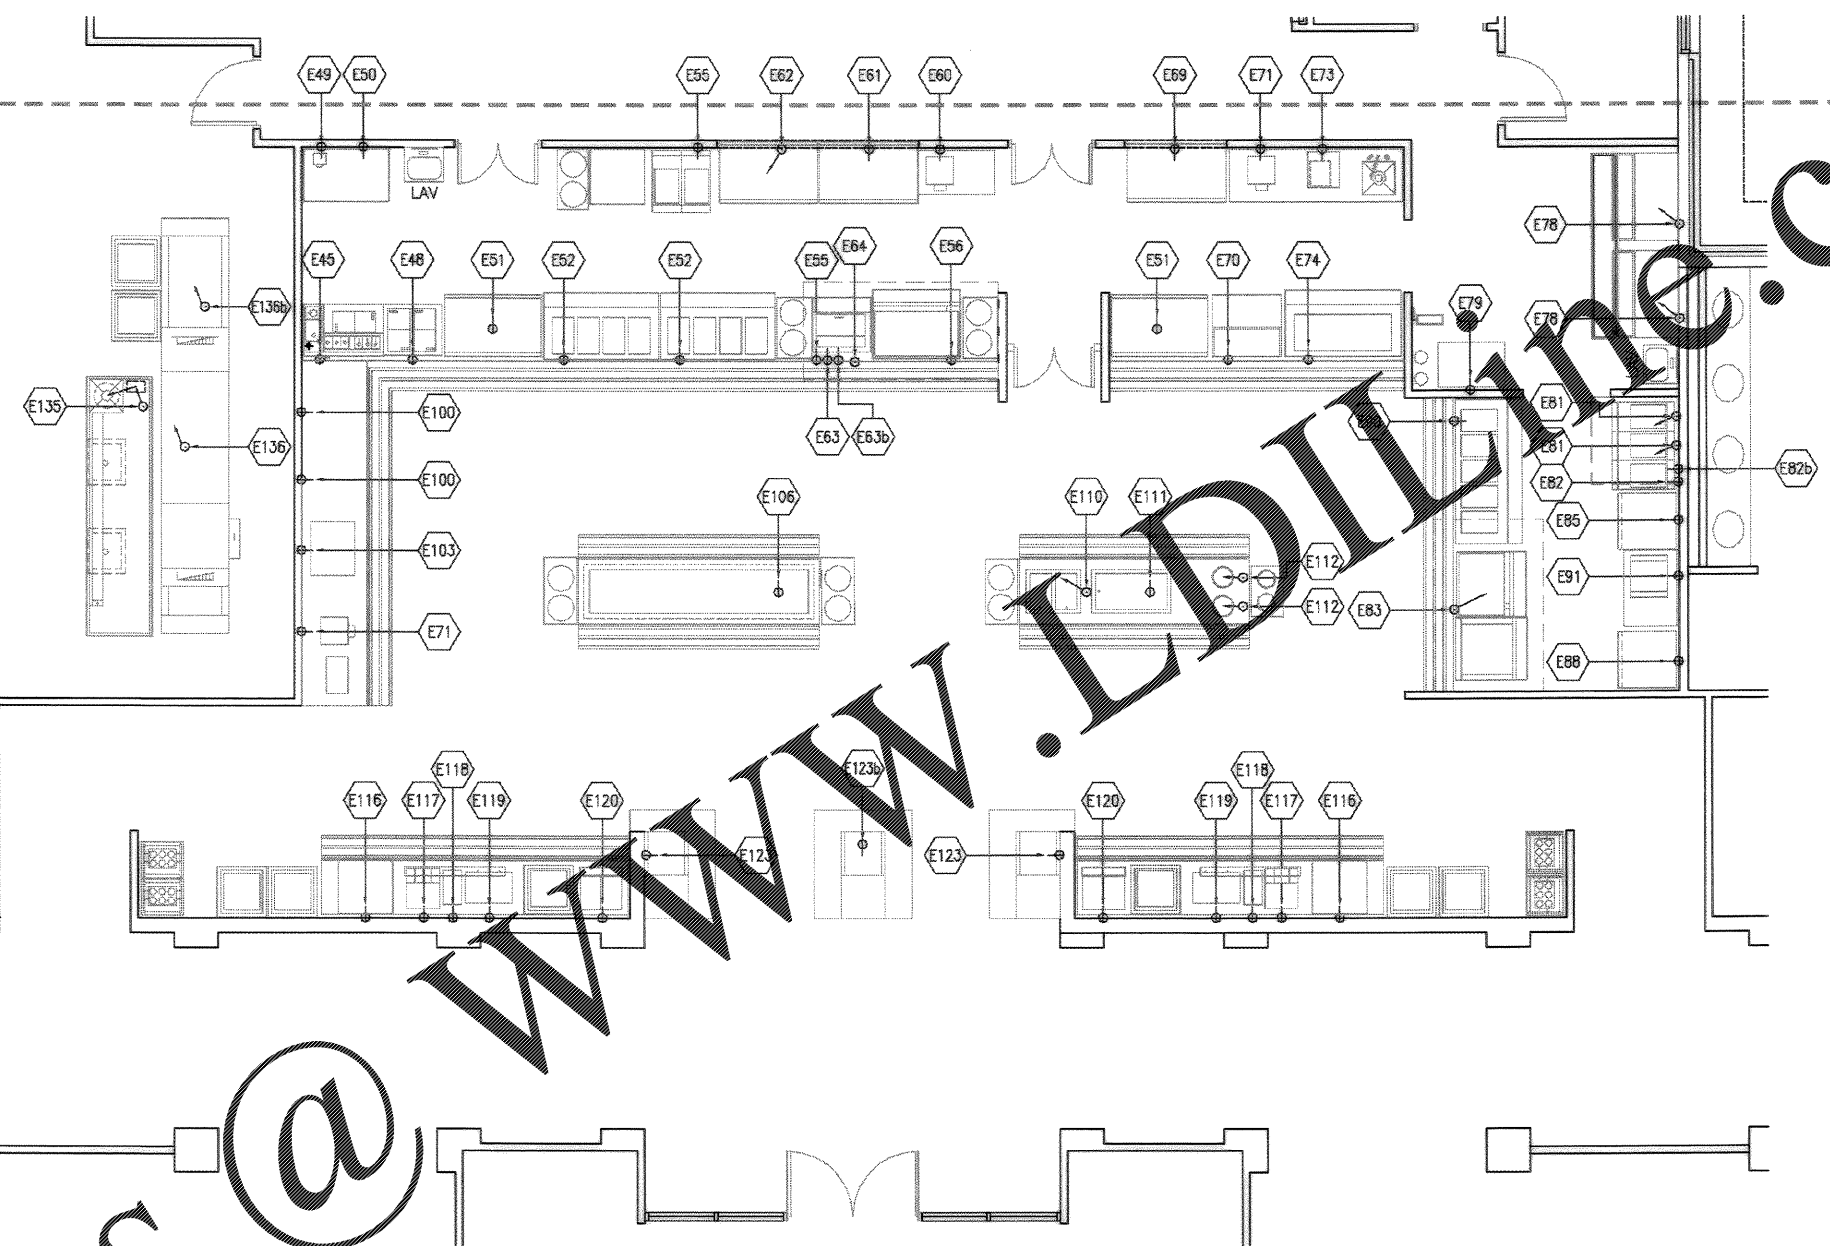

IT IS THE INTENT OF THIS DRAWING TO SHOW ELECTRICAL CONNECTION POINTS. FOR FINAL ROUGH-IN DRAWINGS, SEE CONTRACTORS DETAIL SHOP DRAWINGS. ALLOWANCES SHOULD BE MADE FOR TRIM, FITTINGS AND ACCESSORIES.

PARTIAL ELECTRICAL CONNECTION PLAN

ELECTRICAL CONNECTION NOTES

- E45- 1/3 HP, 7.5 AMPS, 120V/60/1 PHASE REC'PT., FLUSH W/ WALL, 24" AFF.
- E48- 1/5 HP, 2.0 AMPS, 120V/60/1 PHASE REC'PT., FLUSH W/ WALL, 24" AFF.
- E49- 1/7 HP, 1.0 AMPS, 120V/60/1 PHASE REC'PT., FLUSH W/ WALL, 48" AFF.
- E50- 1/3 HP, 120V/60/1 PHASE CONVENIENCE REC'PT., FLUSH W/ WALL, 48" AFF.
- E51- 1/2 HP, 10.0 AMPS, 120V/60/1 PHASE DROP CORD REC'PT. FROM CEILING, 80" AFF.
- E52- 3.6 KW, 30 AMPS (FUSED), 208V/60/1 PHASE REC'PT., FLUSH W/ WALL, 16" AFF.
- E55- 1/5 HP, 2.0 AMPS, 120V/60/1 PHASE REC'PT., FLUSH W/ WALL, 24" AFF.
- E56- 21.0 KW, 19.5 AMPS, 480V/60/3 PHASE REC'PT., FLUSH W/ WALL, 48" AFF.
- E60- 17.0 W, 14.2 AMPS, 120V/60/1 PHASE REC'PT., FLUSH W/ WALL, 48" AFF.
- E61- 886 W, 1/2 HP, 11.0 AMPS, 120V/60/1 PHASE REC'PT., FLUSH W/ WALL, 88" AFF.

- E63- 3080 W, 14.2 AMPS, 120-208V/60/1 PHASE SERVICE OUT OF WALL, 88" AFF, CONNECT TO TERMINALS, 72" AFF.
- E63b- 1/3 HP, 9.0 AMPS, 120V/60/1 PHASE REC'PT., FLUSH W/ WALL, 24" AFF.
- E64- 825 W, 6.9 AMPS, 120V/60/1 PHASE REC'PT., FLUSH W/ WALL, 24" AFF.
- E69- 17.0 KW, 21.0 AMPS, 480V/60/3 PHASE REC'PT., FLUSH W/ WALL, 24" AFF.
- E70- 886 W, 1/2 HP, 11.0 AMPS, 120V/60/1 PHASE REC'PT., FLUSH W/ WALL, 88" AFF.
- E71- 1/3 HP, 10.0 AMPS, 120V/60/1 PHASE REC'PT., FLUSH W/ WALL, 24" AFF.
- E73- 3.8 KW, 18.1 AMPS, 208V/60/1 PHASE REC'PT., FLUSH W/ WALL, 48" AFF.
- E74- 2.2 KW, 120V/60/1 PHASE REC'PT., FLUSH W/ WALL, 48" AFF.
- E74- 1/4 HP, 15.0 AMPS (FUSED), 120V/60/1 PHASE REC'PT., FLUSH W/ WALL, 16" AFF.
- E78- 22.8 AMPS, 208V/60/3 PHASE SERVICE OUT OF WALL, 72" AFF, CONNECT TO TERMINALS, 76" AFF.
- E79- 1/2 HP, 120V/60/1 PHASE REC'PT., FLUSH W/ WALL, 16" AFF.

- E81- 17.0 KW, 21.0 AMPS, 480V/60/3 PHASE SERVICE OUT OF WALL, 16" AFF, CONNECT TO TERMINALS, 25" AFF.
- E82- 1/3 HP, 9.0 AMPS, 120V/60/1 PHASE REC'PT., FLUSH W/ WALL, 24" AFF.
- E82b- 825 W, 6.9 AMPS, 120V/60/1 PHASE REC'PT., FLUSH W/ WALL, 24" AFF.
- E83- 16.2 KW, 19.5 AMPS, 480V/60/3 PHASE SERVICE OUT OF WALL, 16" AFF, CONNECT TO TERMINALS, 27" AFF.
- E85- 1058 W, 1/2 HP, 11.5 AMPS, 120V/60/1 PHASE REC'PT., FLUSH W/ WALL, 80" AFF.
- E88- 644 W, 1/3 HP, 8.0 AMPS, 120V/60/1 PHASE REC'PT., FLUSH W/ WALL, 80" AFF.
- E90- 4.5 KW, 30 AMPS (FUSED), 208V/60/1 PHASE REC'PT., FLUSH W/ WALL, 16" AFF.
- E91- 936 W, 7.8 AMPS, 120V/60/1 PHASE REC'PT., FLUSH W/ WALL, 48" AFF.
- E100- 1/3 HP, 120V/60/1 PHASE CONVENIENCE REC'PT., FLUSH W/ WALL, 48" AFF.
- E103- 900 W, 7.5 AMPS, 120V/60/1 PHASE REC'PT., FLUSH W/ WALL, 48" AFF.

- E106- 1/2 HP, 120V/60/1 PHASE REC'PT., 10" AFF.
- E110- 2.0 KW, 17.0 AMPS, 120V/60/1 PHASE SERVICE, STUB-UP AND CONNECT TO TERMINALS, 30" AFF.
- E111- 1/5 HP, 4.0 AMPS, 120V/60/1 PHASE REC'PT., 10" AFF.
- E112- 825 W, 6.9 AMPS, 120V/60/1 PHASE SERVICE, STUB-UP AND CONNECT TO TERMINALS, 30" AFF.
- E116- 4.0 AMPS, 120V/60/1 PHASE REC'PT., FLUSH W/ WALL, 48" AFF.
- E117- 1/4 HP, 7.3 AMPS, 120V/60/1 PHASE REC'PT., FLUSH W/ WALL, 48" AFF.
- E118- 1900 W, 16.0 AMPS, 120V/60/1 PHASE REC'PT., FLUSH W/ WALL, 48" AFF.
- E119- 1.3 AMPS, 120V/60/1 PHASE REC'PT., FLUSH W/ WALL, 48" AFF.
- E120- 1775 W, 120V/60/1 PHASE REC'PT., FLUSH W/ WALL, 48" AFF.
- E123- 100 W, 120V/60/1 PHASE REC'PT., FLUSH W/ WALL, 24" AFF.
- E123b- 100 W, 120V/60/1 PHASE REC'PT., 10" AFF.
- E135- 3 HP, 3.7 AMPS, 480V/60/3 PHASE SERVICE, STUB-UP, EXTEND THRU CONTROL PANEL AND SOLENOID VALVE AND CONNECT TO TERMINALS ON DISPOSER.
- E136- 50.0 KW, 6-1/2 HP, 480V/60/3 PHASE SERVICE FROM CEILING, CONNECT TO TERMINALS, 66" AFF.
- E136b- 40.0 KW, 480V/60/3 PHASE SERVICE, STUB-UP AND CONNECT TO TERMINALS, 6" AFF.

K402 1/4"=1'-0"

<p>Click/Booth, Inc. (U.S.) 247 Main Street, Charleston, S.C. 29403 803-737-6377</p>	
<p>APPROVED BY (NEW MEMBER) _____ MEMBER NO. _____ DATE _____</p>	<p>REVISIONS No. Description Date 1 AS-BUILT DIVS. NO CONNECTIONS 1/17/24 2</p>
<p>CHARLESTON AIR FORCE BASE DINING FACILITY PARTIAL ELECTRICAL CONNECTION PLAN</p>	<p>CHARLESTON, SOUTH CAROLINA DATE: 5/16/24 APP'D FOR COMMANDER, WING: _____</p>
<p>Naval Facilities Engineering Command Southern Division Charleston, South Carolina</p>	<p>RECORD DRAWING DATE: 7/27/24 CODE I.D. NO.: 90991 DRAWING SIZE: D SPEC. NO. 06-93-0939 CONSTR. CONTR. NO.: NS2467-95-C-0939 NAVFAC DRAWING NO.: 5357934 SHEET 109 OF 194</p>