


1 HOOD SECTION ITEM # 84  
K103/K503 NO SCALE

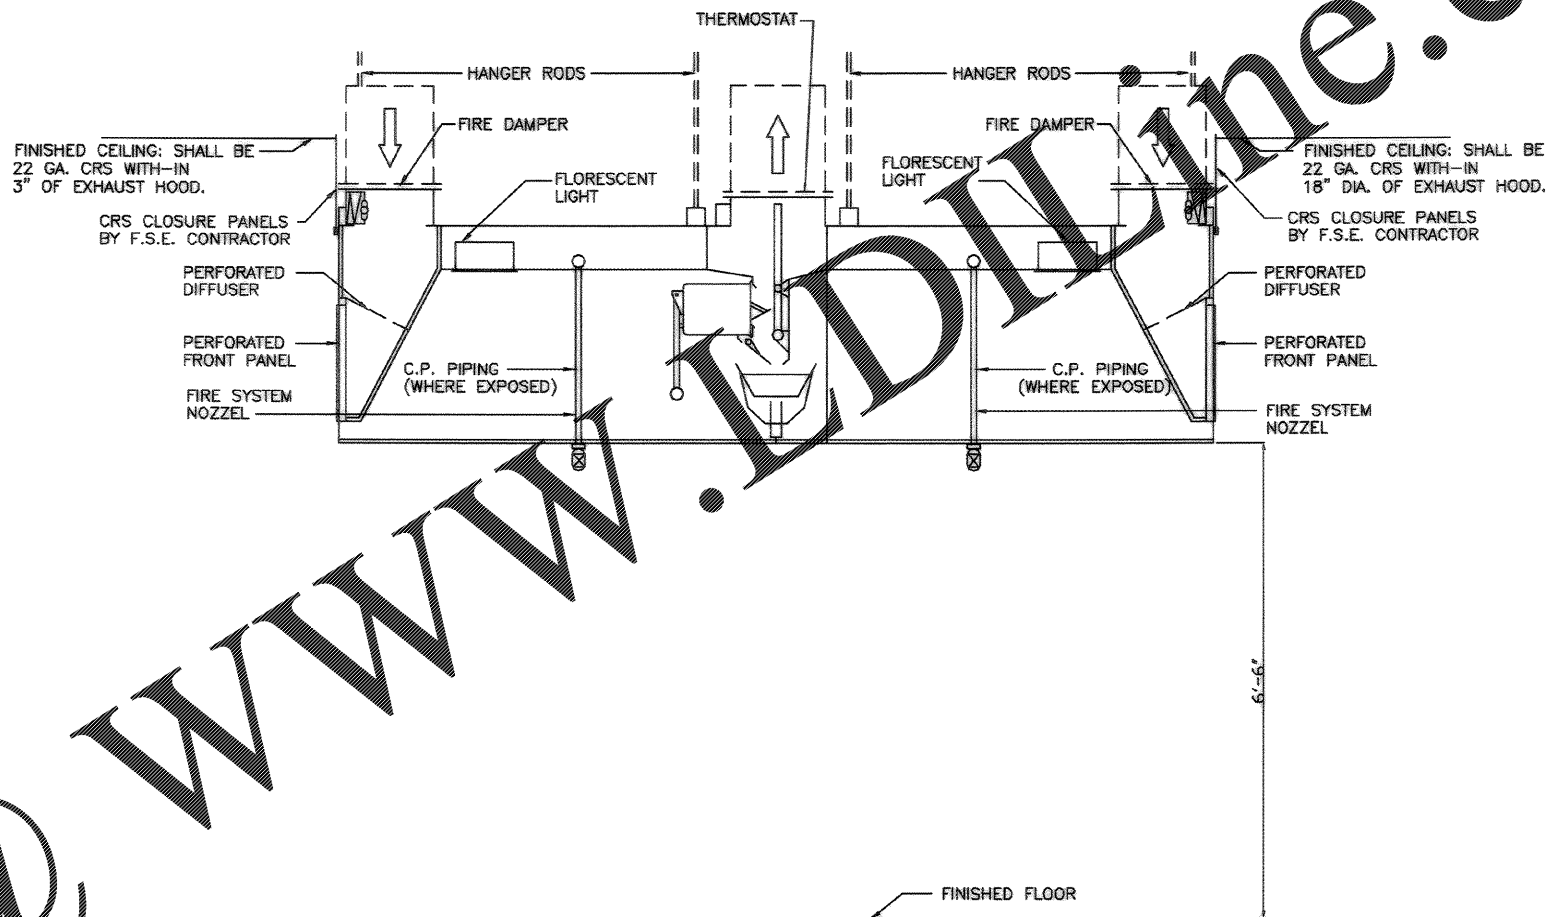

2 HOOD SECTION ITEM # 28  
K102/K503 NO SCALE

Order Plans

@

WWW.IDLINE.COM

RECORD DRAWING DATE 9/27/84	
CODE I.D. NO. 80091	
DRAWING SIZE: 11	
SPEC. NO. 08-98-0939	
CONSTR. CONTR. NO. 182467-93-C-0939	
NAVFAC DRAWING NO. 5357937	
SHEET 112 OF 194	
K503	
Naval Facilities Engineering Command Southern Division Charleston, South Carolina	
CHARLESTON AIR FORCE BASE CHARLESTON, SOUTH CAROLINA DINING FACILITY VENTILATION DETAILS	
Rev. 1 11-28-84 (DATE)	Description 11-28-84 (DATE)
Prep By J.M.H.	Date 11/28/84
CHECKED BY (SEE COMMENTS) [Signature] TYPED BY [Signature]	
DESIGNED BY (SEE COMMENTS) [Signature]	
DRAWING REVISIONS	
(C) 1984 by Lockheed Martin Corp. All rights reserved.	