


Order Plans @ [www.orderplans.com](http://www.orderplans.com)

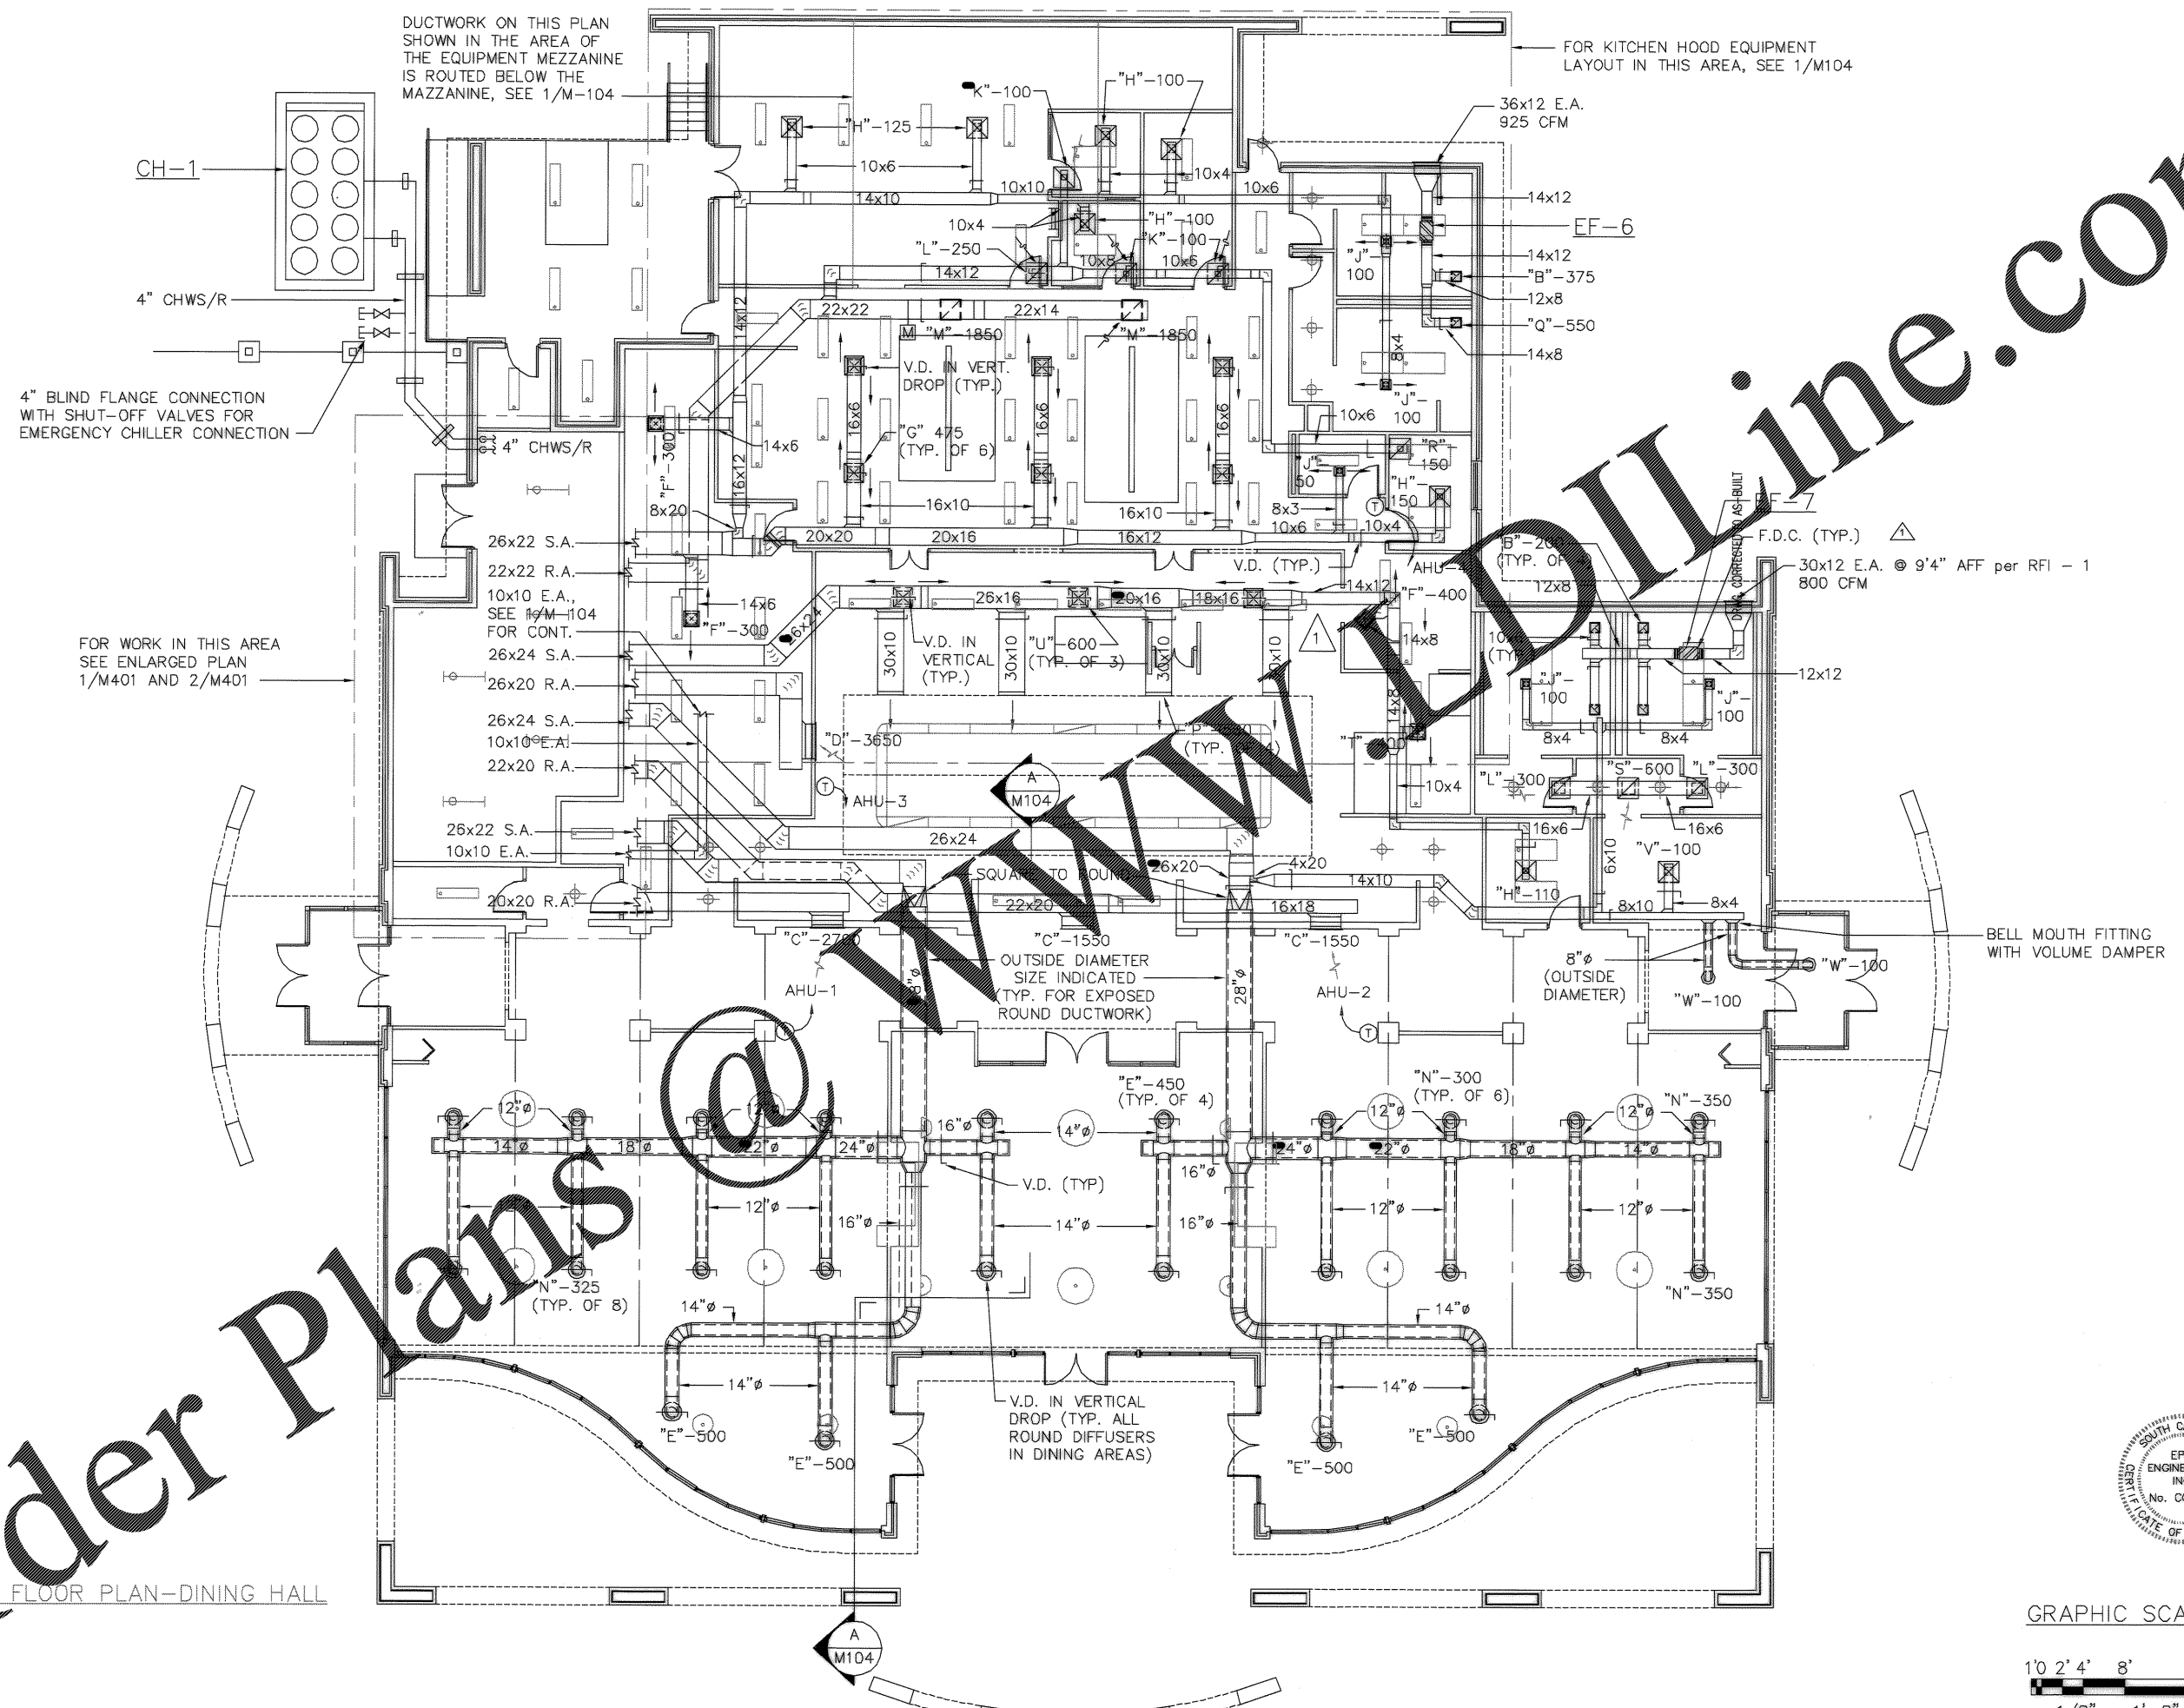

DRAWING REVISIONS		Prep By: <b>AWH</b>	Date: <b>5/1/04</b>	Apprv: <b>AWH</b>	Proj: <b>100</b>	Sheet: <b>103</b>	Scale: <b>1/8" = 1'-0"</b>
Description		As-Built		Sennati, S. C. 29401		Sennati, S. C. 29401	
Rev.		1		Sennati, S. C. 29401		Sennati, S. C. 29401	
CHARLESTON AIR FORCE BASE		CHARLESTON, SOUTH CAROLINA		DINING FACILITY		MECHANICAL FLOOR PLAN	
Naval Facilities Engineering Command		Southern Division		Charleston, South Carolina		APPROVED	
EPIC ENGINEERING INC.		No. 7188		No. C00259		No. 7188	
RECORD DRAWING DATE		9/27/04		CODE LD. NO. 80091		DRAWING SIZE: D	
SPEC. NO. 06-98-0939		CONSTR. CONTR. NO. N62467-98-C-0939		NAVFAC DRAWING NO. 5357961		SHEET 136 OF 194	
M-103		468-59					

