



Order Plans

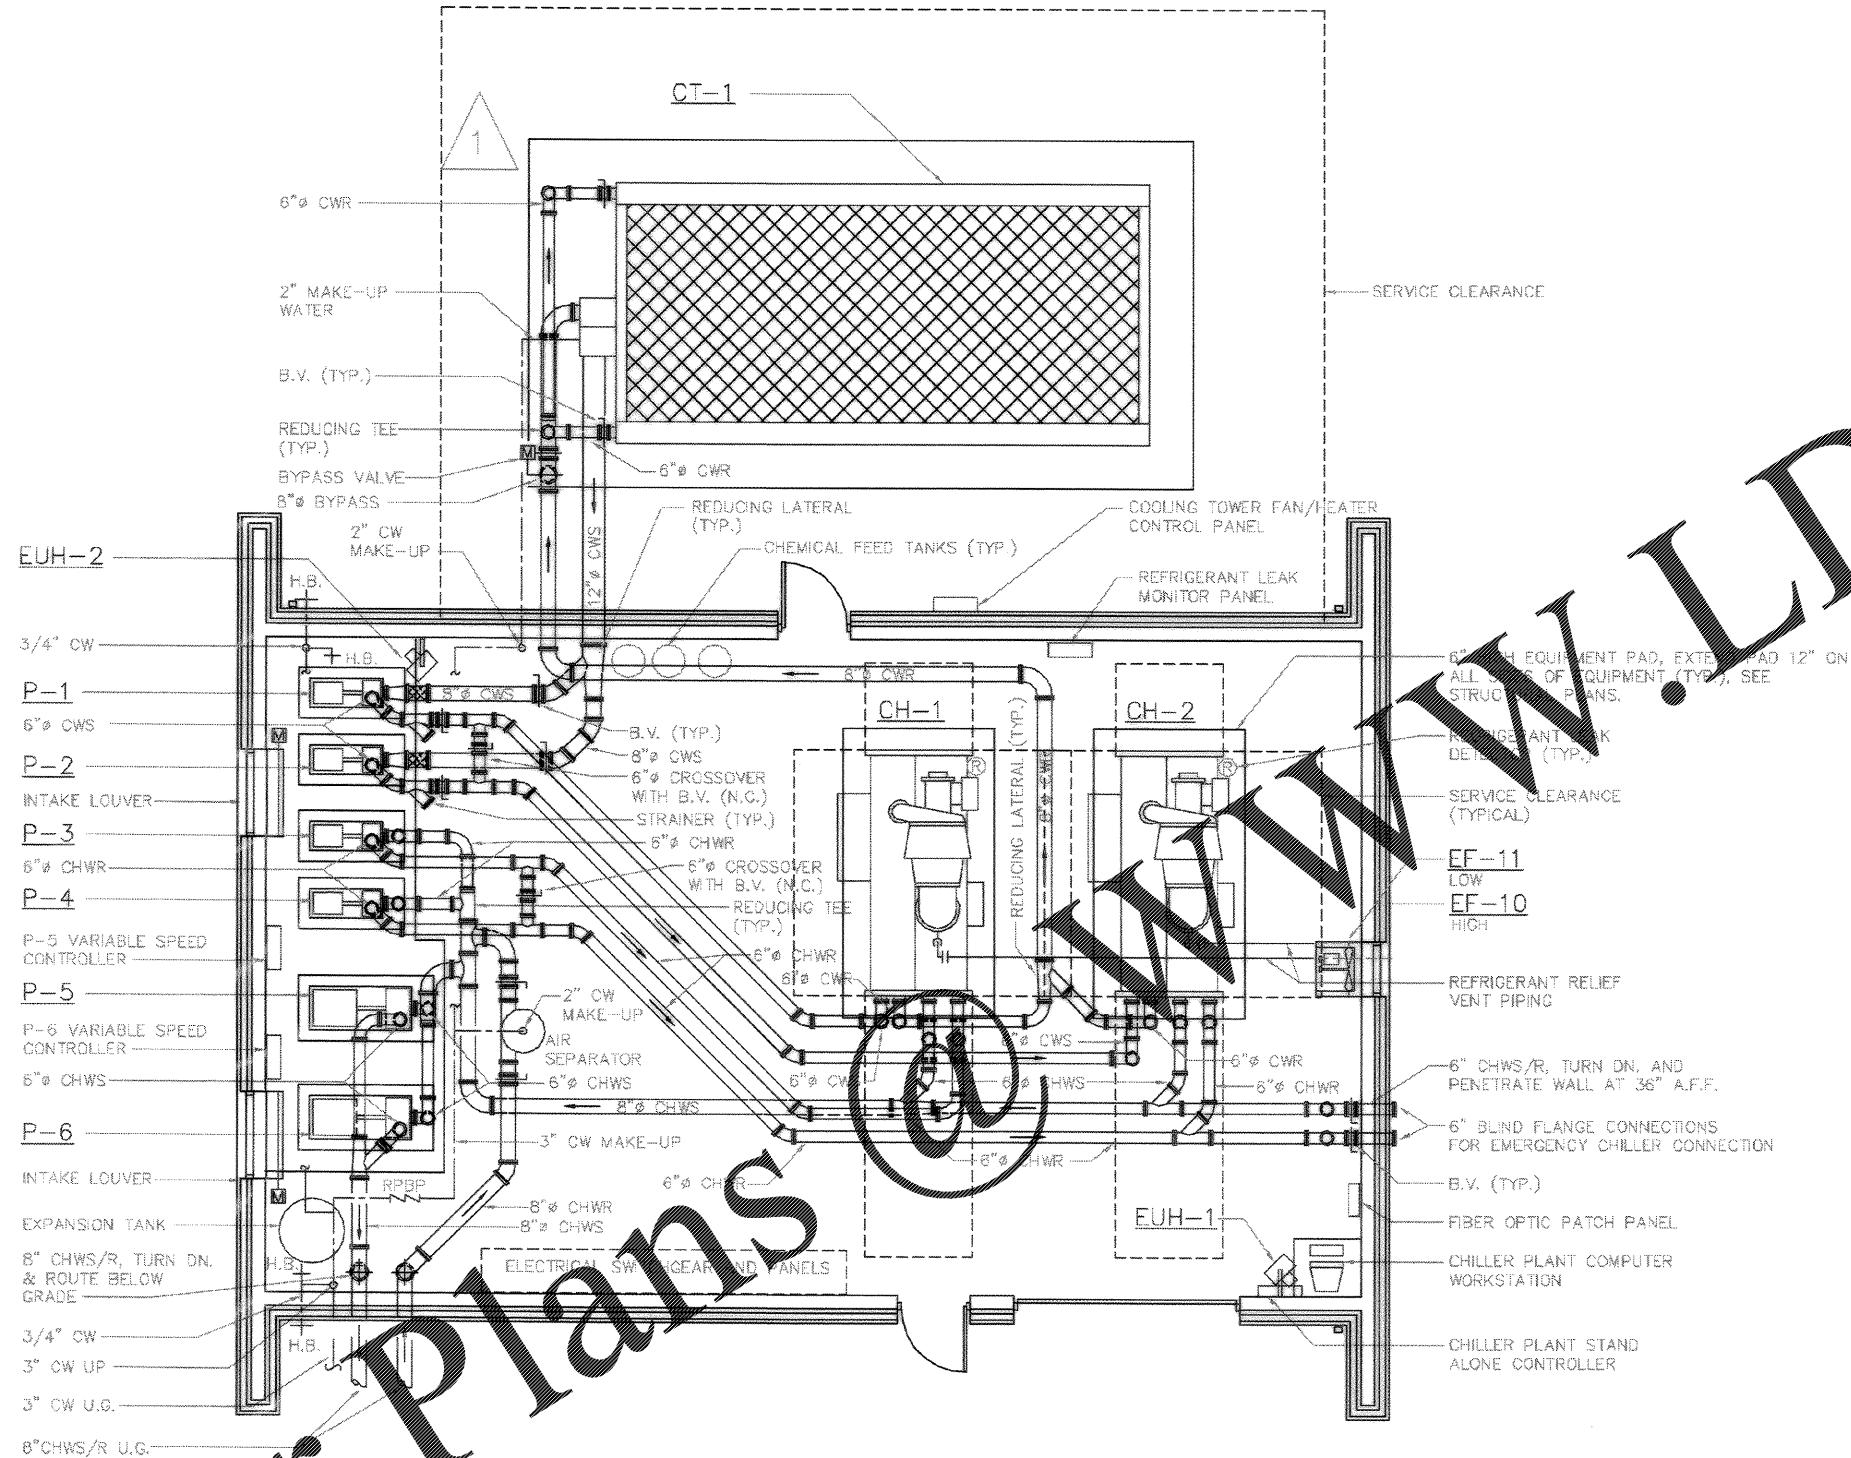

1  
M105 CHILLER PLANT MECHANICAL PLAN  
SCALE: 1/4" = 1'-0"

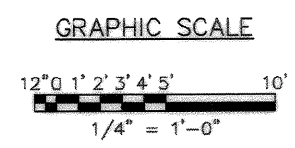

Glick/Boehm, Inc. 247 Meeting Street, Charleston, S.C. 29403-6377 (803) 777-6377 FAX (803) 777-6377 WWW.GBLICKBOEHM.COM	
DRAWING REVISIONS Description 1 CHWS CORRECTED TO AS-BUILT	Prep By Date 4/11/04 Rev. 1
CHARLESTON AIR FORCE BASE CHARLESTON, SOUTH CAROLINA DINED FACILITY CHILLER PLANT MECHANICAL PLAN - CPRO APPROVED: <i>[Signature]</i> DATE: 4/11/04 EPD FOR COMMANDER, USMC	
Naval Facilities Engineering Command Southern Division Charleston, South Carolina	
SOUTH CAROLINA PROFESSIONAL ENGINEERING BOARD EPIC ENGINEERING INC. No. 090259 STATE OF SOUTH CAROLINA	
RECORD DRAWING DATE: 9/2/04 CODE CL NO.: 60081 DRAWING SIZE: 31 SPEC. NO. 06-88-0938 CONSTR. CONTR. NO. N62467-98-C-0039 NAVFAC DRAWING NO. 5357963 SHEET 138 OF 194 M-105	