



Order Plans

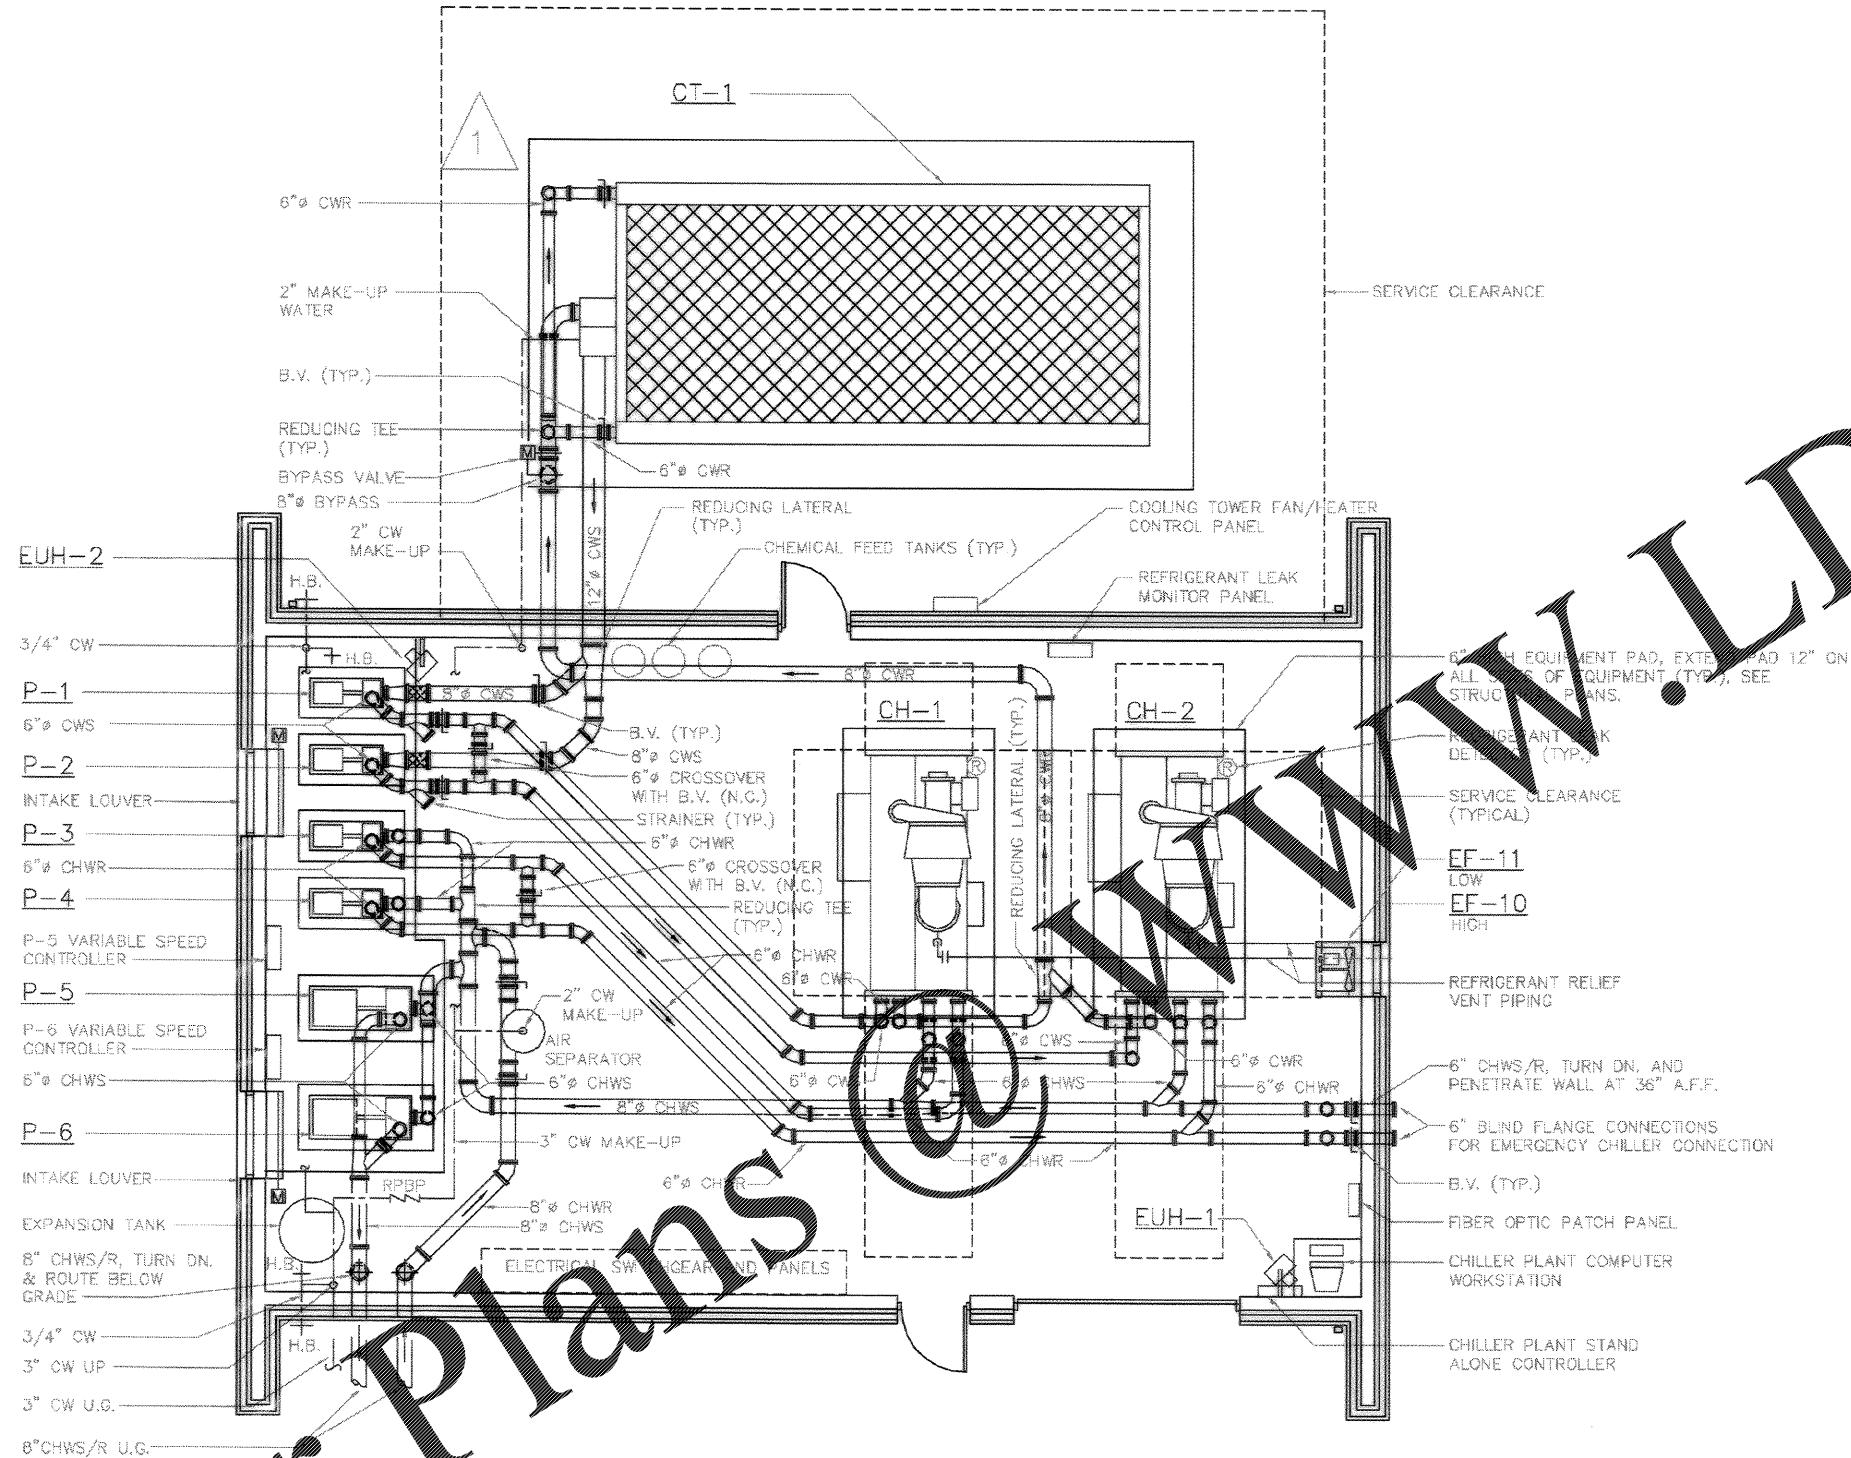

1
M105 CHILLER PLANT MECHANICAL PLAN
SCALE: 1/4" = 1'-0"

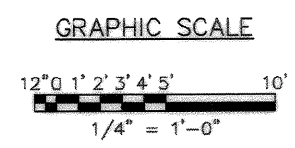

Glick/Boehm, Inc. 247 Meeting Street, Charleston, S.C. 29403 (803) 777-6377 FAX: (803) 777-6378 E-MAIL: SALES@GLICKBOEHM.COM WWW.GLICKBOEHM.COM	
DRAWING REVISIONS Description: CHWGS CORRECTED TO AS-BUILT Rev. 1 Date: 6/11/04 Prep By: ALM Check By: JMM Drawn By: JMM Scale: 1/4" = 1'-0" Title: CHILLER PLANT MECHANICAL PLAN - CPRO	APPROVED: [Signature] EPD FOR COMMANDER, USNCGC
CHARLESTON AIR FORCE BASE CHARLESTON, SOUTH CAROLINA DINA FACILITY CHILLER PLANT MECHANICAL PLAN - CPRO	APPROVED: [Signature] EPD FOR COMMANDER, USNCGC
Naval Facilities Engineering Command Southern Division Charleston, South Carolina	APPROVED: [Signature] EPD FOR COMMANDER, USNCGC
RECORD DRAWING DATE: 6/2/04 CODE CL NO.: 60081 DRAWING SIZE: 31 SPEC. NO. 06-88-0938 CONSTR. CONTR. NO. N62467-98-C-0039 NAVFAC DRAWING NO. 5357963 SHEET 138 OF 194	M-105