


1  
M108  
MECHANICAL ATTIC PLAN - BUILDING 475  
SCALE: NONE

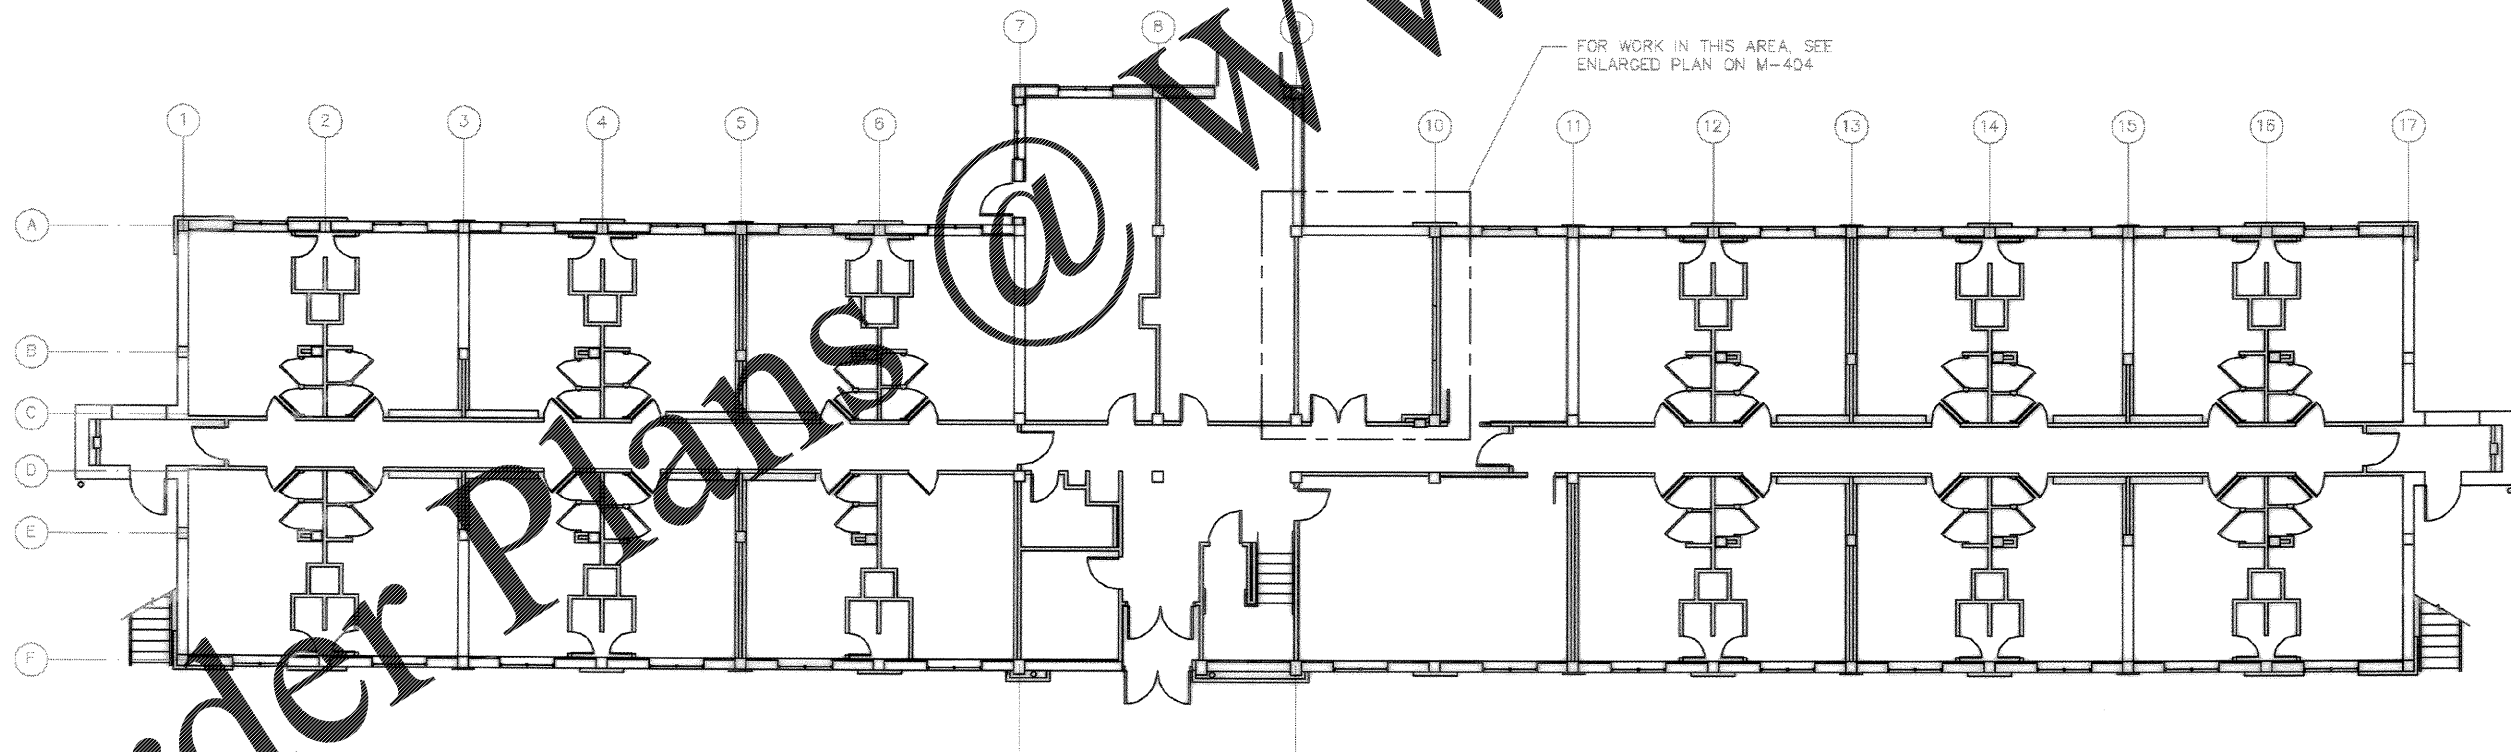

1  
M108  
MECHANICAL FIRST FLOOR PLAN - BUILDING 475  
SCALE: NONE

DRAWING REVISIONS Description No. AS-BUILT DIVS. NO CORRECTIONS Rev. 1		Prep By Date Drawn By Date Checked By Date In Charge Date	Title Scale Author Date
CHARLESTON AIR FORCE BASE DINING FACILITY DORM 475 MECHANICAL PLANS - CPRO DATE: 5/14/04 APPROVED: [Signature]		CHARLESTON, SOUTH CAROLINA EPIC ENGINEERING INC. No. 2188 No. 030289 STATE OF SOUTH CAROLINA PROFESSIONAL ENGINEER	
Naval Facilities Engineering Command Southern Division Charleston, South Carolina		RECORD DRAWING DATE 7/27/04 CODE ID NO. 8091 DRAWING SIZE SPEC. NO. 06-88-0938 CONSTR. CONTR. NO. NS2487-88-C-0938 NAVFAC DRAWING NO. 5357966 SHEET 141 OF 194 M-108	

Order Plans @ WWW.LDILine.com