




Order Plans

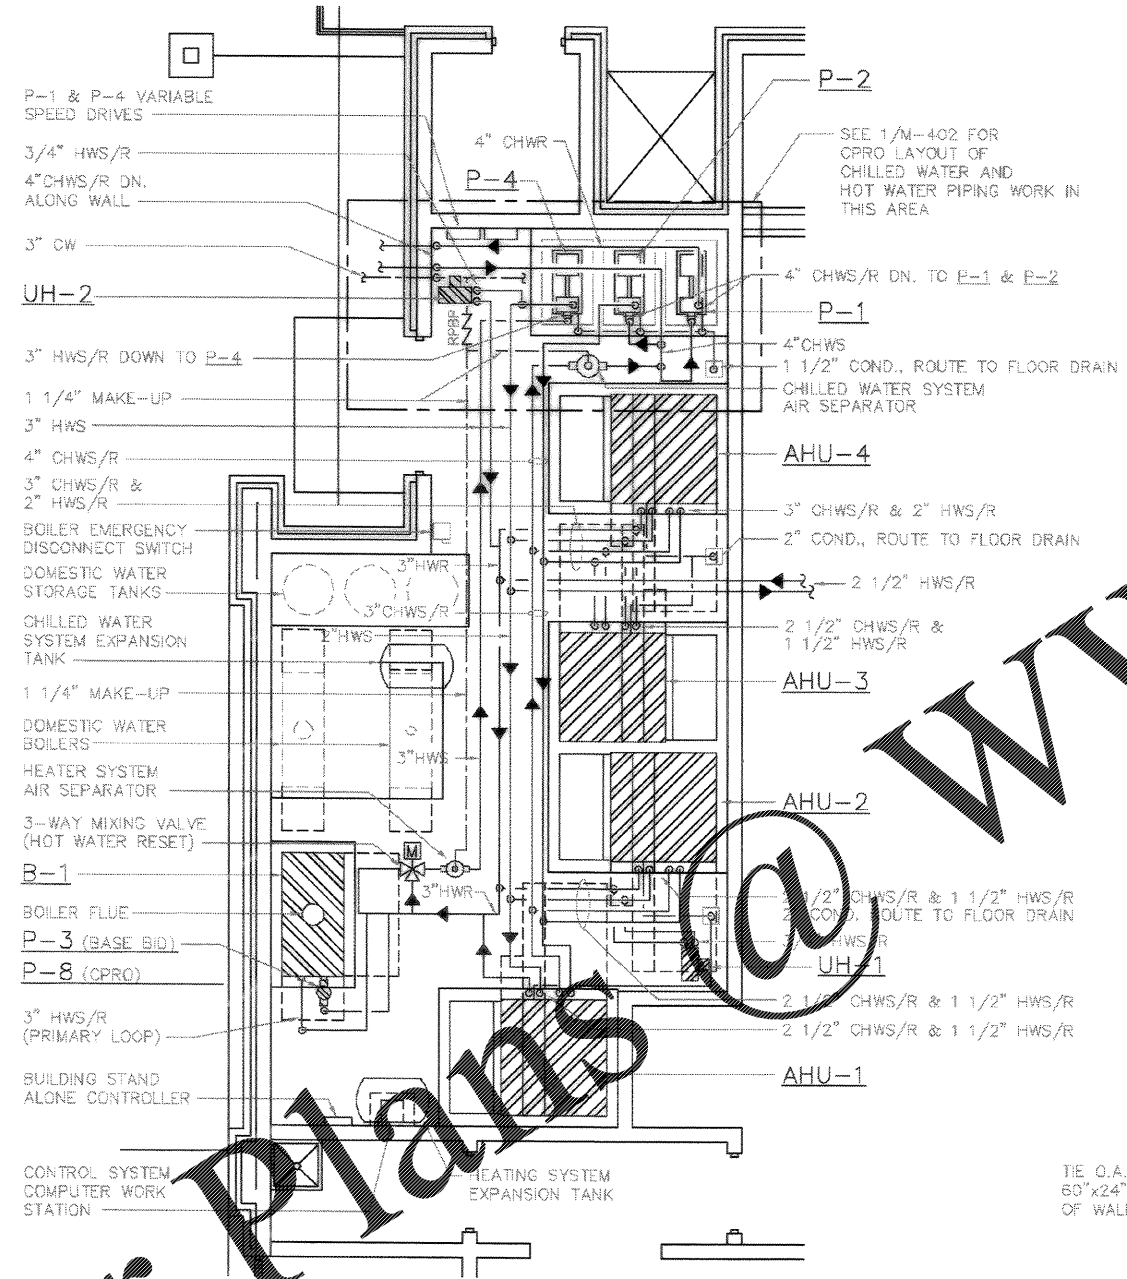

1 ENLARGED MECHANICAL ROOM PIPING PLAN
SCALE: 1/4" = 1'-0"

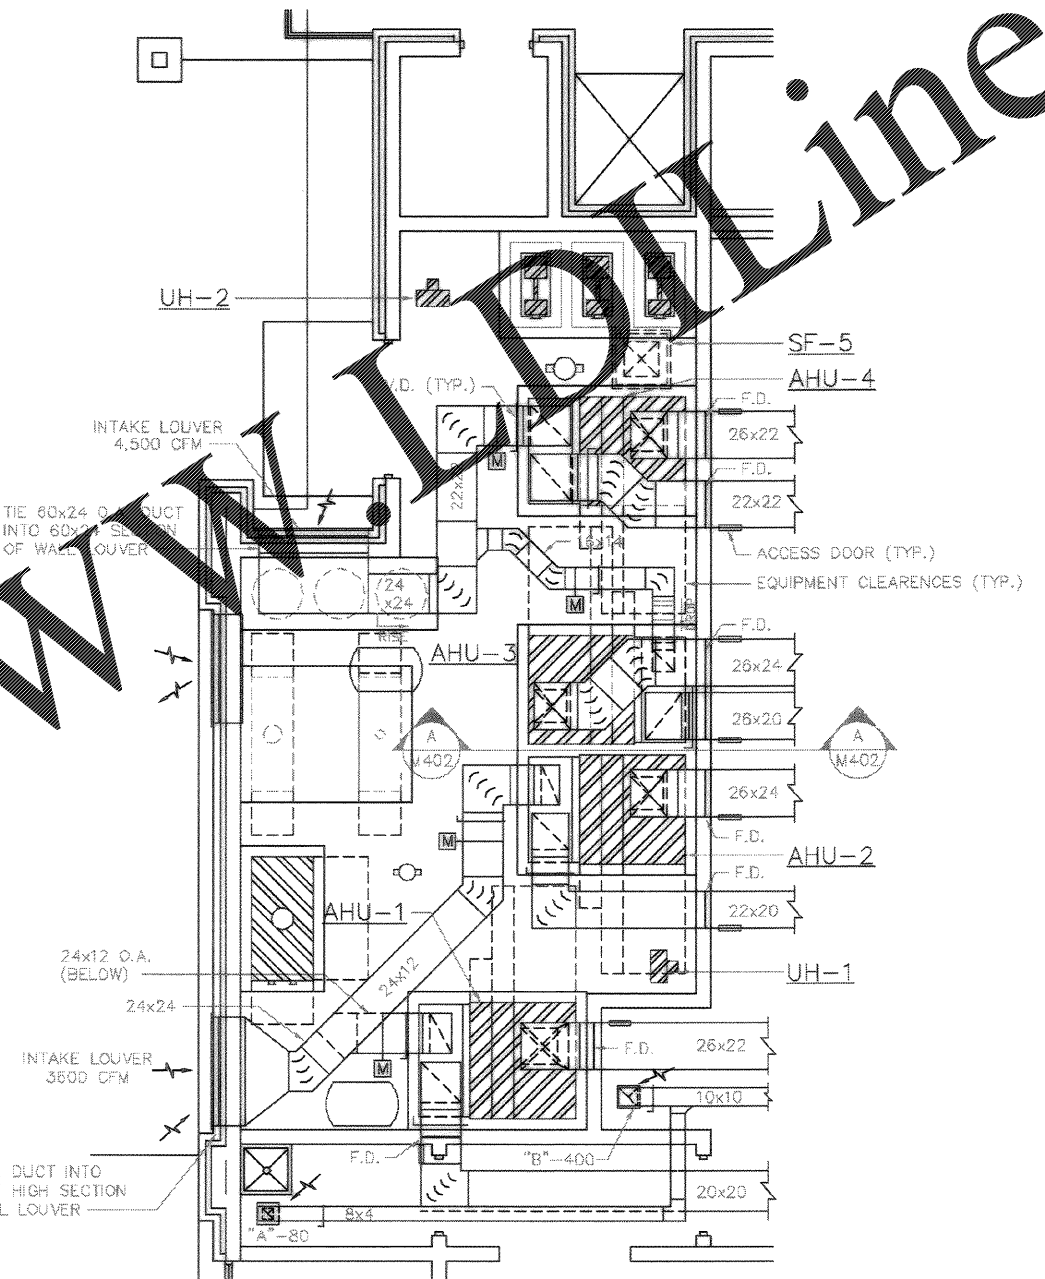

2 ENLARGED MECHANICAL ROOM DUCTWORK PLAN
SCALE: 1/4" = 1'-0"

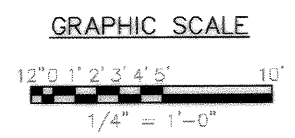

Naval Facilities Engineering Command
Southern Division
Charleston, South Carolina

CHARLESTON AIR FORCE BASE CHARLESTON, SOUTH CAROLINA
DINING FACILITY
ENLARGED MECHANICAL PLANS

Rev.	Description	Date	By	App'd.
1	As-shown with no connections	11/14/04	MM	MM

RECORD DRAWING DATE: 9/27/04
 CODE: 110, NO. 80881
 DRAWING SIZE: D
 SPEC. NO. 06-88-0838
 CONSTR. CONTR. NO. NE2467-98-C-0939
 NAWFAC DRAWING NO. 5357966
 SHEET 143 OF 194
 M-401