




Order Plans

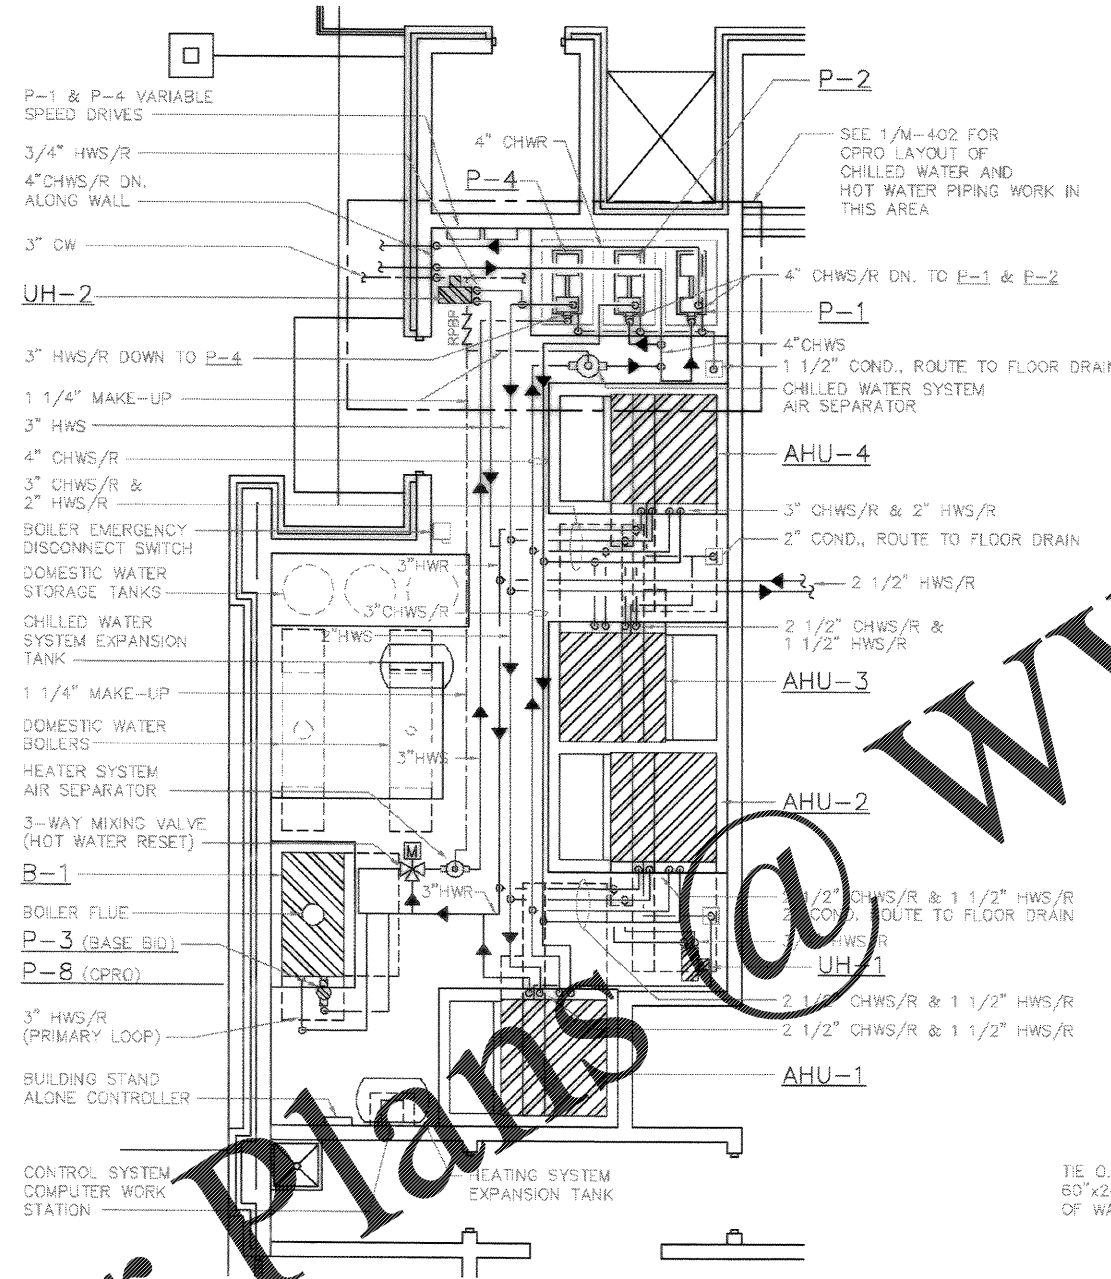

1 ENLARGED MECHANICAL ROOM PIPING PLAN  
SCALE: 1/4" = 1'-0"

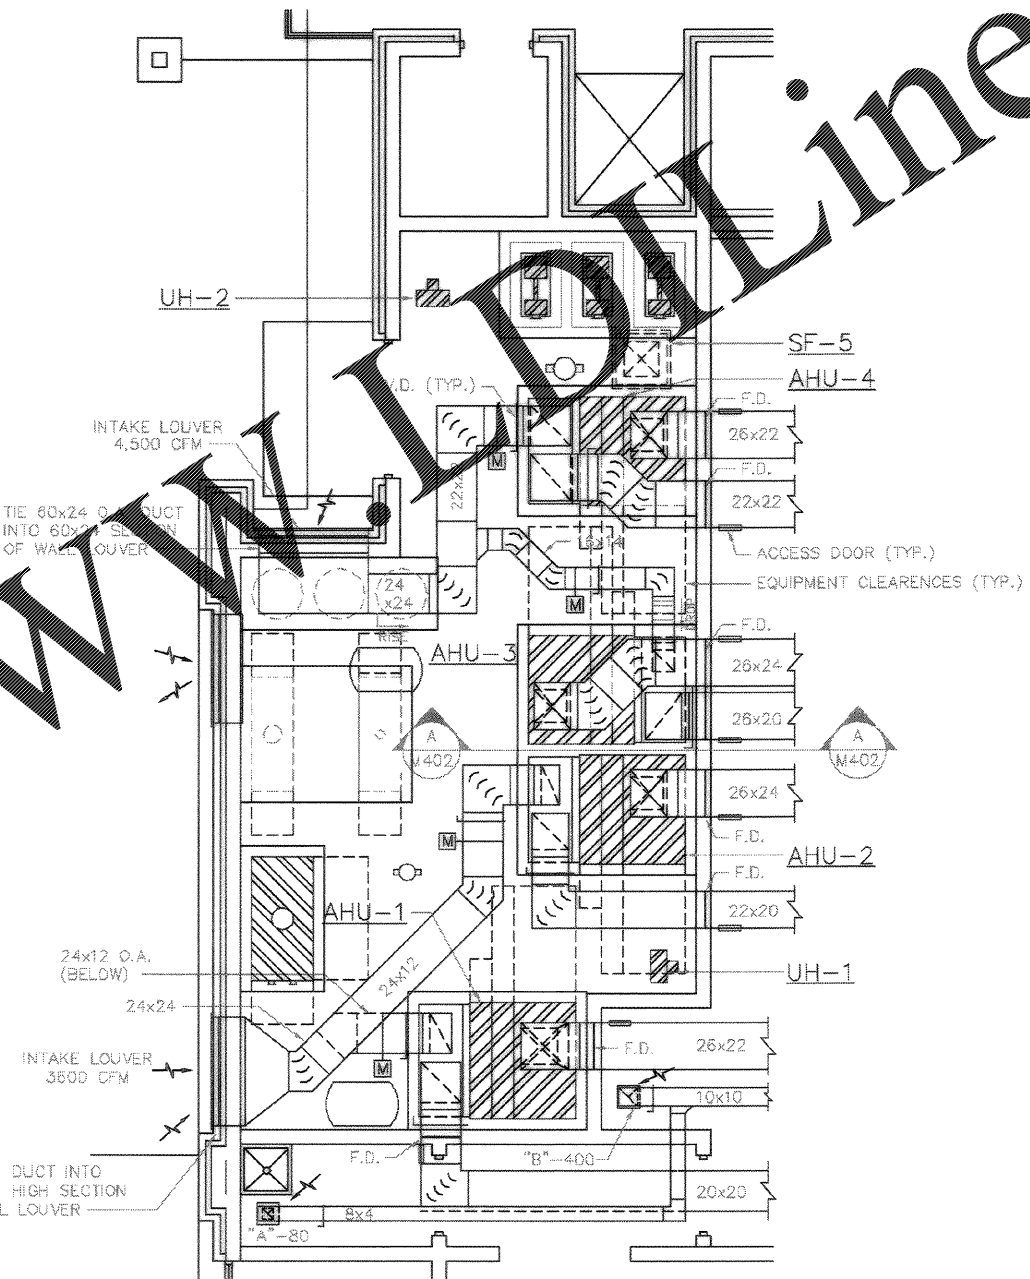

2 ENLARGED MECHANICAL ROOM DUCTWORK PLAN  
SCALE: 1/4" = 1'-0"

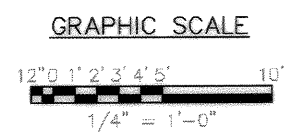

Naval Facilities Engineering Command  
Southern Division  
Charleston, South Carolina

CHARLESTON AIR FORCE BASE CHARLESTON, SOUTH CAROLINA  
DINING FACILITY  
ENLARGED MECHANICAL PLANS

Rev.	Description	Date	By	App'd
1	As-shown with no connections	11/14/01	MM	MM

RECORD DRAWING DATE: 9/27/04  
 CODE: J.D. NO. 80081  
 DRAWING SIZE: D  
 SPEC. NO. 06-08-0838  
 CONSTR. CONTR. NO. NE2467-98-C-0939  
 NAWFAC DRAWING NO. 5357968  
 SHEET 143 OF 194  
 M-401