




1 AHU-4 CONTROL DIAGRAM  
SCALE: NONE

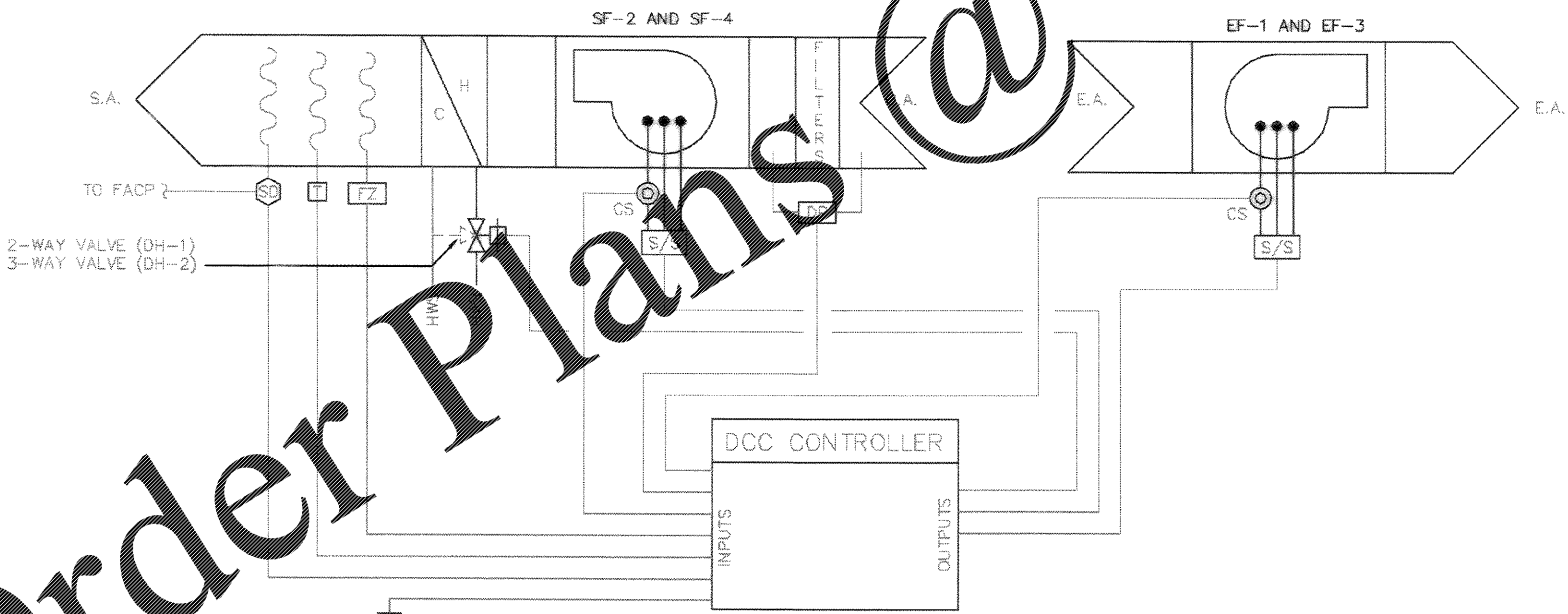


2 KITCHEN HOOD(S) CONTROL DIAGRAM (TYP. OF 2)  
SCALE: NONE

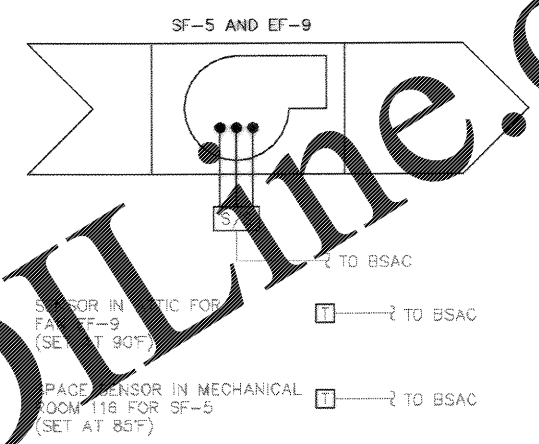


3 VENTILATION FAN(S) CONTROL DIAGRAM  
SCALE: NONE

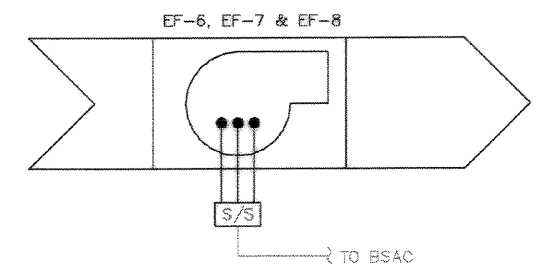

4 EXHAUST FAN(S) CONTROL DIAGRAM  
SCALE: NONE

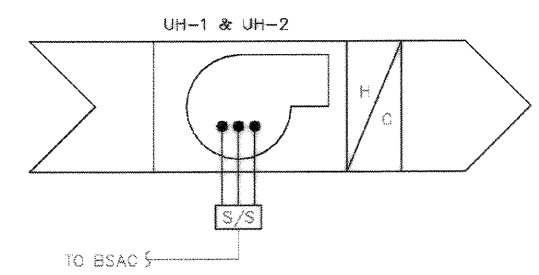

5 UNIT HEATER CONTROL DIAGRAM  
SCALE: NONE

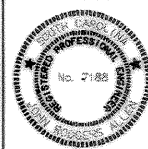City/Region & Address Charleston, S.C. 29405 (803) 777-6377 FAX (803) 777-6377 E-MAIL: SALES@EPIC-ENGINEERING.COM WWW.EPIC-ENGINEERING.COM	
DRAWING REVISIONS Description No. 1 AS-BUILT INFO. NO CORRECTIONS	Prep By Date Approved 12/15/04 12/15/04
CHARLESTON AIR FORCE BASE DINING FACILITY CONTROL DIAGRAMS	
APPROVED: <i>[Signature]</i> DATE: 12/15/04 EPIC FOR COMMANDER, IAW/20	
Naval Facilities Engineering Command Southern Division Charleston, South Carolina	
	
RECORD DRAWING DATE 9/27/04	
CODE: LB, NO. BOUNTY DRAWING SIZE: 36-36-0338 SPEC. NO. 36-36-0338 CONSTR. CENTER NO. NB2467-99-C-0938 NAVFAC DRAWING NO. 5357385	
SHEET 100 OF 194 M-605	

Order Plans @ [www.LDLine.com](http://www.LDLine.com)