


1 DORMITORY'S 464, 465 AND 473 CONTROL DIAGRAM (TYP. EACH BLDG.)
 SCALE: NONE

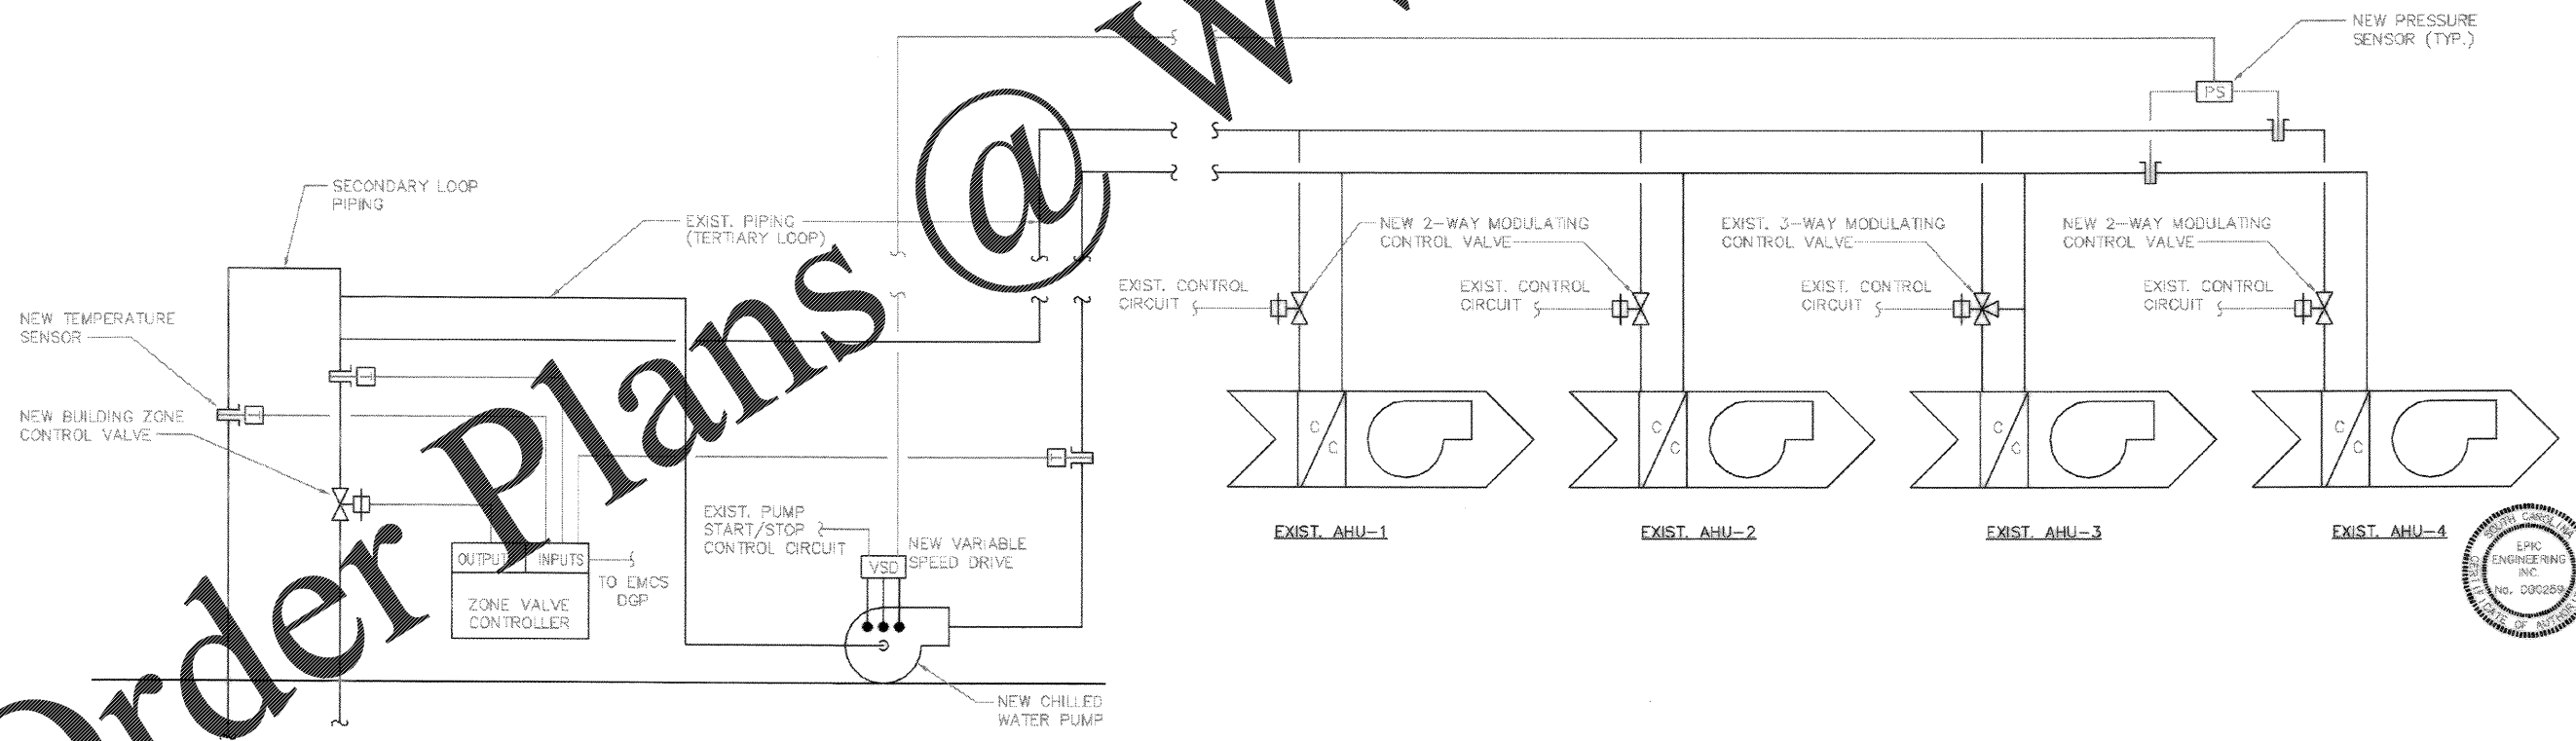

2 DORMITORY 475 CONTROL DIAGRAM
 SCALE: NONE

Click/Boehm & Associates, Inc. 217 Meeting Street Charleston, S.C. 29401 7-6377	DATE	BY	CHKD	APP'D
DESIGNED BY: BOYD WALKER	DATE: 11/11/04	BY: BOYD WALKER	CHKD: BOYD WALKER	APP'D: BOYD WALKER
DRAWN BY: BOYD WALKER	DATE: 11/11/04	BY: BOYD WALKER	CHKD: BOYD WALKER	APP'D: BOYD WALKER
CHECKED BY: BOYD WALKER	DATE: 11/11/04	BY: BOYD WALKER	CHKD: BOYD WALKER	APP'D: BOYD WALKER
REVISIONS	DATE	BY	DESCRIPTION	DATE
1	11/11/04	BOYD WALKER	AS-BUILT INFO. NO CONNECTIONS	

CHARLESTON AIR FORCE BASE	CHARLESTON, SOUTH CAROLINA
DINING FACILITY	CONTROL DIAGRAMS - CPRO
APPROVED: BOYD WALKER, PE	DATE: 11/11/04
EDD FOR COMMANDER, WAFAC	

Naval Facilities Engineering Command	Southern Division	Charleston, South Carolina

RECORD DRAWING DATE	9/27/04
CODE LIB. NO.	800871
DRAWING SIZE	D
SPEC. NO.	06-88-0938
CONSTR. CONF. NO.	NO2467-88-C-0938
NAVFAC DRAWING NO.	53579B9
SHEET 164 OF 184	

M-609

Order Plans @ www.LDOnline.com