


1 DORMITORY'S 464, 465 AND 473 CONTROL DIAGRAM (TYP. EACH BLDG.)
SCALE: NONE

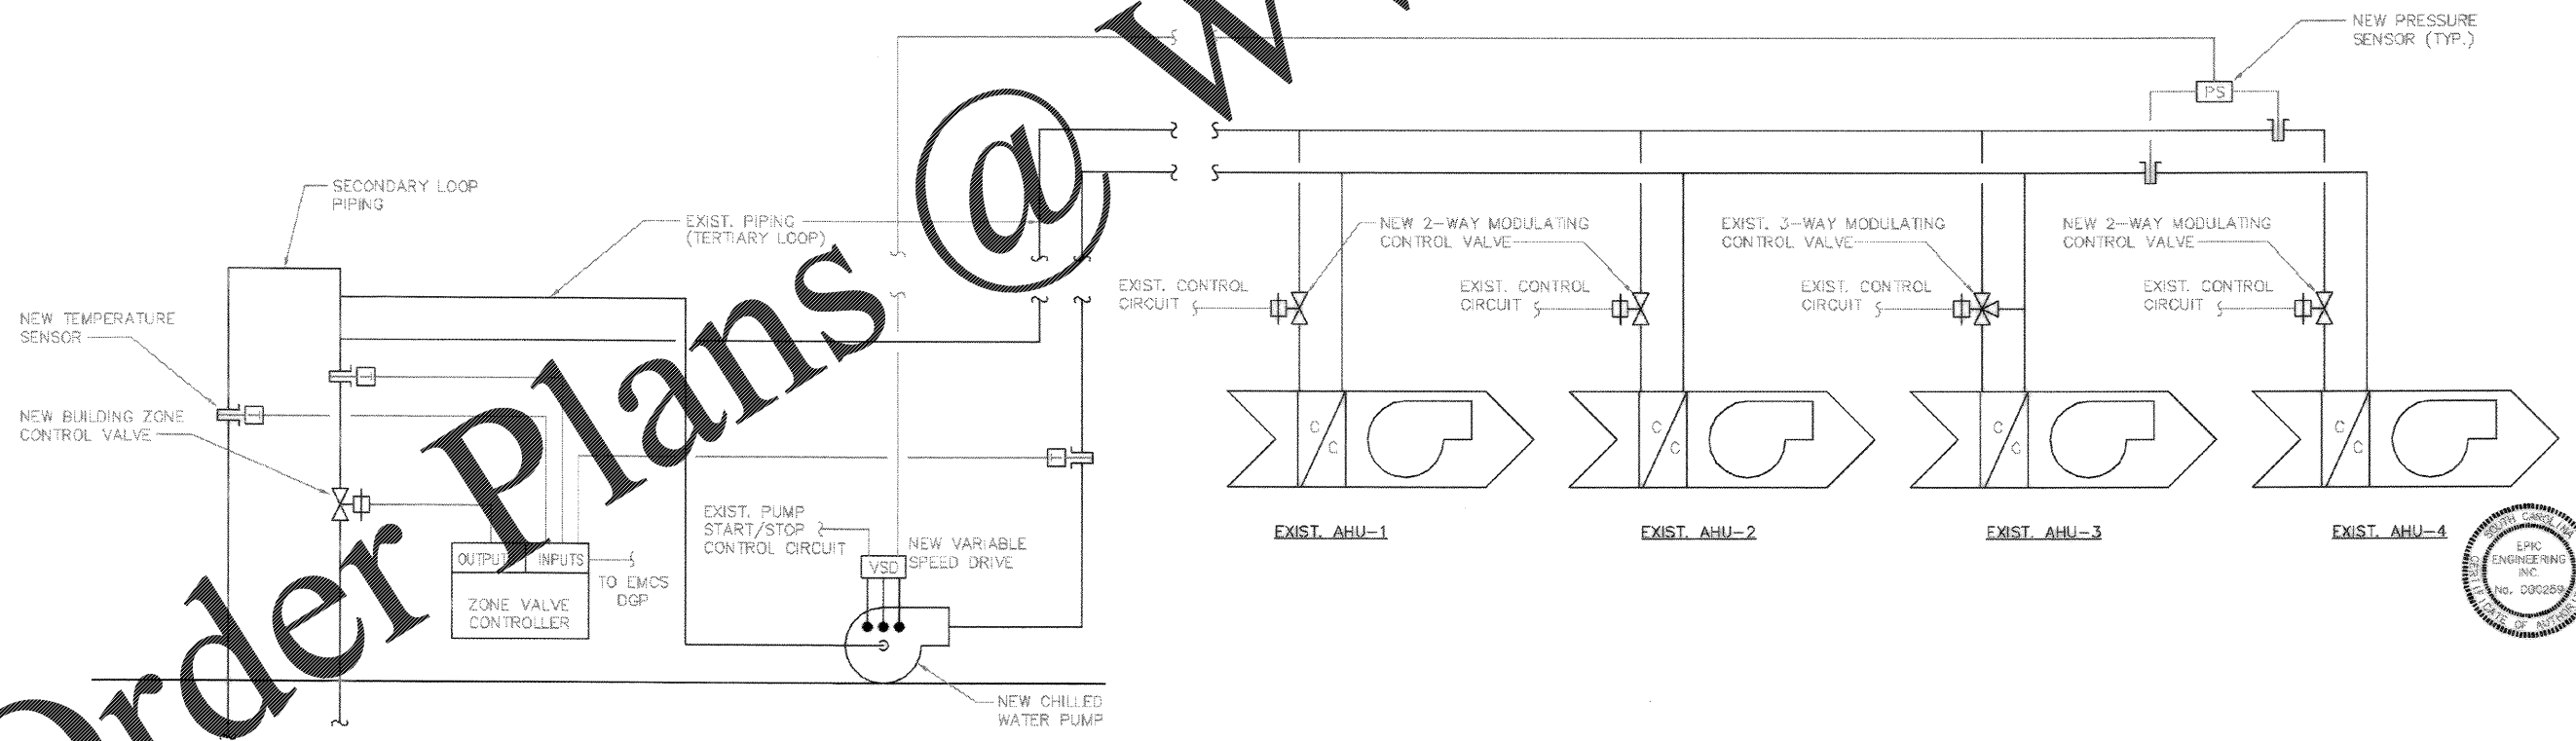


2 DORMITORY 475 CONTROL DIAGRAM
SCALE: NONE

Click/Boehm & Associates, Inc. 217 Meeting Street Charleston, S.C. 29401 7-6377	DATE	BY	CHKD	APP'D
DESIGN	09/27/04	LD	LD	LD
REVISIONS	DATE	BY	CHKD	APP'D
1	09/27/04	LD	LD	LD
DESCRIPTION: 1. AS-BUILT INVC. NO CORRECTIONS				

CHARLESTON AIR FORCE BASE	CHARLESTON, SOUTH CAROLINA
DINING FACILITY	CONTROL DIAGRAMS - CPRO
APPROVED: <i>[Signature]</i>	DATE: 09/27/04

Naval Facilities Engineering Command Southern Division Charleston, South Carolina	EPIC ENGINEERING INC. No. 000289 STATE OF ALABAMA
---	---

RECORD DRAWING DATE	9/27/04
CODE LIB. NO.	800871
DRAWING SIZE	D
SPEC. NO.	06-88-0938
CONSTR. CONF. NO.	NO2467-88-C-0938
NAVFAC DRAWING NO.	5357989
SHEET 164 OF 184	

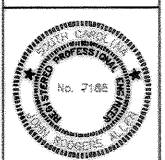

M-609

Order Plans @ www.LDOnline.com