

ISSUANCE

DATE	NO.	DESCRIPTION
XX/XX/XXXX	-	-


PLUMBING LEGEND

- COLD WATER STUB
- COLD WATER STUB (FROM FILTER)
- COLD WATER STUB (IN-LINE FILTER)
- HOT WATER STUB
- HOT WATER STUB (180°)
- CHILLED WATER SUPPLY
- CHILLED WATER RETURN
- WS — WATER LINE (FROM SOURCE TO EQUIPMENT)
- DW — DIRECT WASTE
- ID — INDIRECT DRAIN LINE TO FLOOR SINK
- GS — GAS STUB (NATURAL GAS SUPPLY)
- ⊗ MANUAL GAS SHUT-OFF VALVE
- ⊗ AUTOMATIC GAS SHUT-OFF VALVE
- STEAM SUPPLY
- STEAM RETURN
- FLOOR SINK
- FLOOR SINK (WITH 1/2" RATE)
- FLOOR SINK (WITH SLOPE PER CODE)
- SINK IN FLOOR
- ITEM NUMBER (SEE EQUIPMENT SCHEDULE)
- DOWN FROM ABOVE

NOTE: FLOORS TO PITCH TO FLOOR DRAIN AT 1:50 !!

PLUMBING KEY NOTES

- 1 ALL FLOOR SINKS TO BE FLUSH WITH FINISHED FLOOR
- 2 WATER SUPPLY FOR ICE MACHINE TO BE INTERCONNECTED FROM FILTER.
- 3 G.C. / P.C. TO RE-USE EXISTING WATER IN THIS LOCATION AND RE-WORK ROUGH-INS AS REQUIRED TO ACCOMMODATE THE NEW FOODSERVICE EQUIPMENT AS SHOWN ON THE FOODSERVICE.
- 4 G.C. / P.C. TO SUPPLY NEW PLUMBING ROUGH-INS AND/OR FLOOR SINK(S) AS SHOWN ON THE FOODSERVICE DRAWINGS.

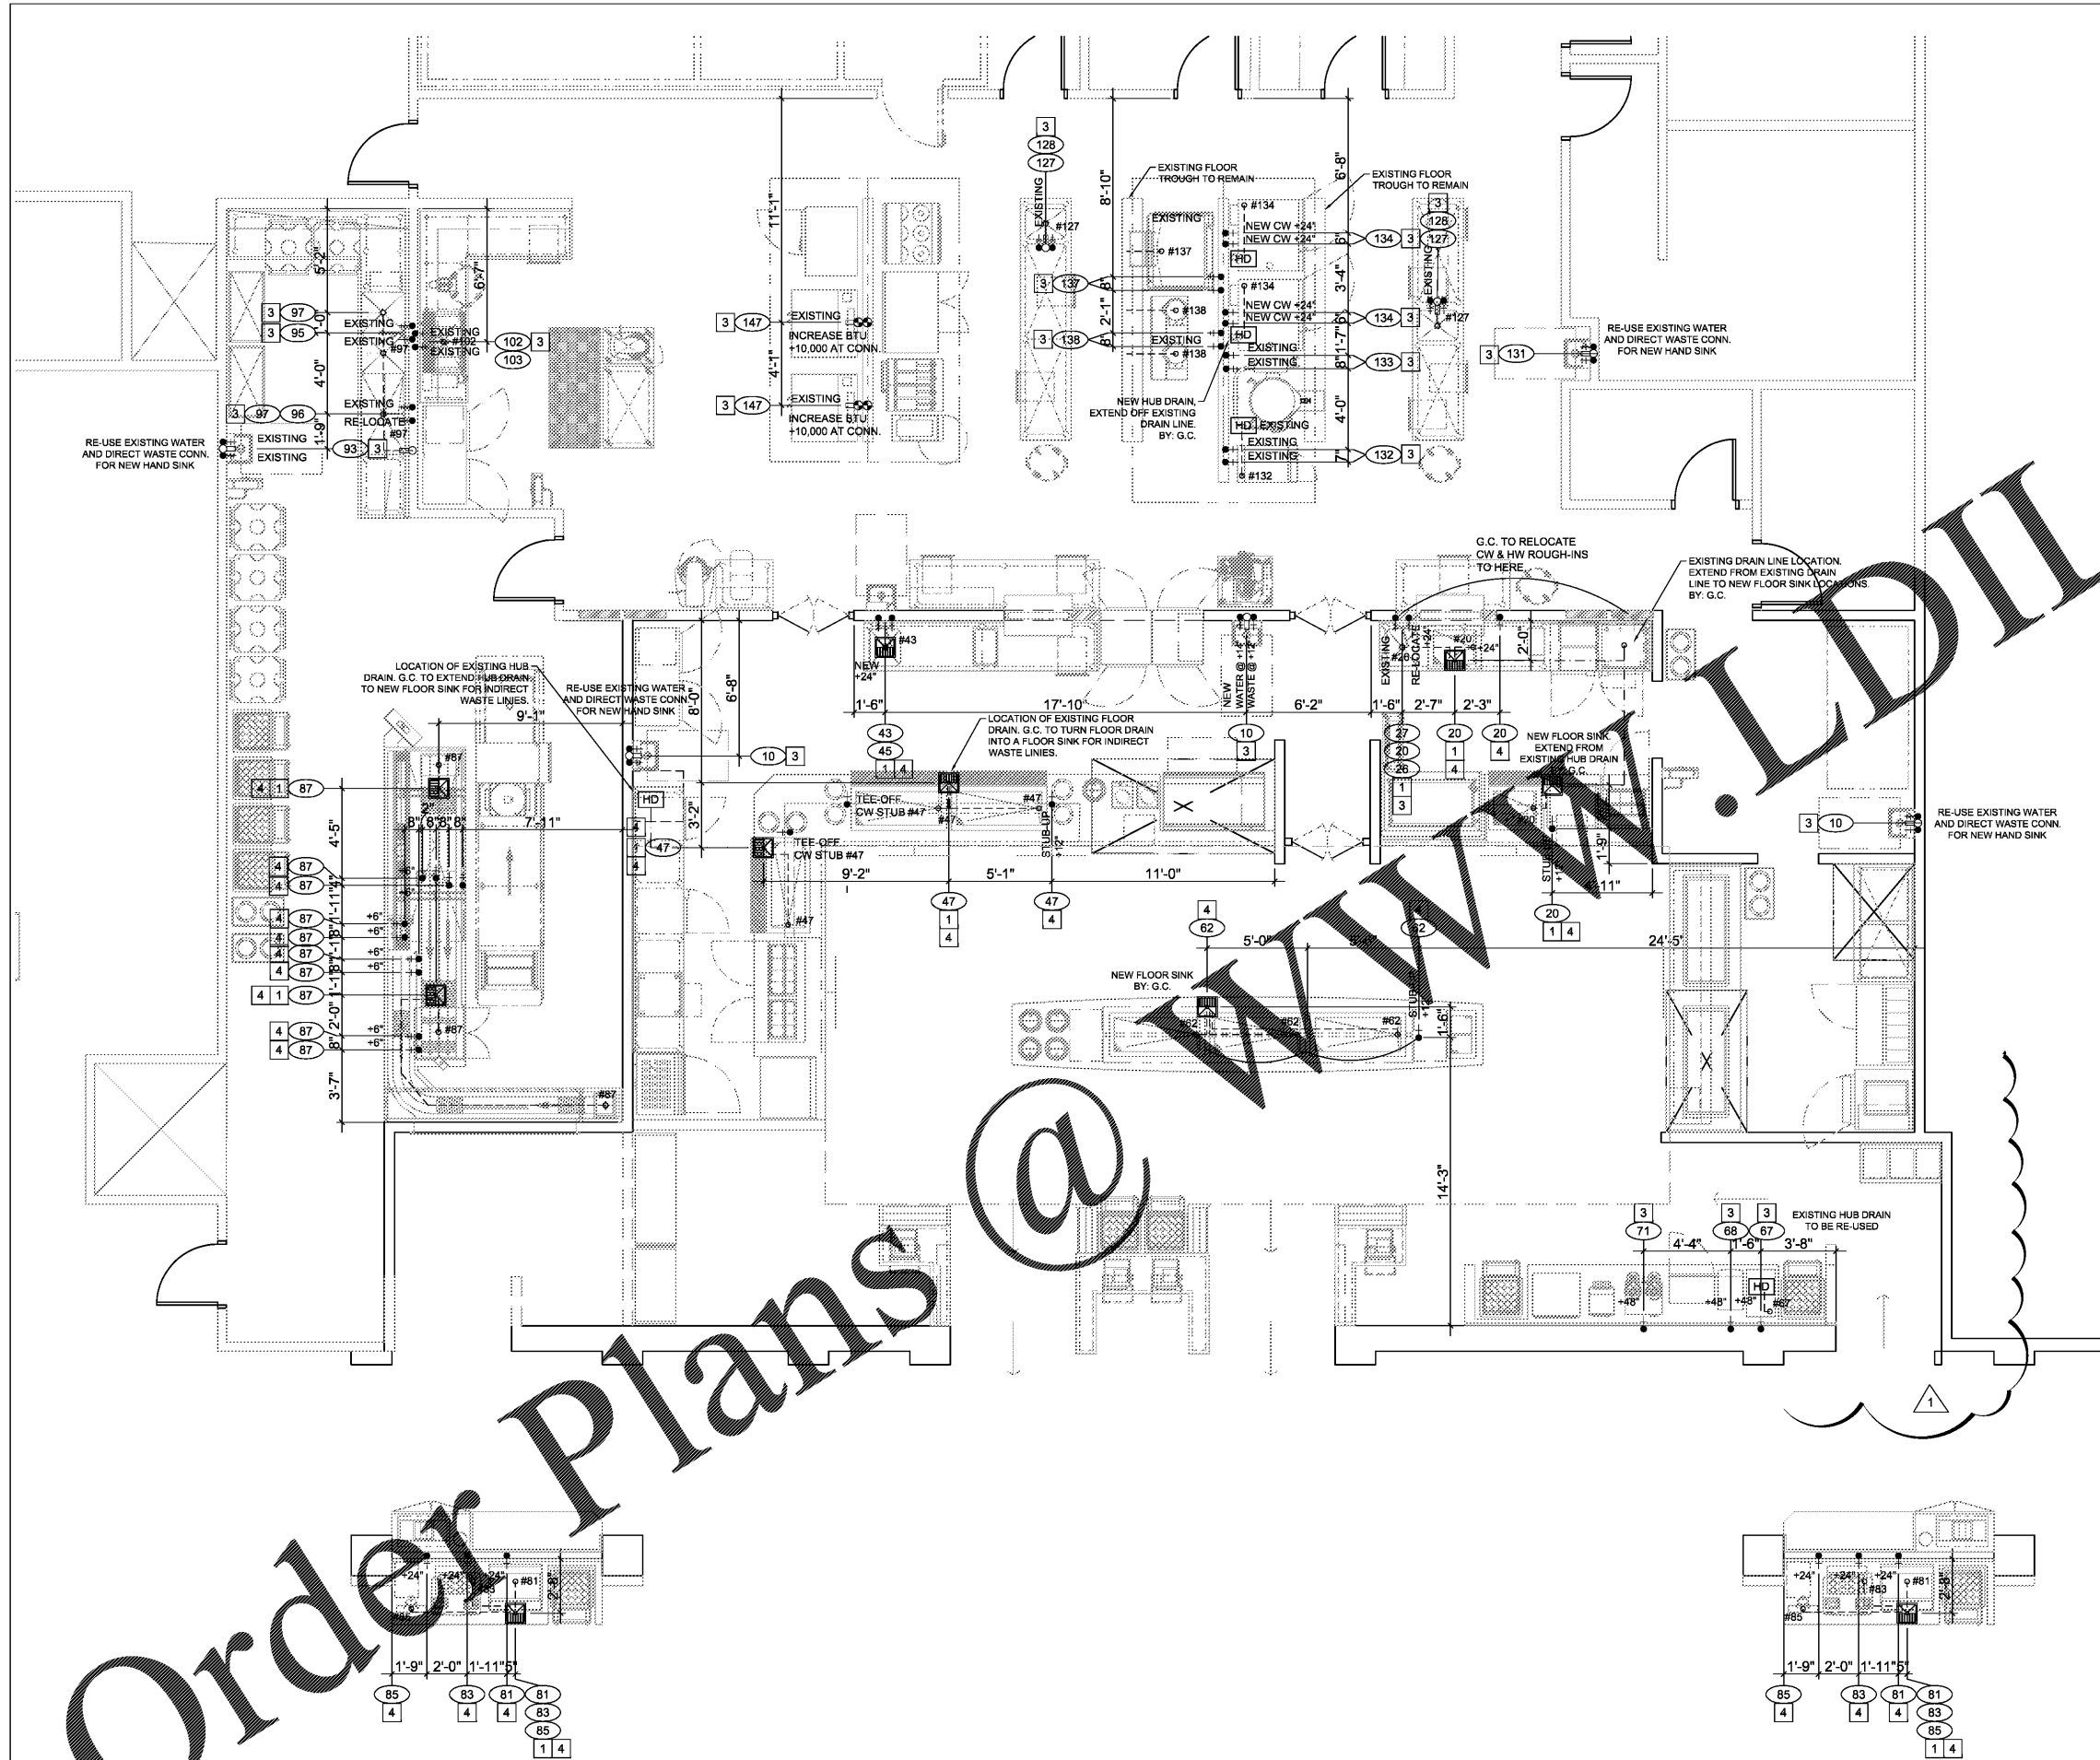

FOODSERVICE PLUMBING ROUGH-IN PLAN
1/4" = 1'-0"

Charleston AFB, SC
Project Address

DFAC - F.T.I. Project

PROJECT NUMBER:	Project Number
DATE:	19th April, 2018
SCALE:	1/4" = 1'-0"
DRAWN BY:	ADK
APPROVED BY:	RIM

SHEET TITLE:
FOODSERVICE PLUMBING ROUGH-IN PLAN

SHEET NUMBER:
FS-4.0

NOTES:
ALL DIMENSIONS ARE FINISH TO FINISH
REFER TO SHEET K-000 FOR ALL NOTES, SYMBOLS, ETC. PERTAINING TO THIS PROJECT.

Order Plans @ www.LDILine.com