

ISSUANCE

DATE	NO.	DESCRIPTION
XX/XX/XXXX	-	-

PLUMBING LEGEND

- + COLD WATER STUB
- +o COLD WATER STUB (FROM FILTER)
- +f COLD WATER STUB (IN-LINE FILTER)
- +• HOT WATER STUB
- +•• HOT WATER STUB (180°)
- +••• CHILLED WATER SUPPLY
- +•••• CHILLED WATER RETURN
- WS- WATER LINE (FROM SOURCE TO EQUIPMENT)
- o- DIRECT WASTE
- o-•- INDIRECT DRAIN LINE TO FLOOR SINK
- o-•-•- GAS STUB (NATURAL GAS SUPPLY)
- o-•-•-•- MANUAL GAS SHUT-OFF VALVE
- o-•-•-•-•- AUTOMATIC GAS SHUT-OFF VALVE
- o-•-•-•-•-•- STEAM SUPPLY
- o-•-•-•-•-•-•- STEAM RETURN
- o-•-•-•-•-•-•-•- FLOOR SINK
- o-•-•-•-•-•-•-•- FLOOR SINK (WITH 1/2" SLOPE)
- o-•-•-•-•-•-•-•- FLOOR SINK (WITH SLOPE PER CODE)
- o-•-•-•-•-•-•-•-•- SINK IN FLOOR
- o-•-•-•-•-•-•-•-•-•- ITEM NUMBER (SEE EQUIPMENT SCHEDULE)
- o-•-•-•-•-•-•-•-•-•- DOWN FROM ABOVE

PLUMBING KEY NOTES

- 1 ALL FLOOR SINKS TO BE FLUSH WITH FINISHED FLOOR
- 2 WATER SUPPLY FOR ICE MACHINE TO BE INTERCONNECTED FROM FILTER.
- 3 G.C. / P.C. TO RE-USE EXISTING WATER IN THIS LOCATION AND RE-WORK ROUGH-INS AS REQUIRED TO ACCOMMODATE THE NEW FOODSERVICE EQUIPMENT AS SHOWN ON THE FOODSERVICE.
- 4 G.C. / P.C. TO SUPPLY NEW PLUMBING ROUGH-INS AND/OR FLOOR SINK(S) AS SHOWN ON THE FOODSERVICE DRAWINGS.

NOTES:

ALL DIMENSIONS ARE FINISH TO FINISH

REFER TO SHEET K-000 FOR ALL NOTES, SYMBOLS, ETC. PERTAINING TO THIS PROJECT.

Charleston AFB, SC
Project Address

Project Address

DFAC - F.T.I. Project

PROJECT NUMBER:

Project Number

DATE:

19th April, 2018

SCALE:

1/4" = 1'-0"

DRAWN BY:

ADK

APPROVED BY:


RIM

SHEET TITLE:

**FOODSERVICE
PLUMBING
ROUGH-IN PLAN**

SHEET NUMBER:

FS-4.0

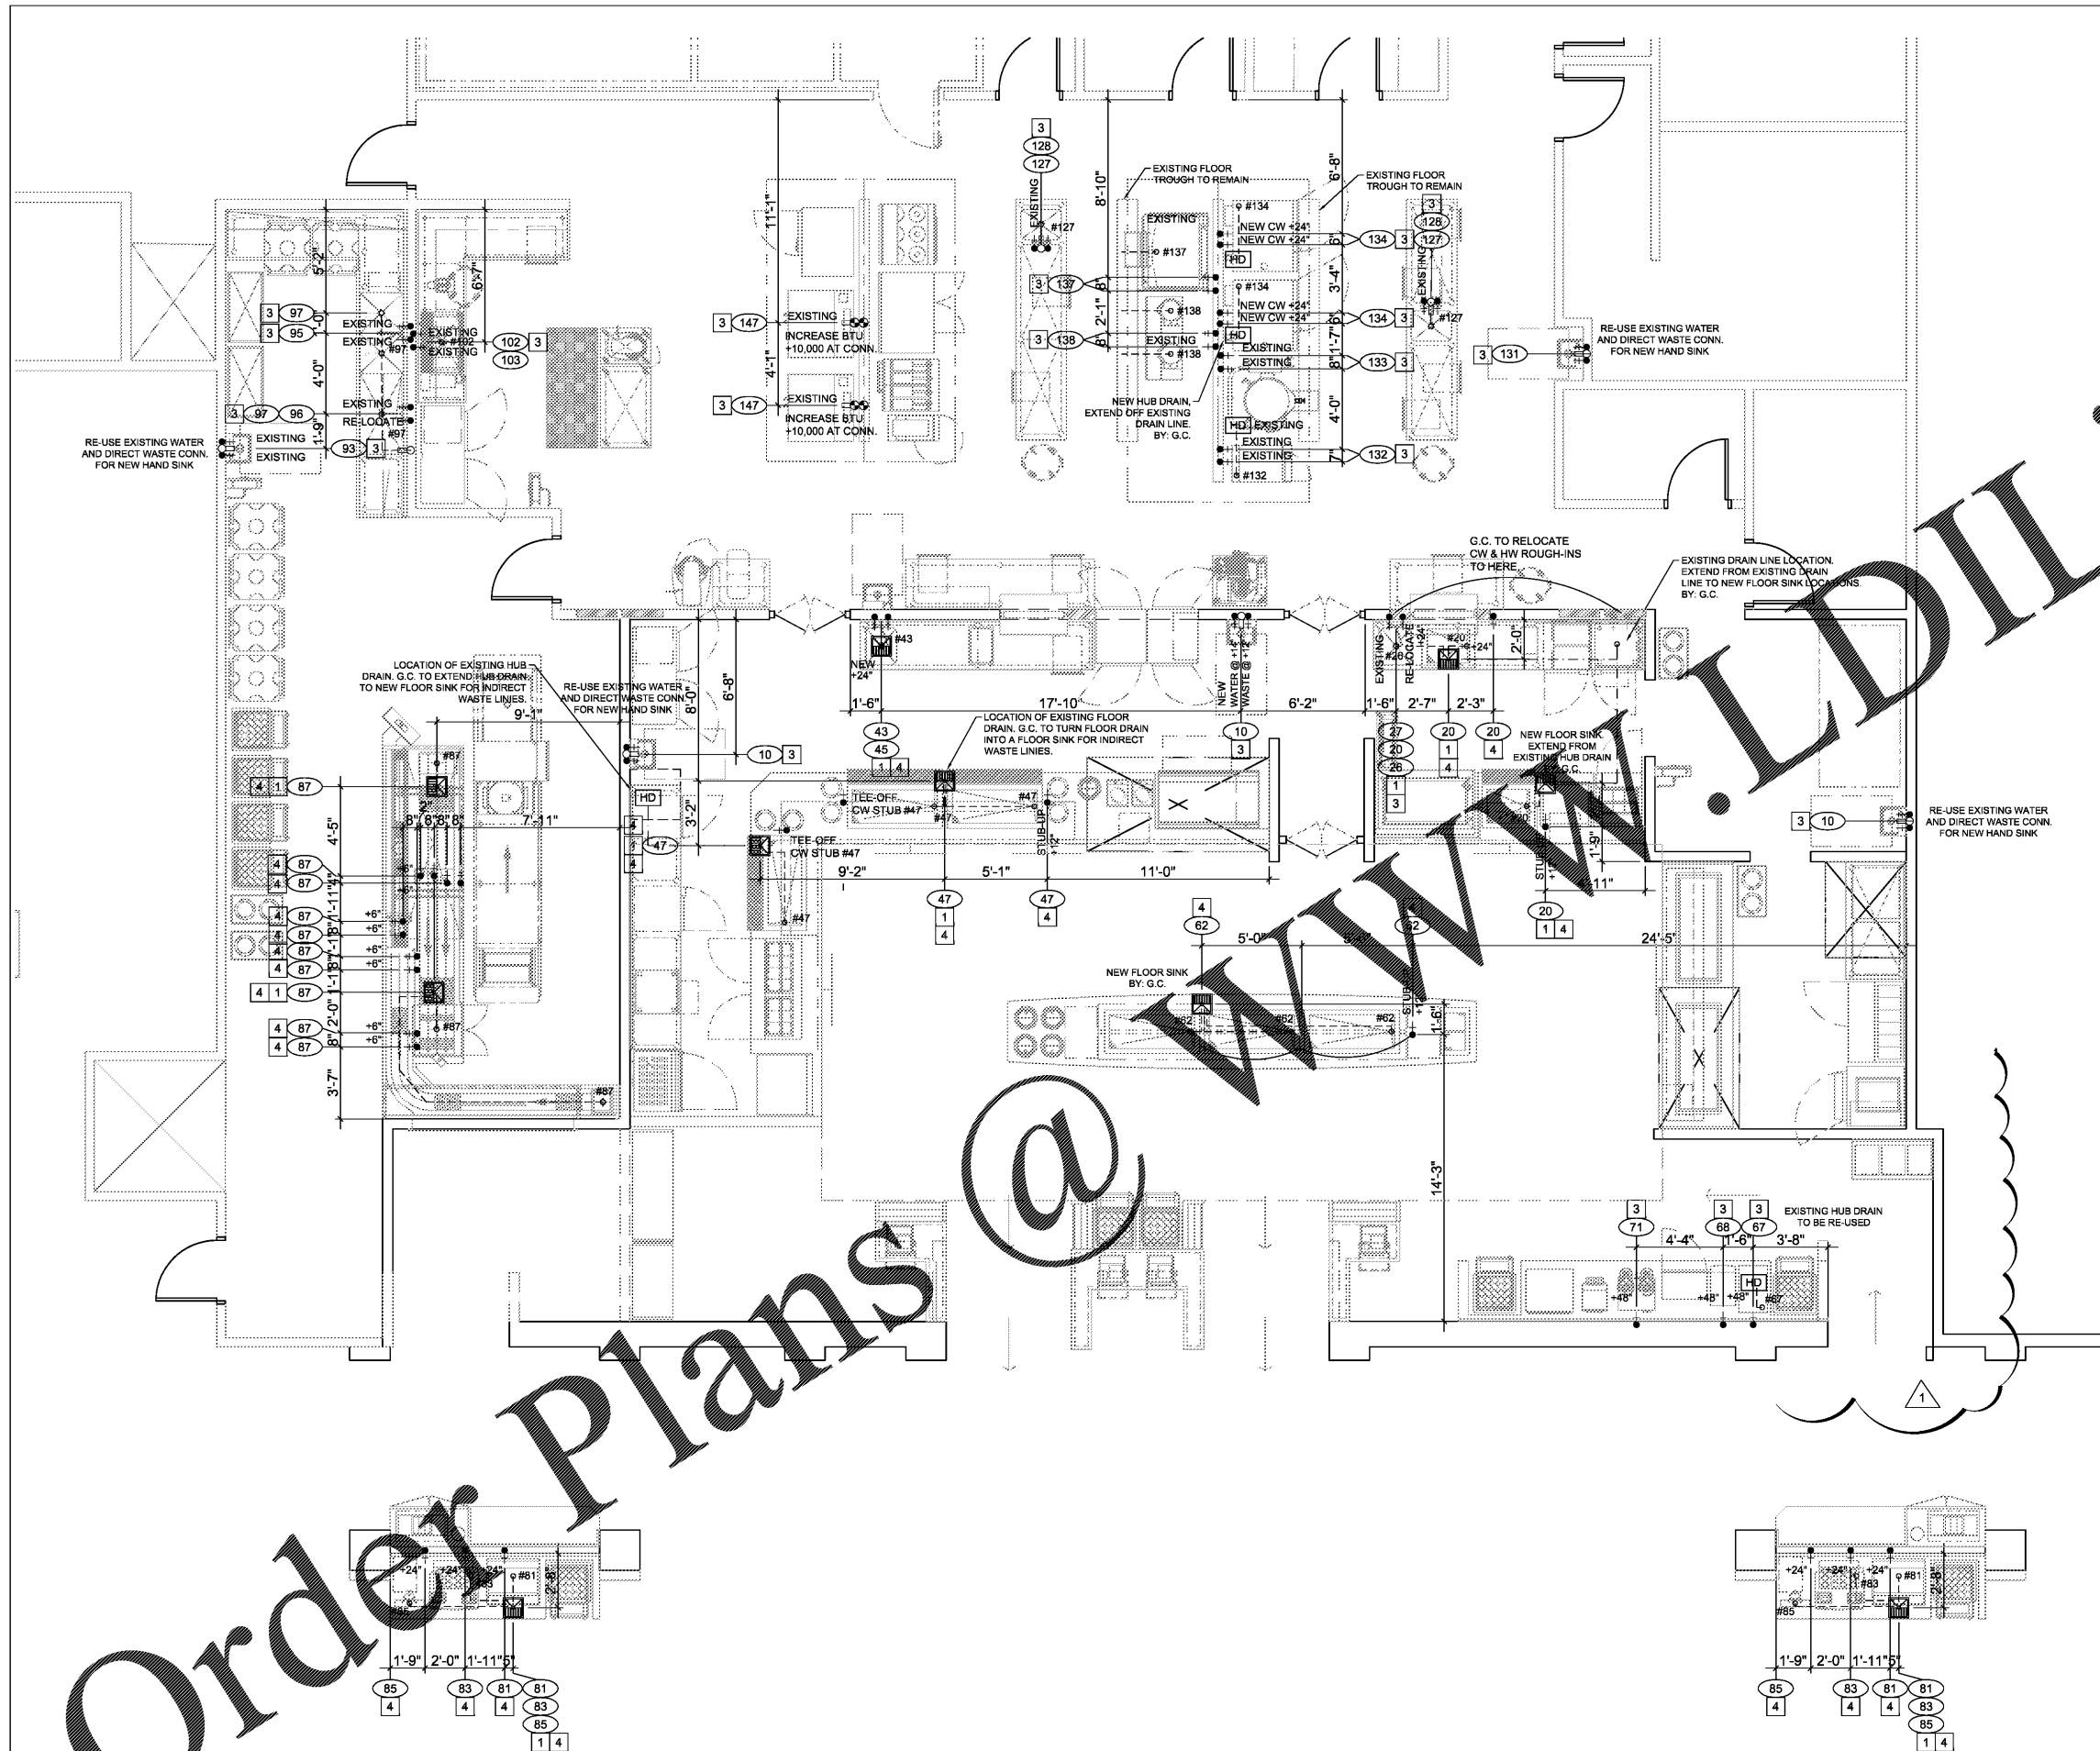

FOODSERVICE PLUMBING ROUGH-IN PLAN
1/4" = 1'-0"

Order Plans @