


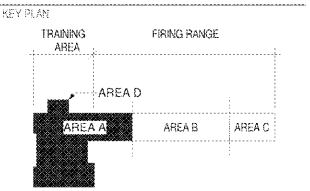
DESIGNER
CLARK NEXSEN
 213 South Jefferson, Suite 1011
 Roanoke, Virginia 24011
 540-962-0800
 www.clarknexsen.com
 Clark Nexsen License Number: C-1028

SEALS

 David Monahan
 ARCHITECT
 License No. 12148

SUBMITTAL
 4 MAY 2018
CONSTRUCTION DOCUMENTS

REVISIONS


NO.	DATE	DESCRIPTION



SHEET
ARCHITECTURAL SITE PLAN

AE100

DESIGN: DJM
 DRAWN: ZLT
 REVIEW: JCS
 CN 5938

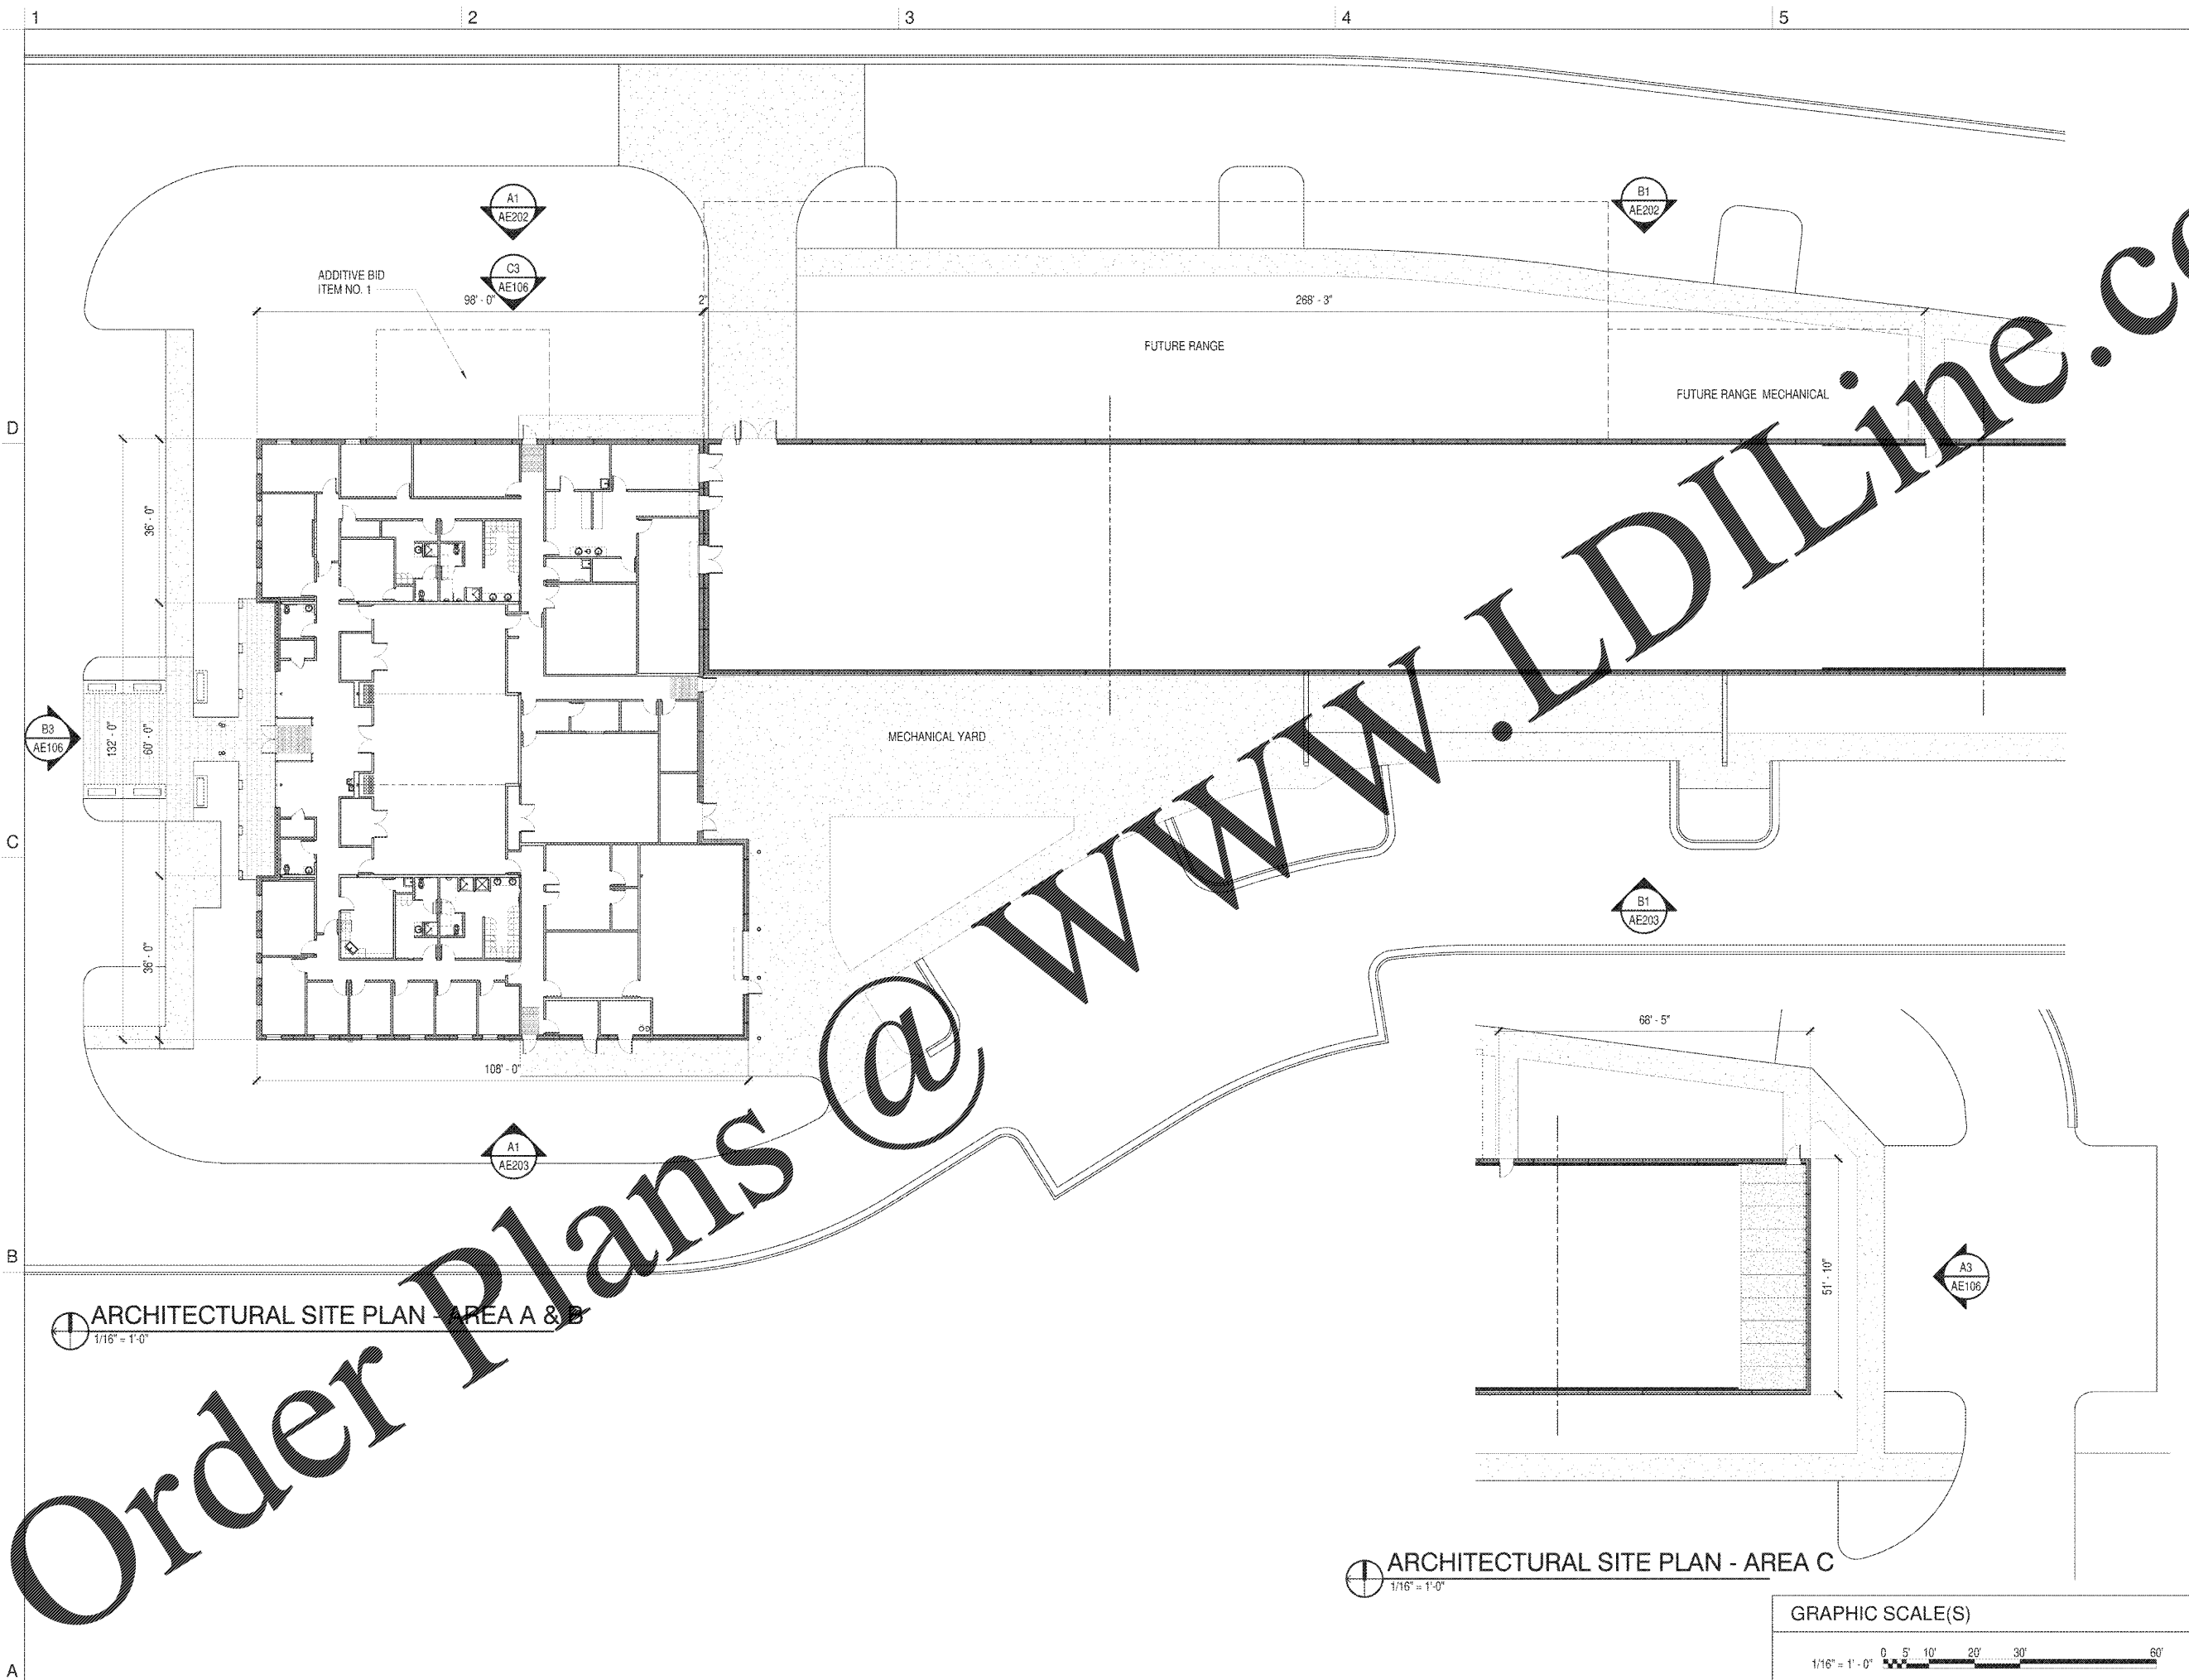

S:\2018\18-052-09 PK\02 Plant\Project\2018 Police Fire City Training Facility A17.dwg
 5/15/2018 10:52:09 AM
 D:\Plant\Project\2018 Police Fire City Training Facility A17.dwg

Order Plans @ www.LDILine.com