


DESIGNER
CLARK NEXSEN
 213 South Jefferson, Suite 1011
 Roanoke, Virginia 24011
 540-982-0800
 Clark Nexsen License Number: C-1028

CONSULTANT
 SEALS



SUBSETTLE
 4 MAY 2018
CONSTRUCTION DOCUMENTS

REVISIONS


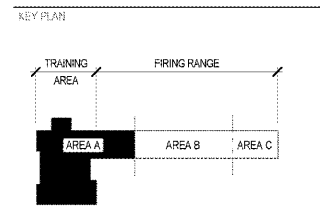


SHEET
FIRST FLOOR PLAN - AREA A


FP101

SHEET OF XX

DESIGN: RCF
 DRAWN: EVA
 REVIEW: CHB
 CN 5938

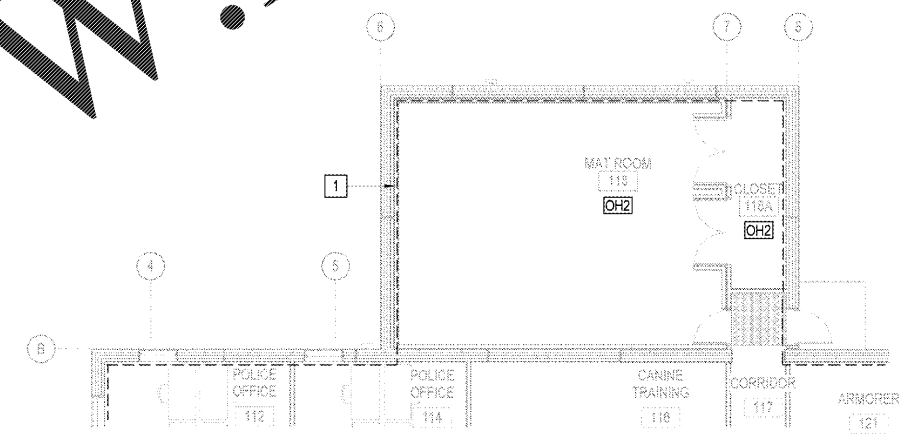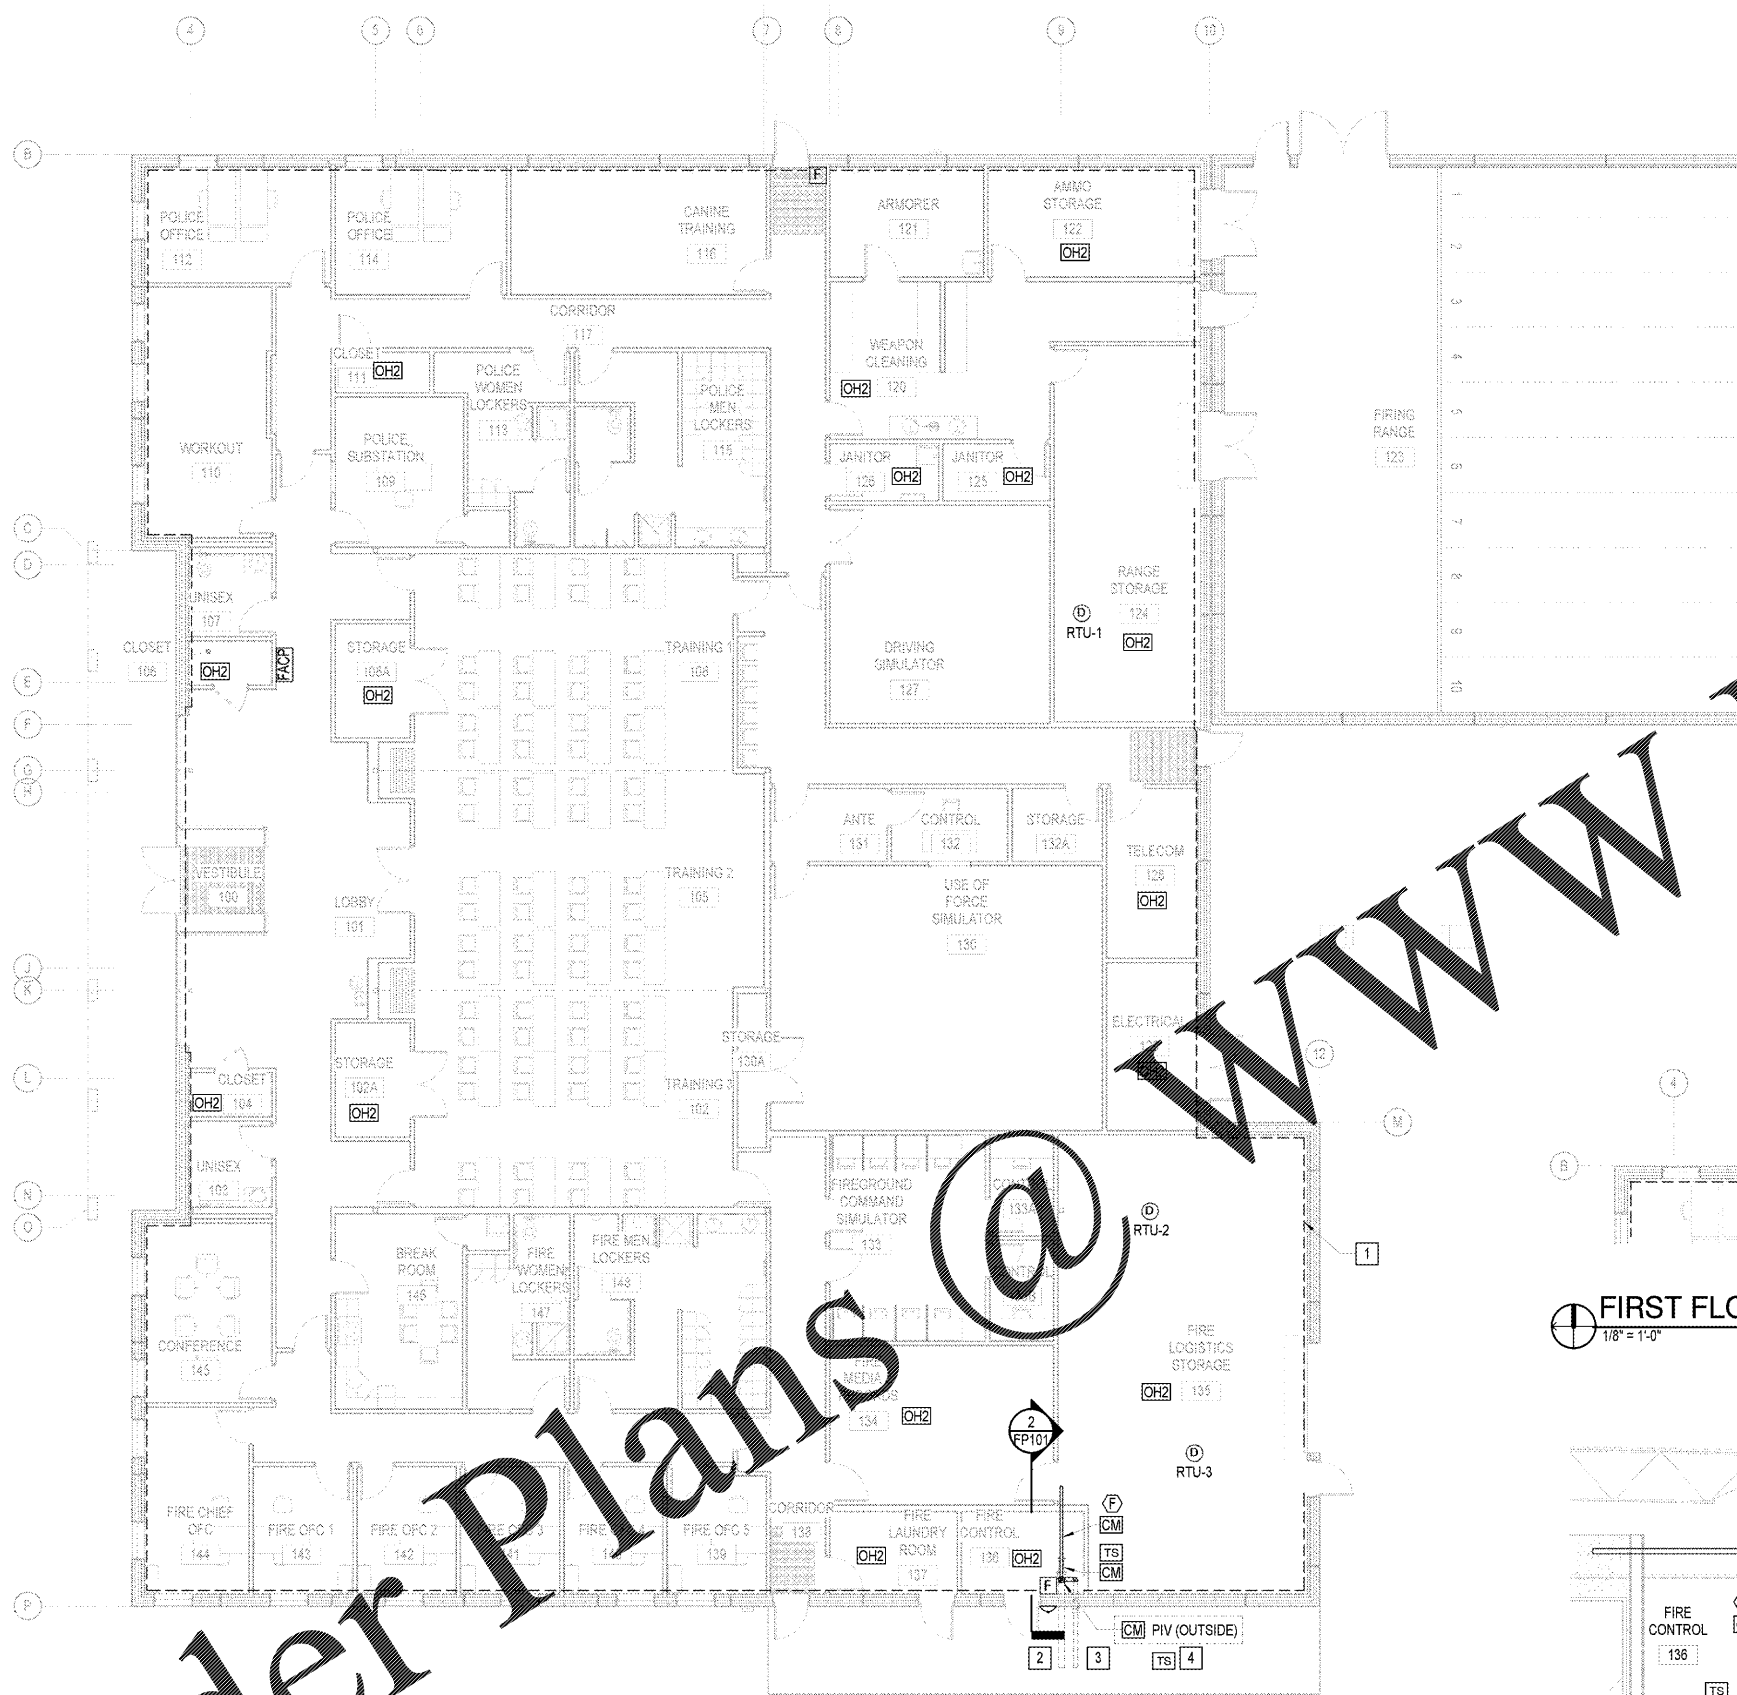

FIRST FLOOR - MAT ROOM ALTERNATE PLAN
 1/8" = 1'-0"

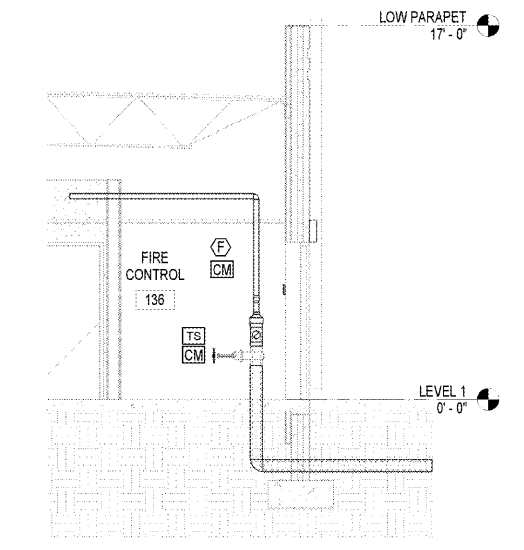

WATER PIPE ENTRY ELEVATION
 1/4" = 1'-0"

- CONSTRUCTION NOTES**
1. PROVIDE SPRINKLER SYSTEM IN ADMINISTRATIVE BUILDING ONLY.
 2. 6" FIRE PROTECTION SERVICE. REFER TO CIVIL DRAWINGS FOR CONTINUATION.
 3. 4" FIRE DEPARTMENT CONNECTION. REFER TO CIVIL DRAWINGS FOR CONTINUATION.
 4. SUPERVISE POST INDICATOR VALVE. PROVIDE SURGE SUPPRESSION WHERE CIRCUIT LEAVES BUILDING.
 5. SUPERVISE BACKFLOW PREVENTER VALVES. PROVIDE MONITOR MODULE(S) AND TAMPER SWITCHES IN BACKFLOW PREVENTER ENCLOSURE. PROVIDE SURGE SUPPRESSION WHERE CIRCUIT LEAVES BUILDING.



Order Plans @

WWW.LDILine.com