


WILMINGTON, NC
**HAYNES / LACEWELL
 POLICE AND FIRE
 TRAINING FACILITY**


DESIGNER
CLARKNEXSEN
 213 South Jefferson, Suite 1011
 Roanoke, Virginia 24011
 540-982-0800
 www.clarknexsen.com
 Clark Nexsen License Number: C-1028

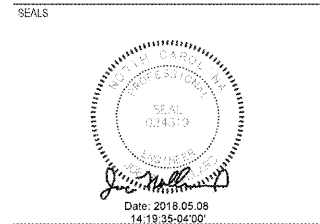

SUBMITTAL
 4 MAY 2018
 CONSTRUCTION DOCUMENTS

REVISIONS


NO.	DESCRIPTION

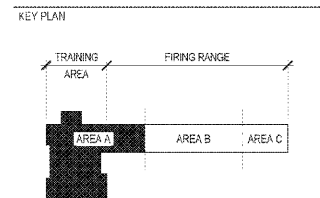

SHEET
 UNDERGROUND PIPING PLAN

PL100

DESIGN: RWH
 DRAWN: RWH
 REVIEW: DAC
 CN 5938

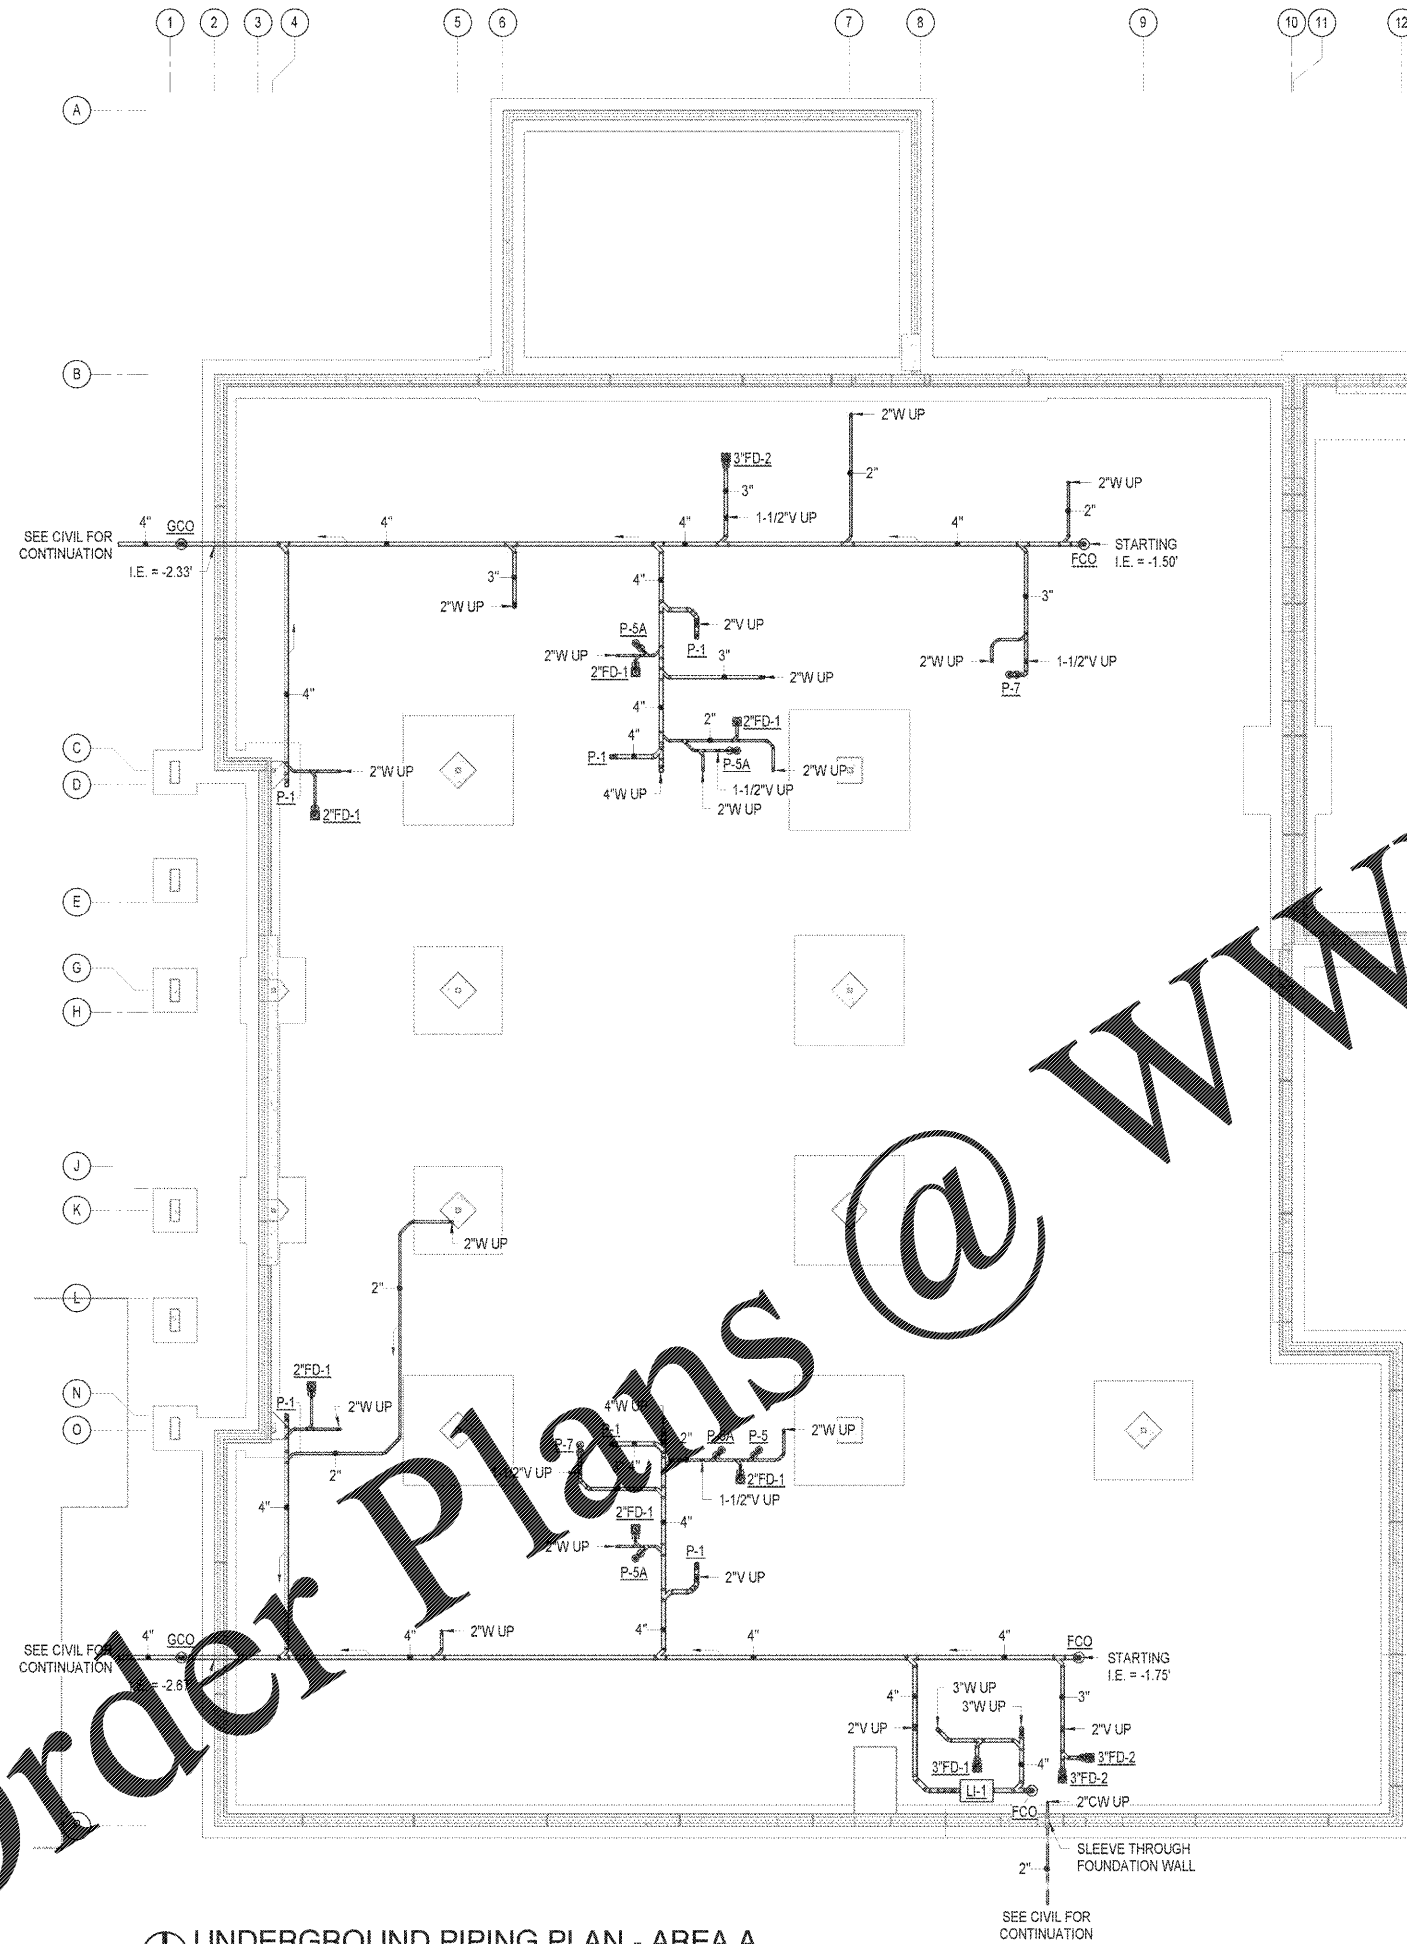

UNDERGROUND PIPING PLAN - AREA A
 1/8" = 1'-0"

GRAPHIC SCALE(S)

