


WILMINGTON, NC
**HAYNES / LACEWELL
 POLICE AND FIRE
 TRAINING FACILITY**


DESIGNER
CLARKNEXSEN
 213 South Jefferson, Suite 1011
 Roanoke, Virginia 24011
 540-982-0800
 www.clarknexsen.com
 Clark Nexsen License Number: C-1028

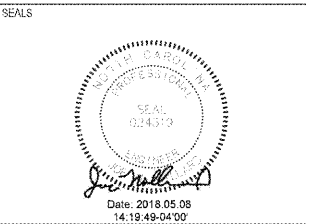

SUBMITTAL
 4 MAY 2018
CONSTRUCTION DOCUMENTS

REVISIONS


NO.	DATE	DESCRIPTION

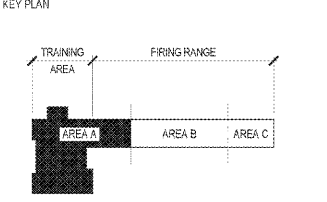


SHEET
FIRST FLOOR PLAN

PL101

DESIGN: RWH
 DRAWN: RWH
 REVIEW: DAC
 CN 5938

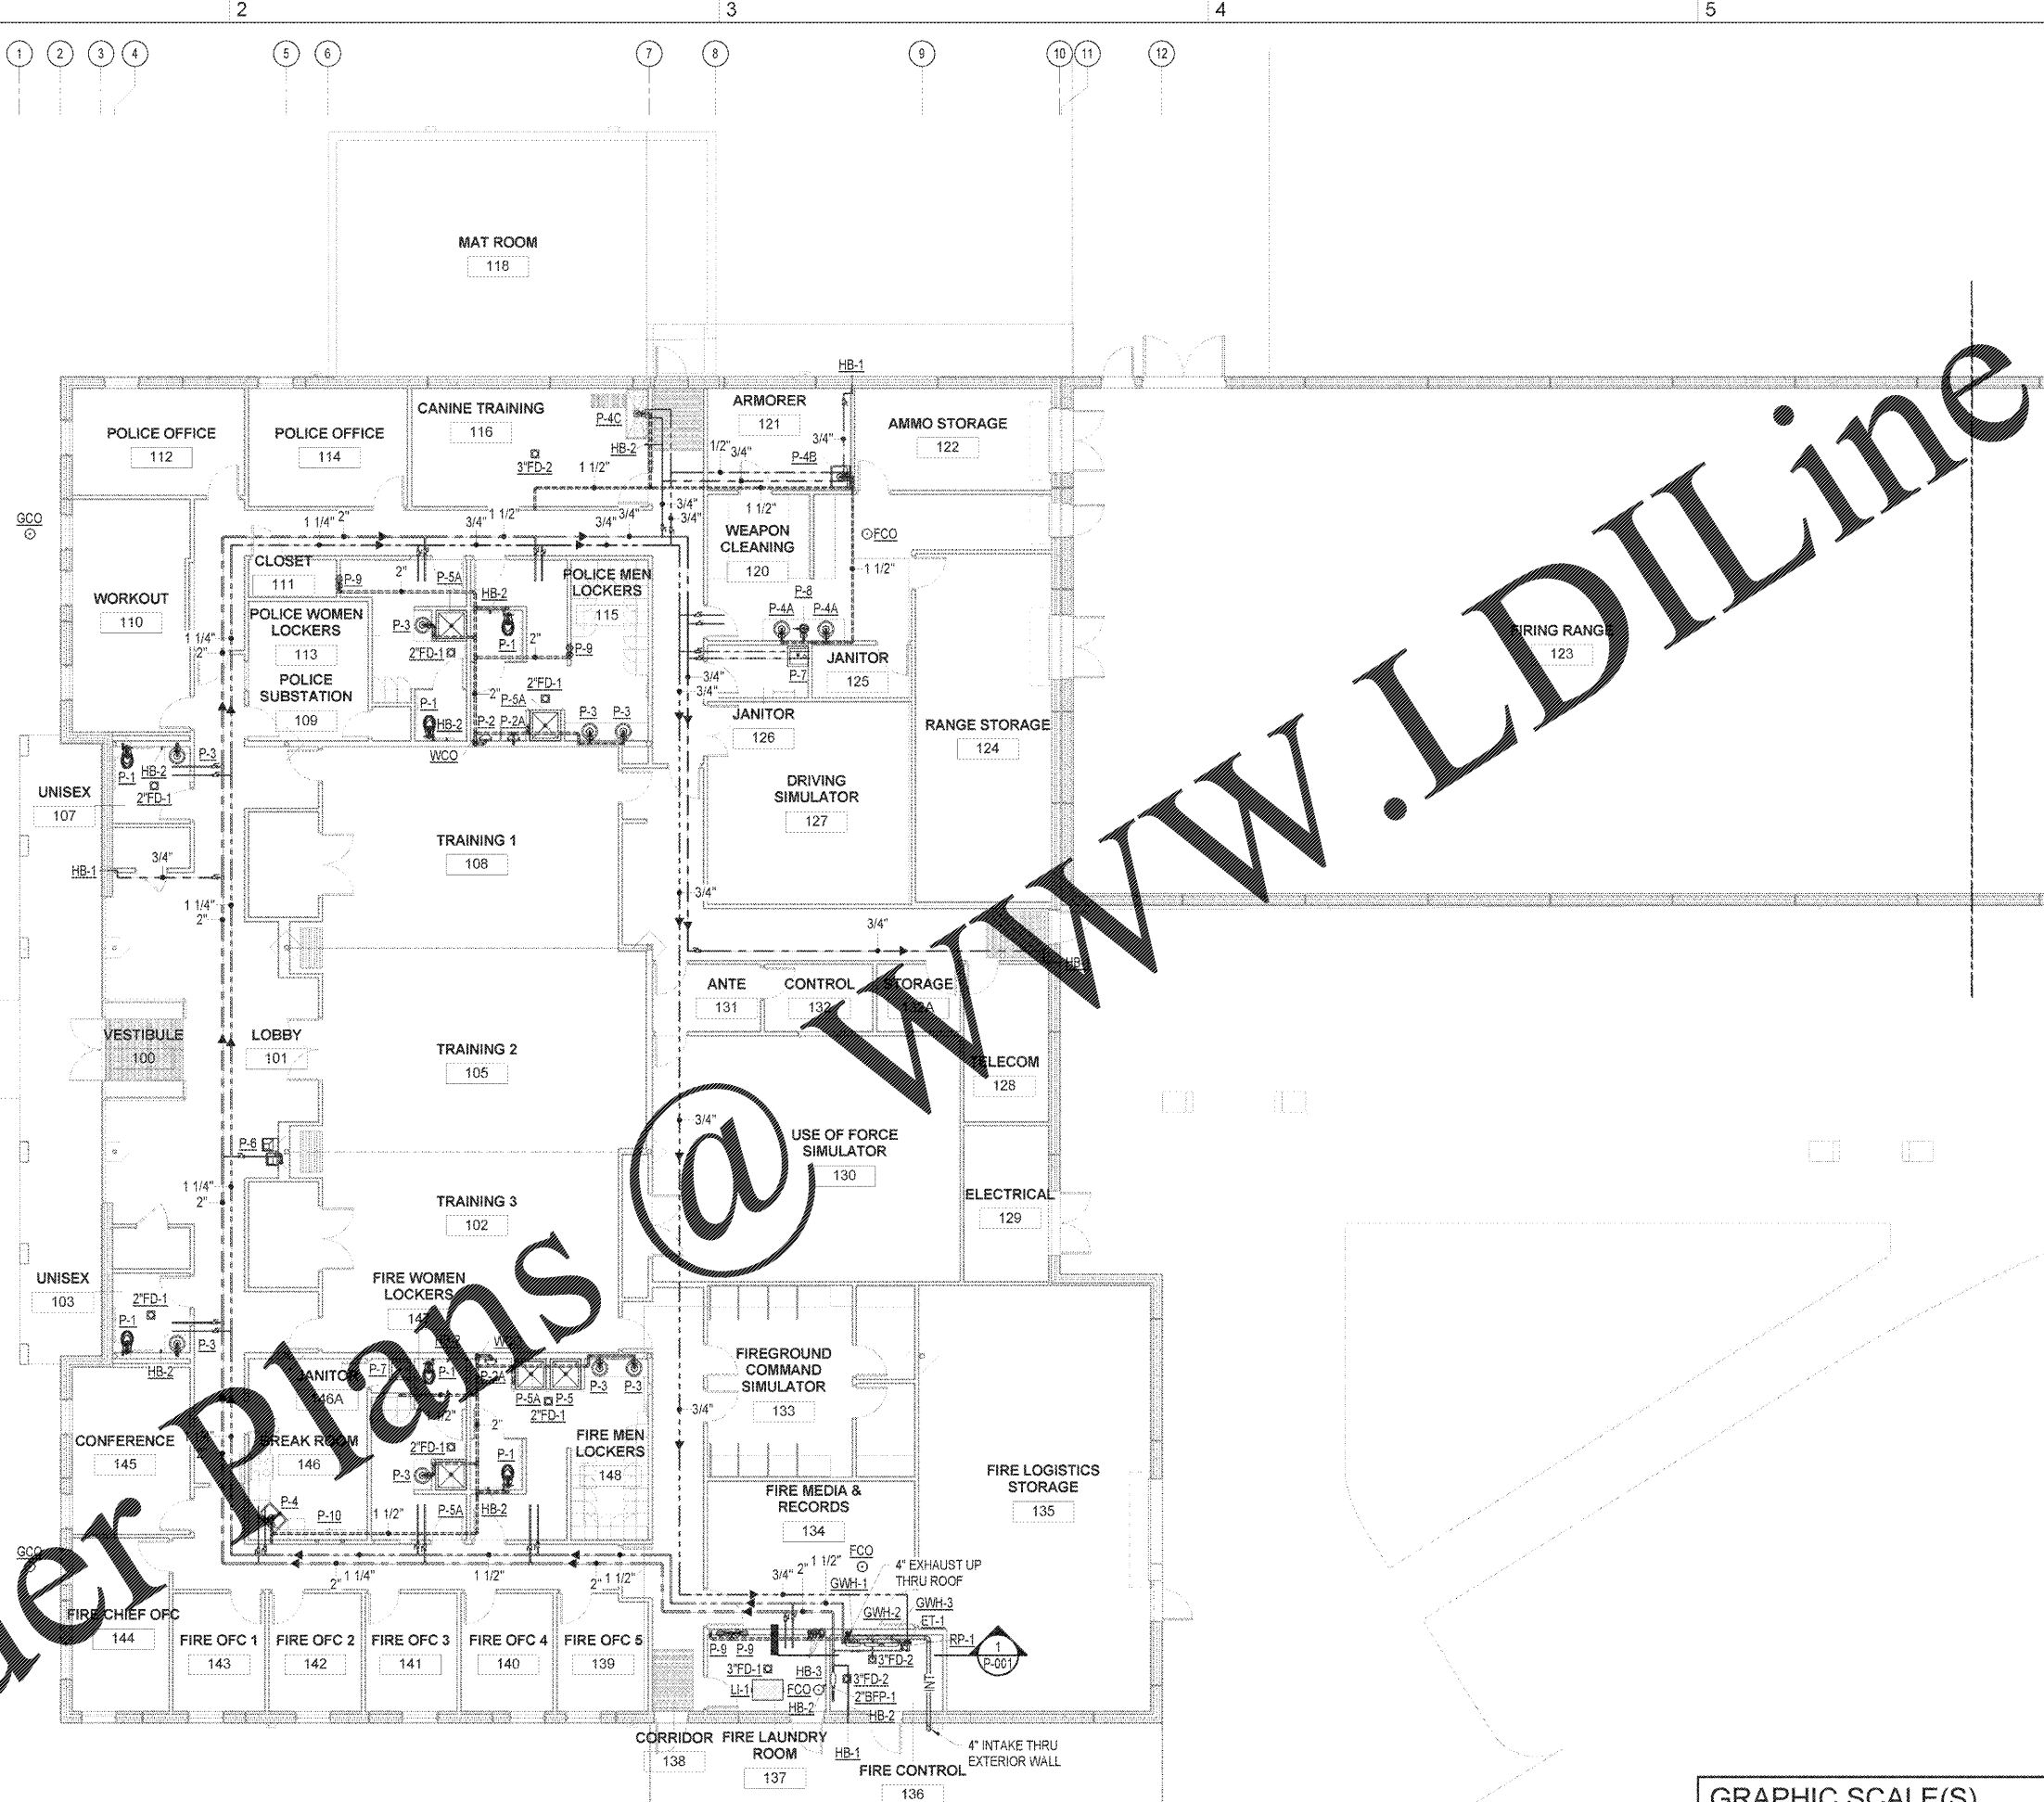

FIRST FLOOR PLAN - AREA A
 1/8" = 1'-0"

 

5/2/2018 10:56:21 AM
 C:\Renov\Projects\1938 Police Fire Training Facility\PL101_nchhmk.rvt

1 2 3 4 5 6 7 8 9 10 11 12
 A B C D E G H J K L N O P
 D C B A

