


DESIGNER
CLARK NEXSEN
 213 South Jefferson, Suite 1011
 Roanoke, Virginia 24011
 540-982-0800
 www.clarknexsen.com
 Clark Nexsen License Number: C-1028

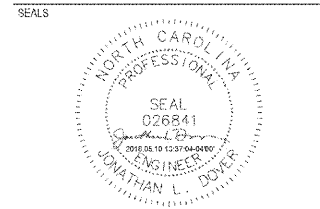

SUBMITTAL
 4 MAY 2018
CONSTRUCTION DOCUMENTS


REVISIONS

#	DESCRIPTION


SHEET
FLOOR PLAN - AREA B

MH102

DESIGN: JLD
 DRAWN: DRL
 REVIEW: EES
 CN 5938

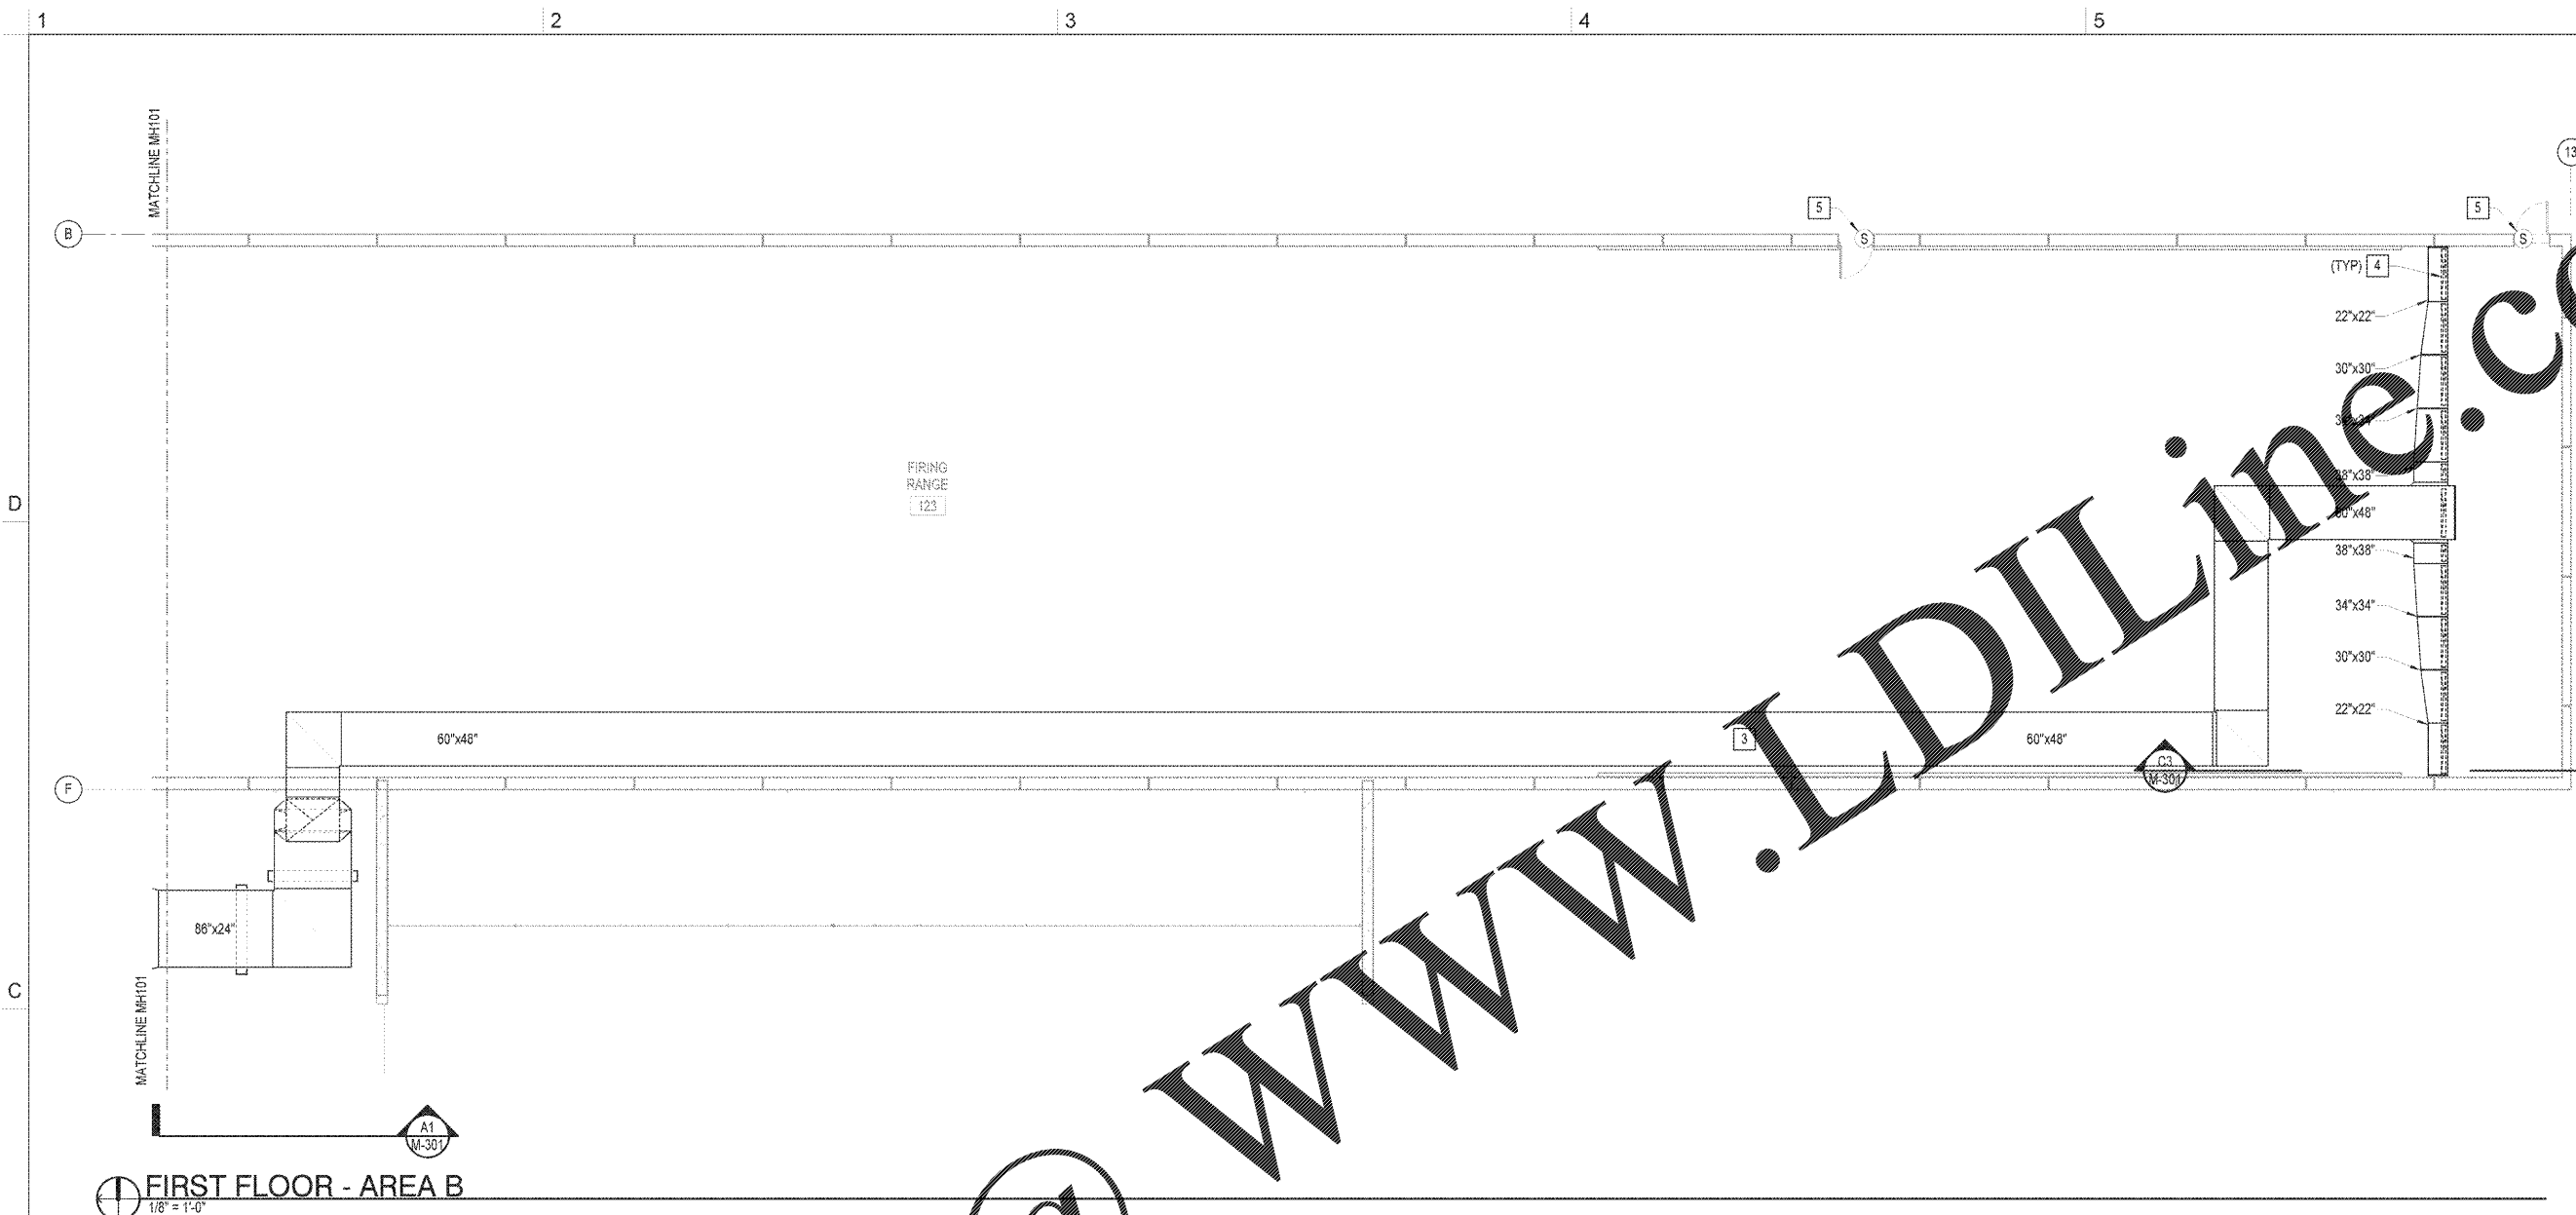

FIRST FLOOR - AREA B
 1/8" = 1'-0"

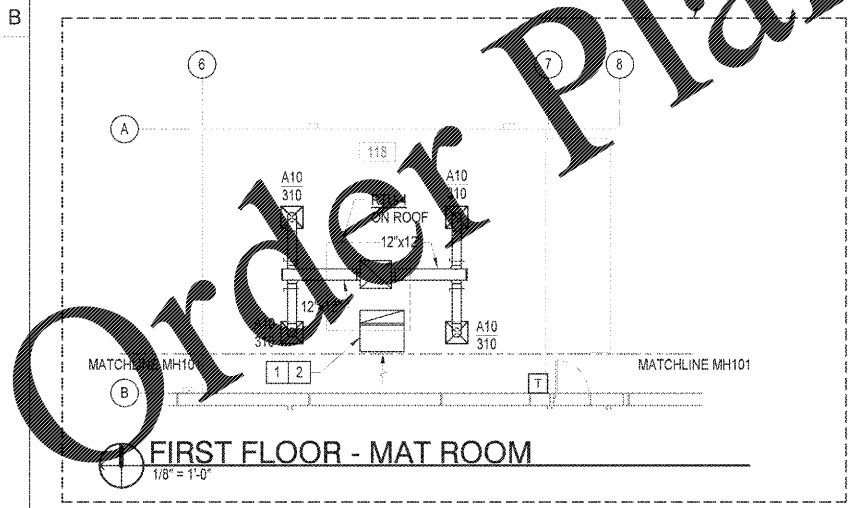

FIRST FLOOR - MAT ROOM
 1/8" = 1'-0"

 
GENERAL NOTES

- REFER TO SHEET M-001 FOR GENERAL NOTES, LEGEND AND ABBREVIATIONS.

CONSTRUCTION NOTES

- ACOUSTICALLY LINED RETURN DUCT TO RTU.
- SEE RTU RETURN DUCT INLET INLET DETAIL, SHEET M-501.
- COORDINATE DUCT SIZE AND MOUNTING WITH BALLISTIC STEEL BAFFLE PROVIDER / INSTALLER.
- 5" WIDE CONTINUOUS SLOT IN BOTTOM OF DUCT. SLOT SHALL EXTEND TO 2" FROM END OF DUCT SECTION.
- MAGNETIC DOOR SWITCH.

GRAPHIC SCALE(S)



Order Plans @ www.LDILine.com