






DESIGNER
CLARK NEXSEN
 213 South Jefferson, Suite 1011
 Roanoke, Virginia 24011
 540-982-0800
 www.clarknexsen.com
 Clark Nexsen License Number: C-1028

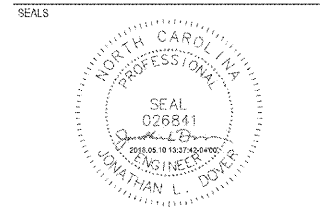

SUBMITTAL
 4 MAY 2018
CONSTRUCTION DOCUMENTS

REVISIONS

NO.	DESCRIPTION

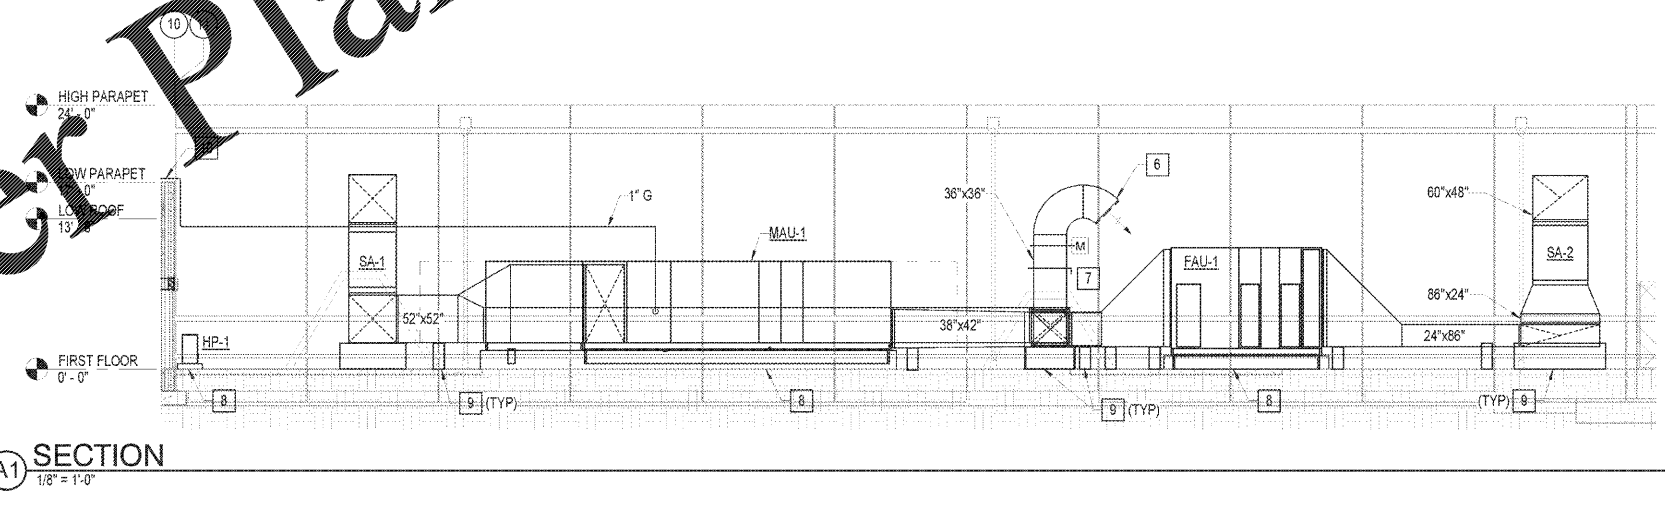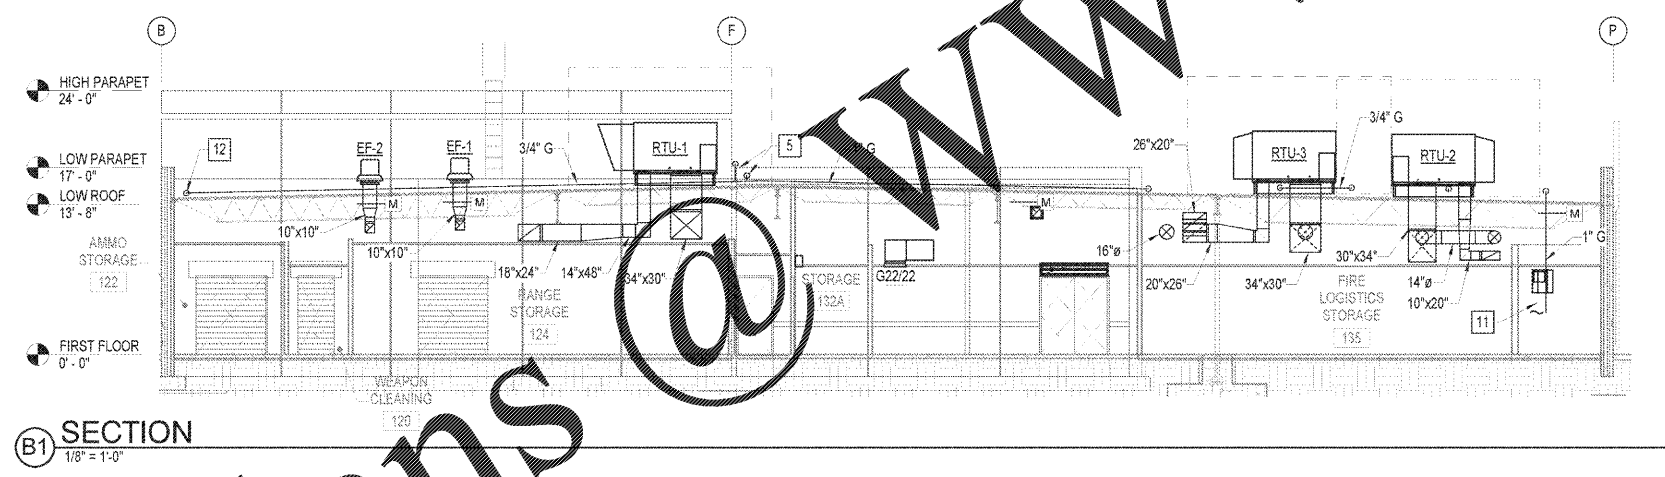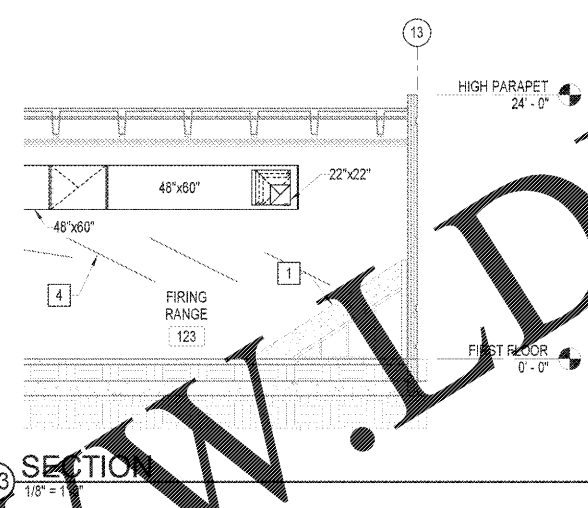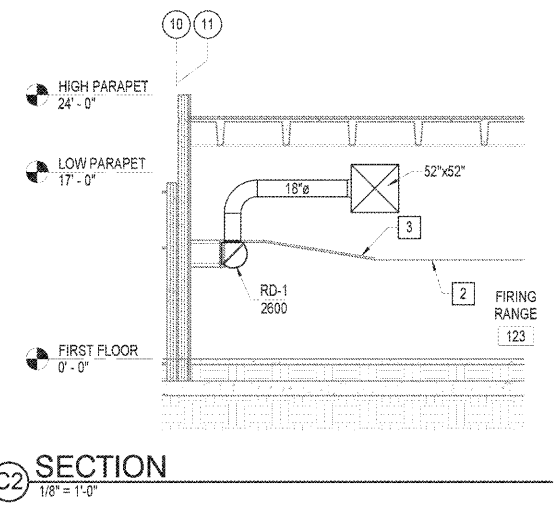


GENERAL NOTES

- REFER TO SHEET M-001 FOR GENERAL NOTES, LEGEND AND ABBREVIATIONS.

CONSTRUCTION NOTES

- BULLET TRAP.
- SAFETY CEILING.
- ACOUSTIC TILE CEILING.
- BALLISTIC STEEL BAFFLES.
- GAS PIPING TO MAU-1; SEE ROOF PLAN SHEET MH103.
- SEE EXHAUST DUCT OUTLET DETAIL, SHEET M-501.
- BALANCE TO 11830.
- CONCRETE EQUIPMENT PAD.
- DUCT SUPPORT; SPACING AS REQUIRED BY SMACNA.
- GAS PIPING; SEE ROOF PLAN, SHEET MH103.
- 1" DOWN TO GAS WATER HEATERS; SEE PLUMBING SHEETS.
- 3/4" GAS PIPING TO RTU-4 (ADDITIVE BID ITEM #1).

 GRAPHIC SCALE(S)



SHEET
SECTIONS

M-301

DESIGN: JLD
 DRAWN: DRL
 REVIEW: EES
 CN 5938