



SHEET NOTES
 ① BCU PROVIDED FOR TEMPORARY COOLING
 OF SHELL SPACE. MOUNT @ +/- 10'-0" A.F.F.



5/21/2016 13:23:36 PM

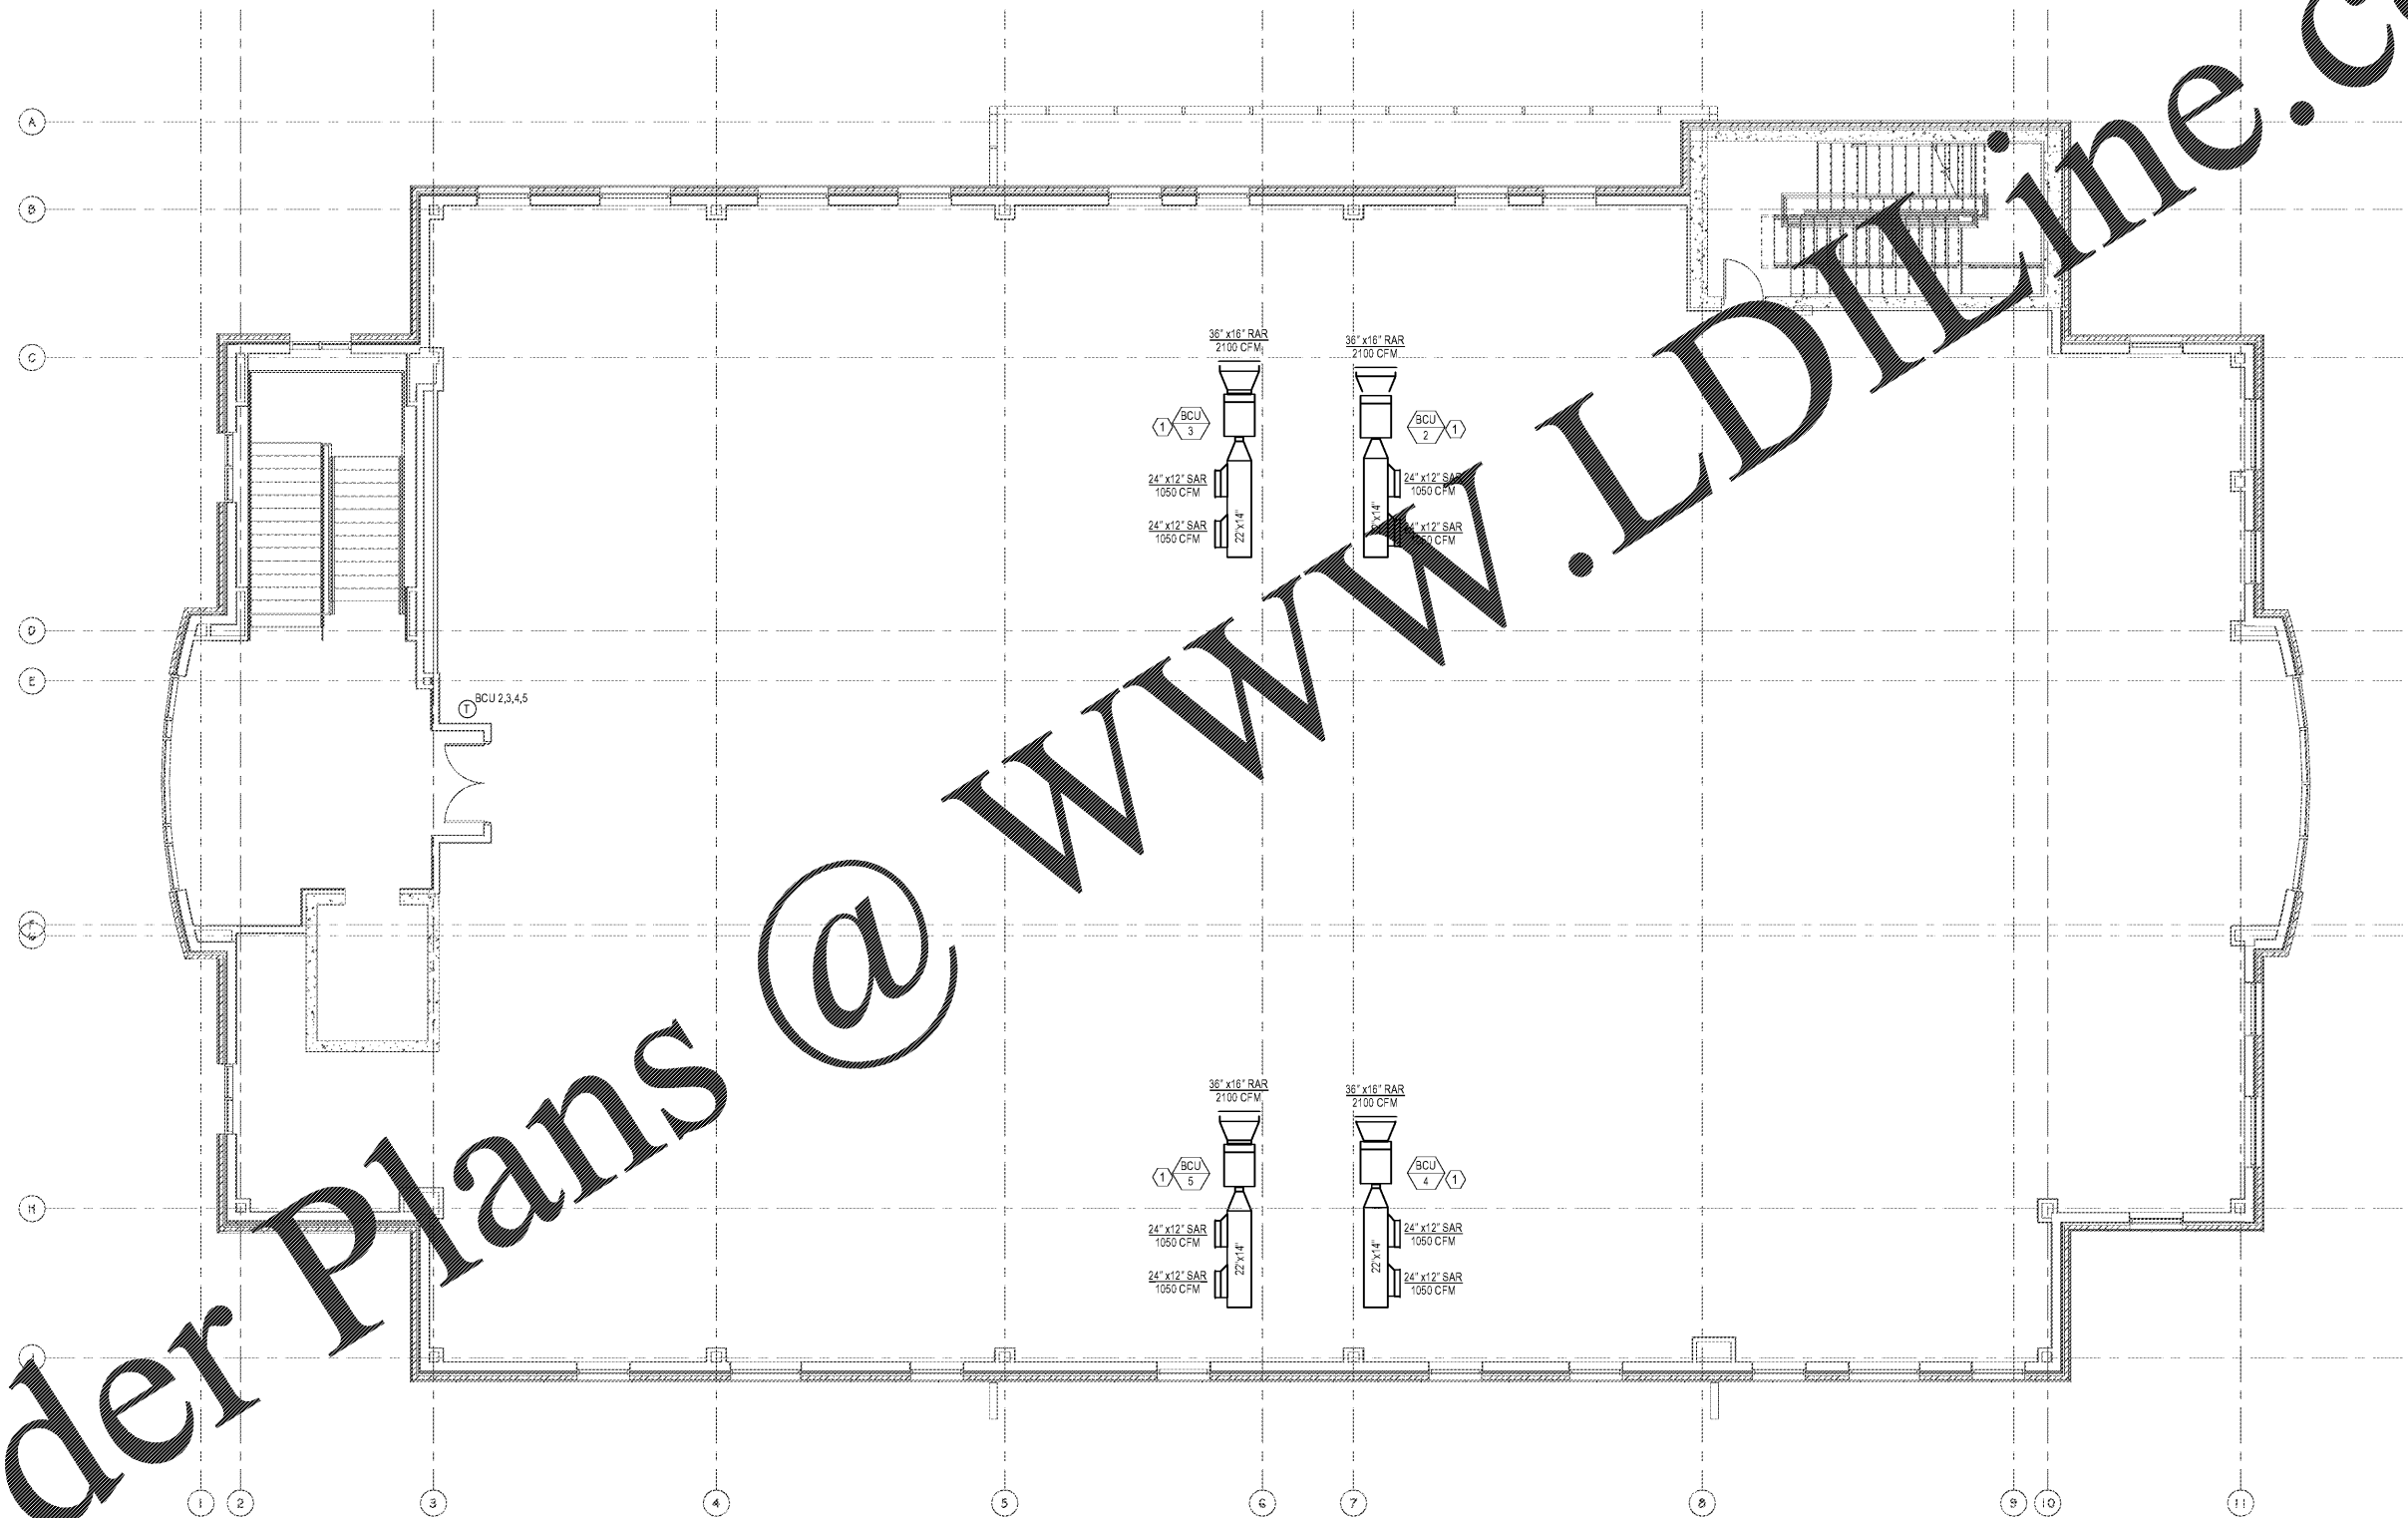

 1 LEVEL 3 - MECHANICAL PLAN
 3/16" = 1'-0"



ISSUE DATE	ISSUE FOR
2016.05.25	BID

SIMULATION LABORATORY
 BUILDING - USA JOB #16-07
 MOBILE, ALABAMA
 ABC #2017372
 GMC # AMOB160019



LEVEL 3 MECHANICAL
 PLAN

M1.03
 sheet of

Order Plans @ WWW.LDITLINE.COM