


5/21/2018 1:32:41 PM

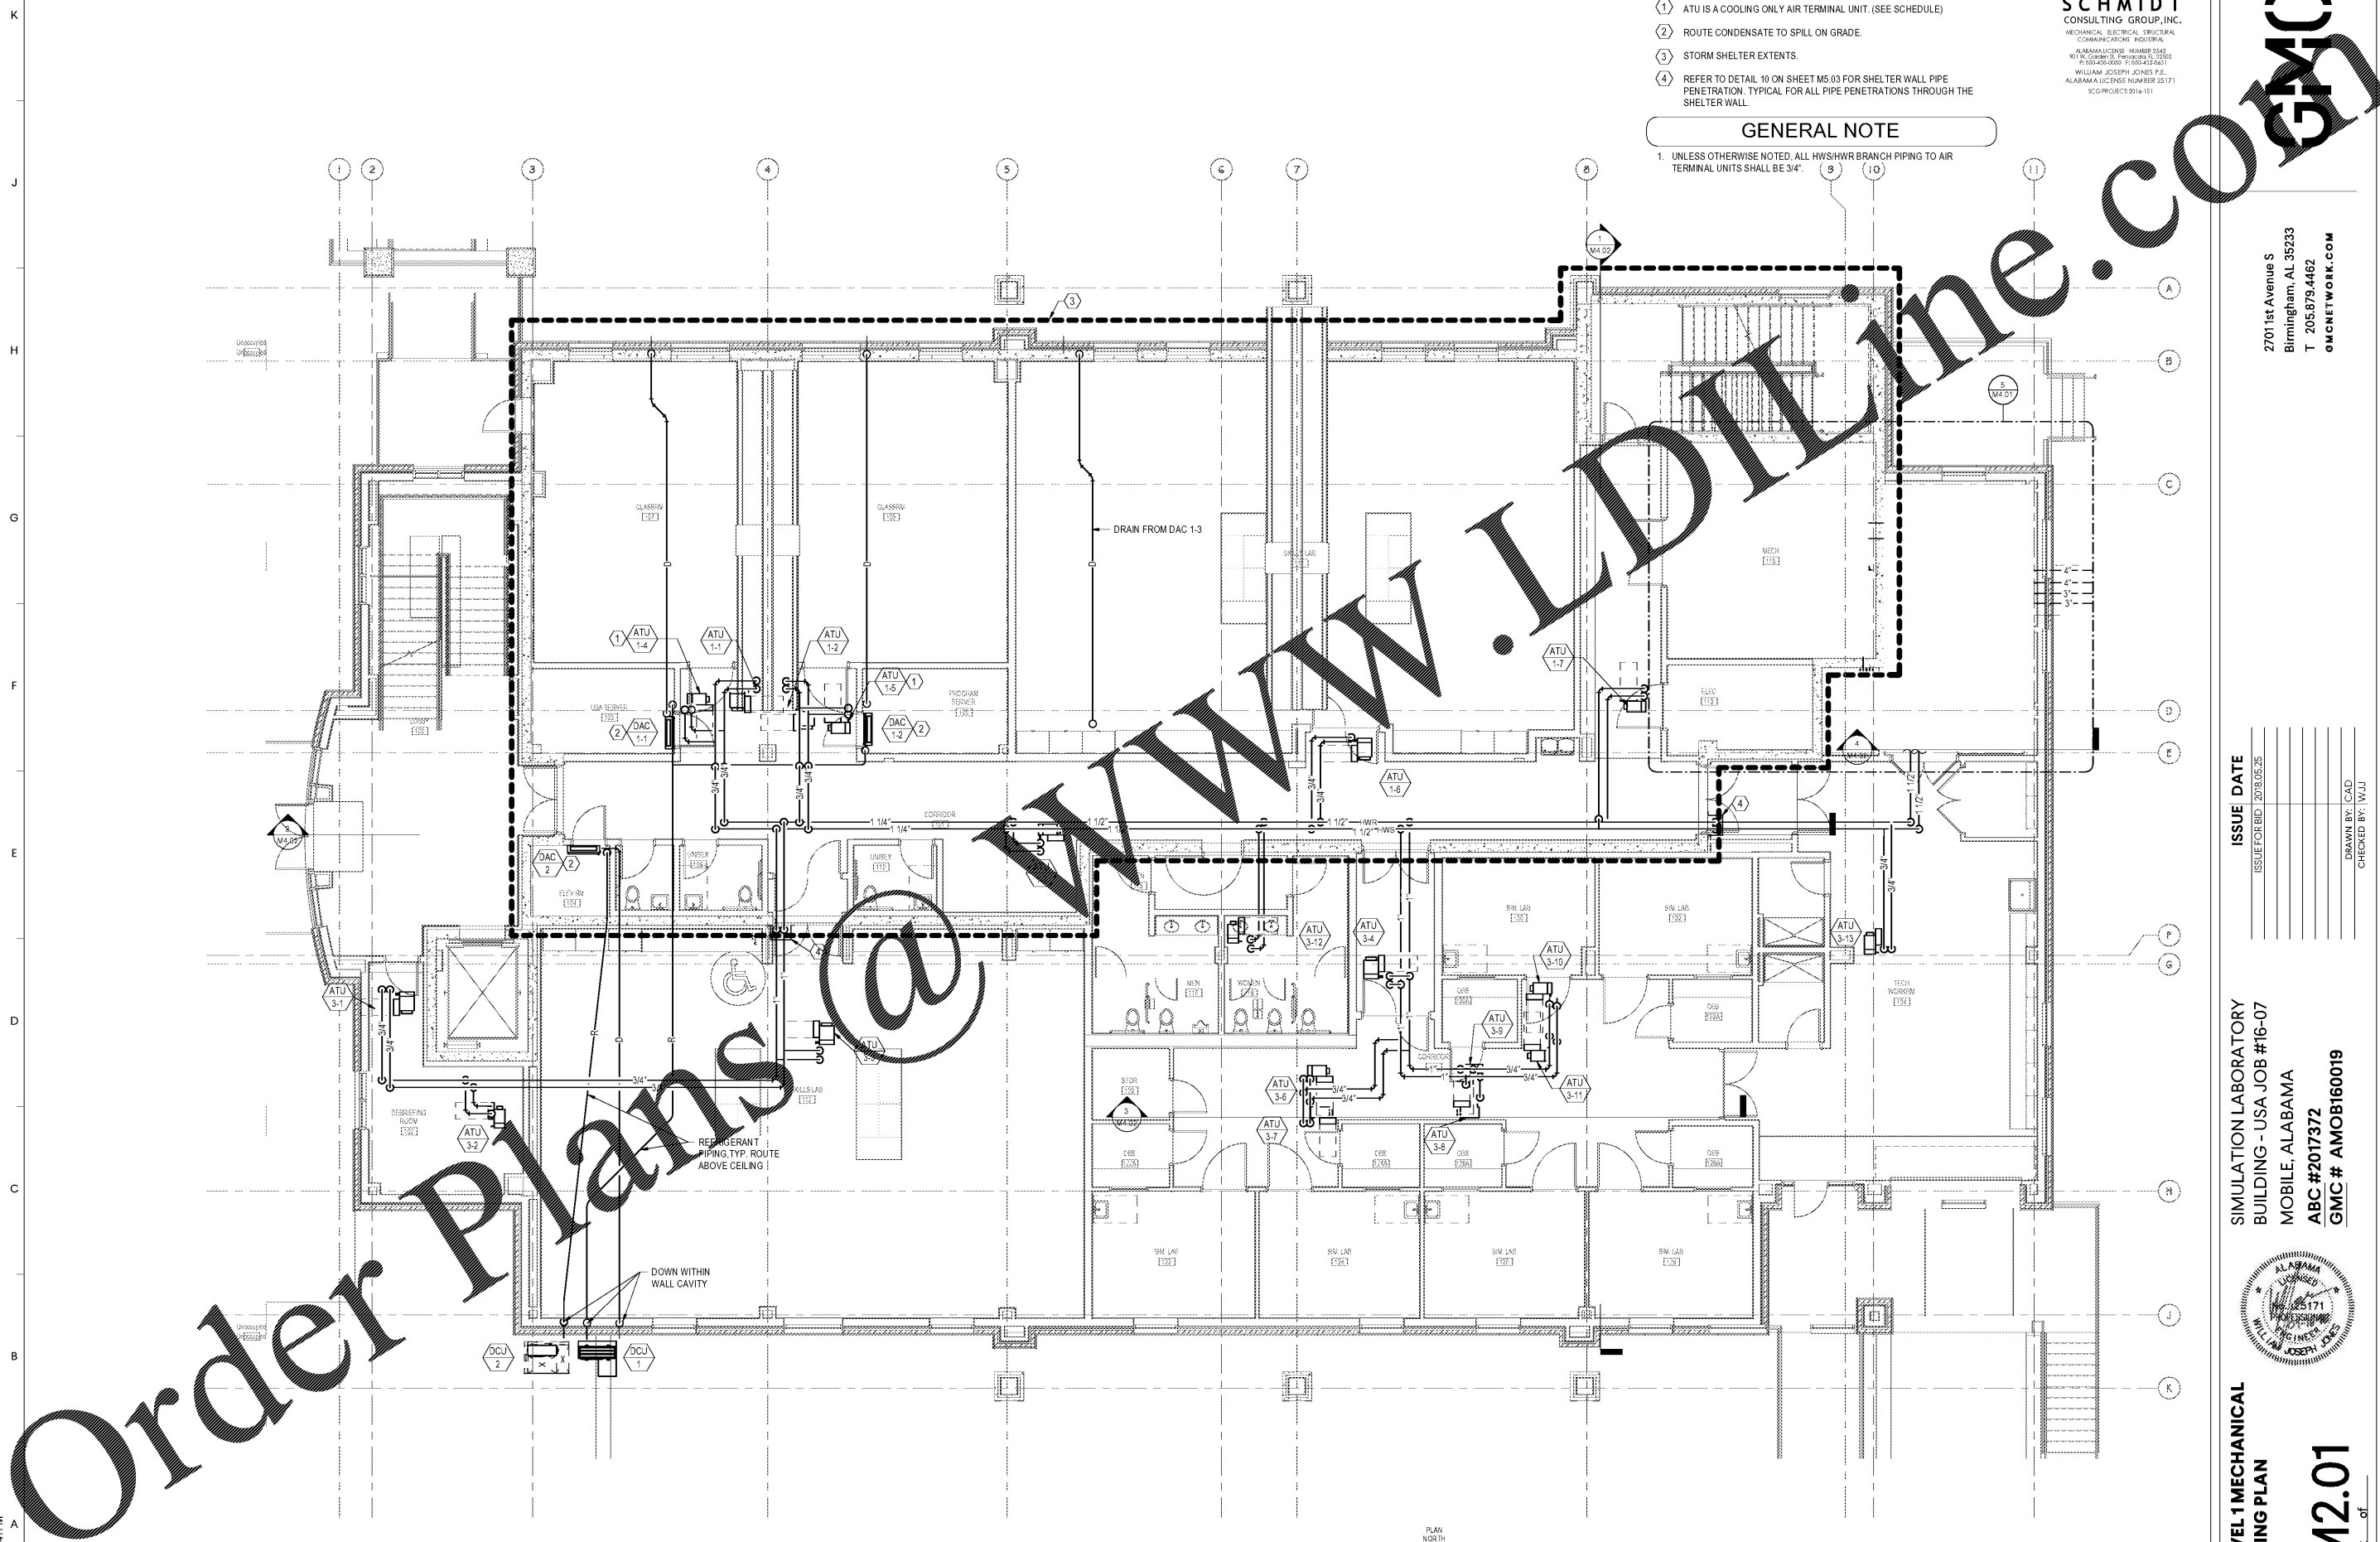

SHEET NOTES

- ① ATU IS A COOLING ONLY AIR TERMINAL UNIT. (SEE SCHEDULE)
- ② ROUTE CONDENSATE TO SPILL ON GRADE.
- ③ STORM SHELTER EXTENTS.
- ④ REFER TO DETAIL 10 ON SHEET M5.03 FOR SHELTER WALL PIPE PENETRATION. TYPICAL FOR ALL PIPE PENETRATIONS THROUGH THE SHELTER WALL.

GENERAL NOTE

1. UNLESS OTHERWISE NOTED, ALL HWS/HWR BRANCH PIPING TO AIR TERMINAL UNITS SHALL BE 3/4".

SCHMIDT
CONSULTING GROUP, INC.
MECHANICAL, ELECTRICAL, STRUCTURAL,
COMMUNICATIONS, INDUSTRIAL
ALABAMA LICENSE NUMBER 25171
WILLIAM JOSEPH JONES, P.E.
ALABAMA LICENSE NUMBER 25171
SC01 PROJECT 2016-151

GMC
www.LDOnline.com

2701 1st Avenue S
Birmingham, AL 35233
T 205.879.4462
omcnetwork.com

ISSUE DATE	ISSUE FOR
2018.05.25	BID

SIMULATION LABORATORY
BUILDING - USA JOB #16-07
MOBILE, ALABAMA
ABC #2017372
GMC # AMOB160019



**LEVEL 1 MECHANICAL
PIPING PLAN**

M2.01
Sheet of



PLAN NORTH
1 LEVEL 1 - MECHANICAL PIPING PLAN
3/16" = 1'-0"

