

SHEET NOTES

- ① ROUTE 1-1/4" CHWS/CHWR AND 3/4" HWS/HWR TO EACH BCU.
- ② ROUTE CONDENSATE WITHIN EXTERIOR WALL TO ROOF DRAIN IN LOWER ROOF.

SCHMIDT
CONSULTING GROUP, INC.
MECHANICAL ELECTRICAL STRUCTURAL
COMMUNICATIONS INDUSTRIAL
ALABAMA LICENSE NUMBER 25171
WILLIAM JOSEPH JONES P.E.
ALABAMA LICENSE NUMBER 25171
SCG PROJECT 2016-151

2701 1st Avenue S
Birmingham, AL 35233
T 205.879.4462
GMCNETWORK.COM

ISSUE DATE	ISSUE FOR BID
	2016.05.25


DRAWN BY: CAD
CHECKED BY: WJW

SIMULATION LABORATORY
BUILDING - USA JOB #16-07
MOBILE, ALABAMA
ABC #2017372
GMC # AMOB160019



**LEVEL 3 MECHANICAL
PIPING PLAN**

M2.03
Sheet of

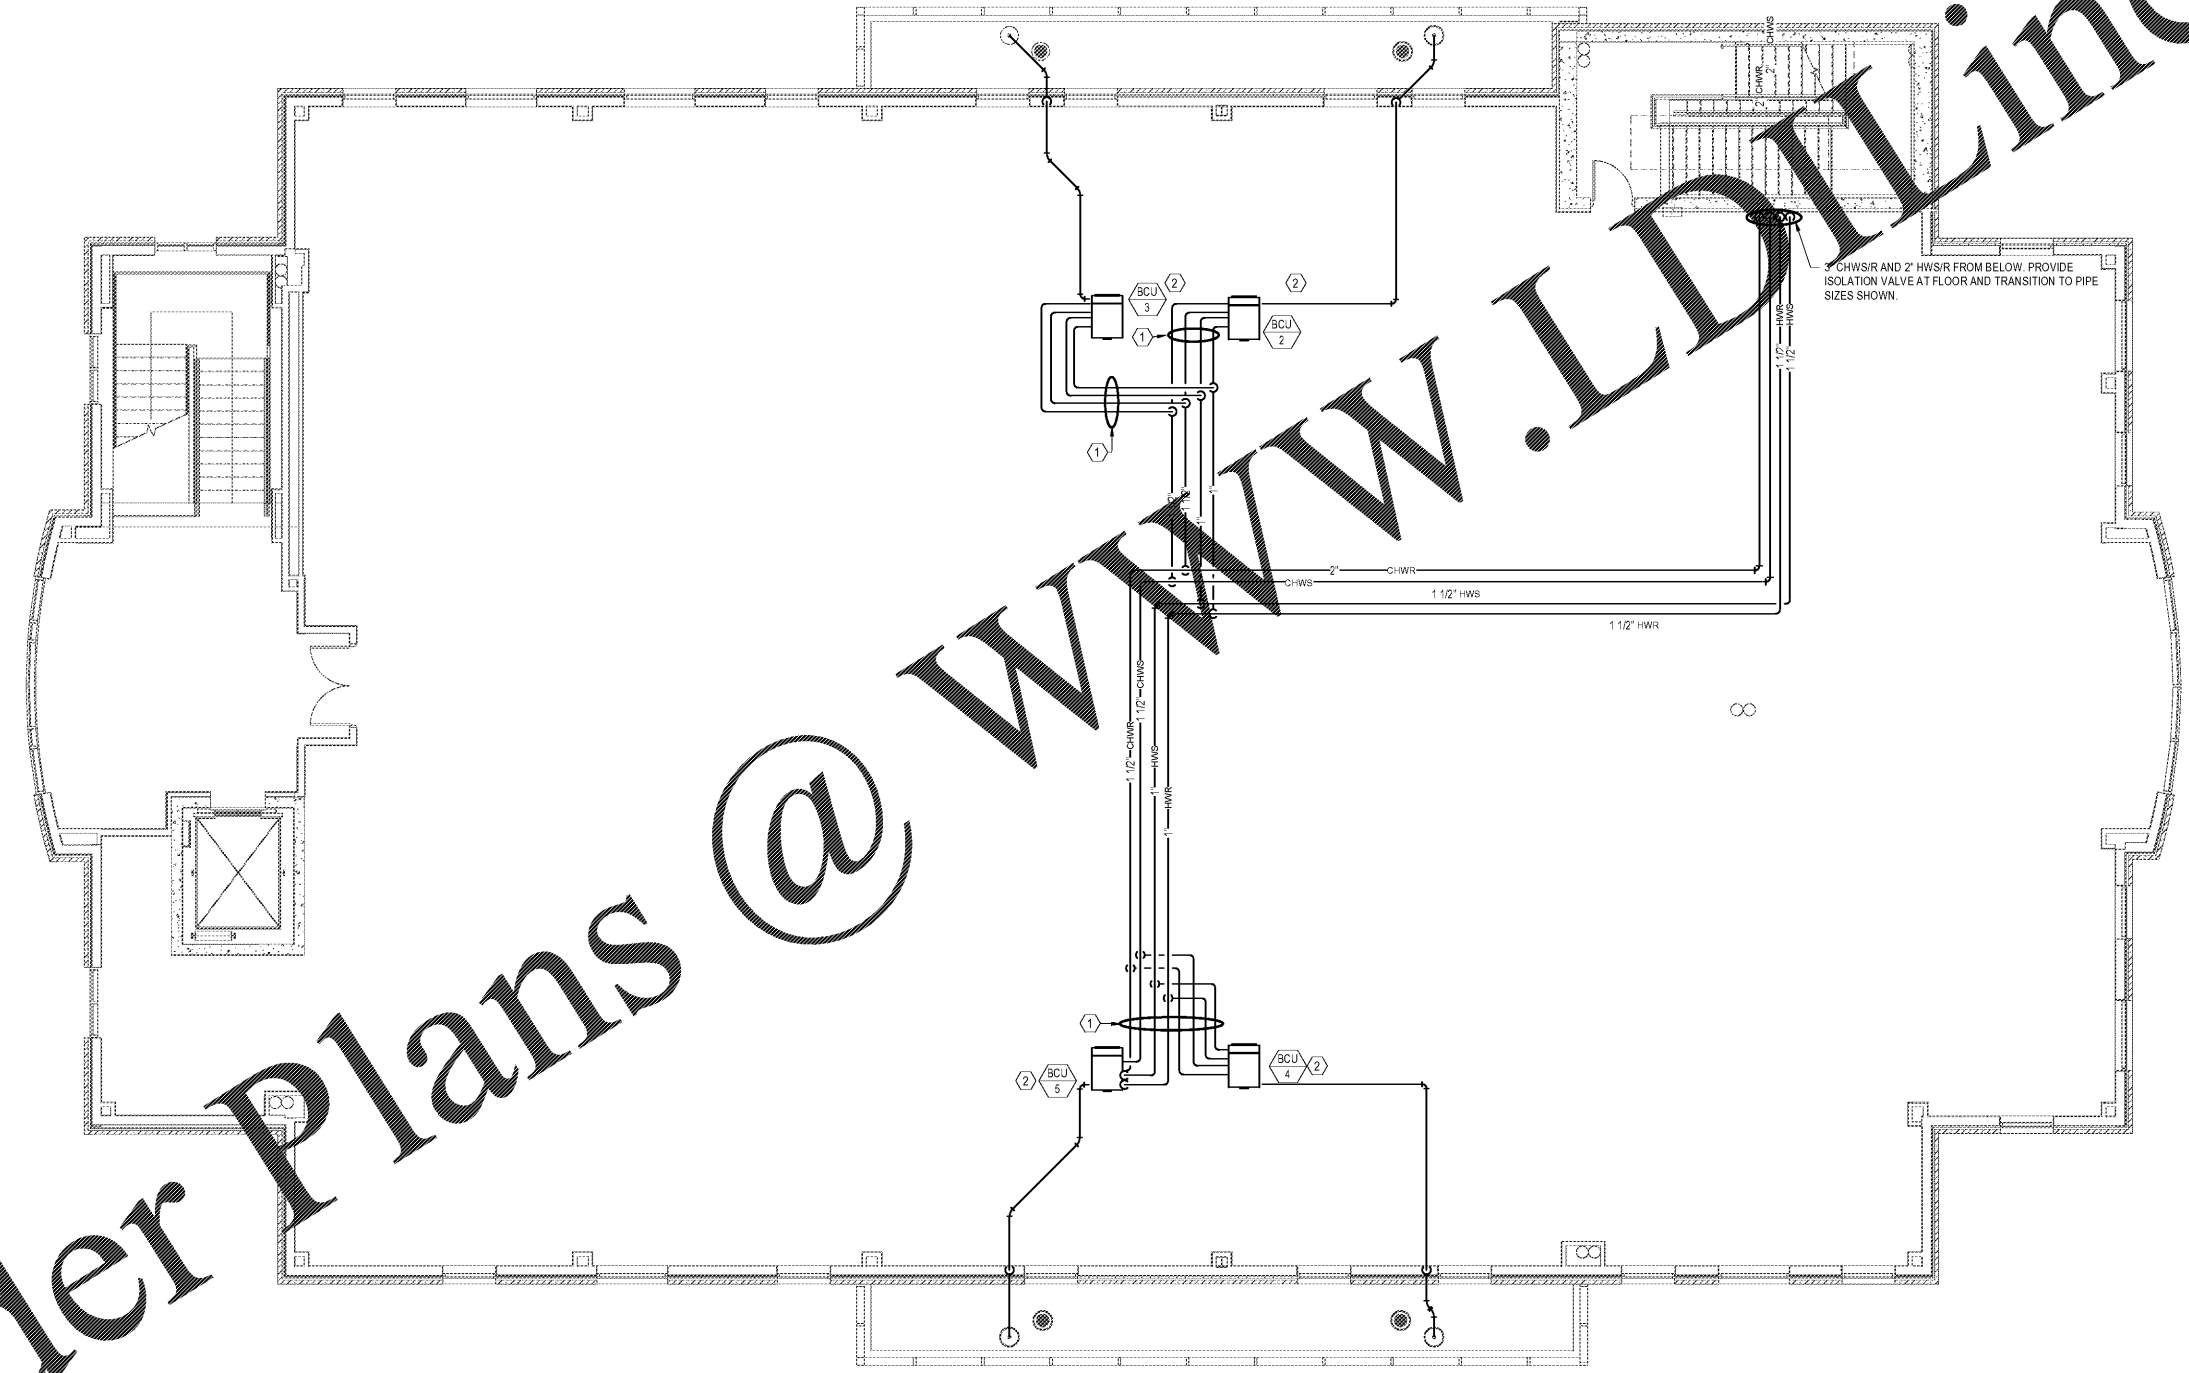


3\"/>



1 LEVEL 3 - MECHANICAL PIPING PLAN

 3/16" = 1'-0"



5/21/2016 13:24:46 PM

K
J
H
G
F
E
D
C
B
A

K
J
H
G
F
E
D
C
B
A

Order Plans @ WWW.LDLine.com