


5/21/2018 12:06:34 PM

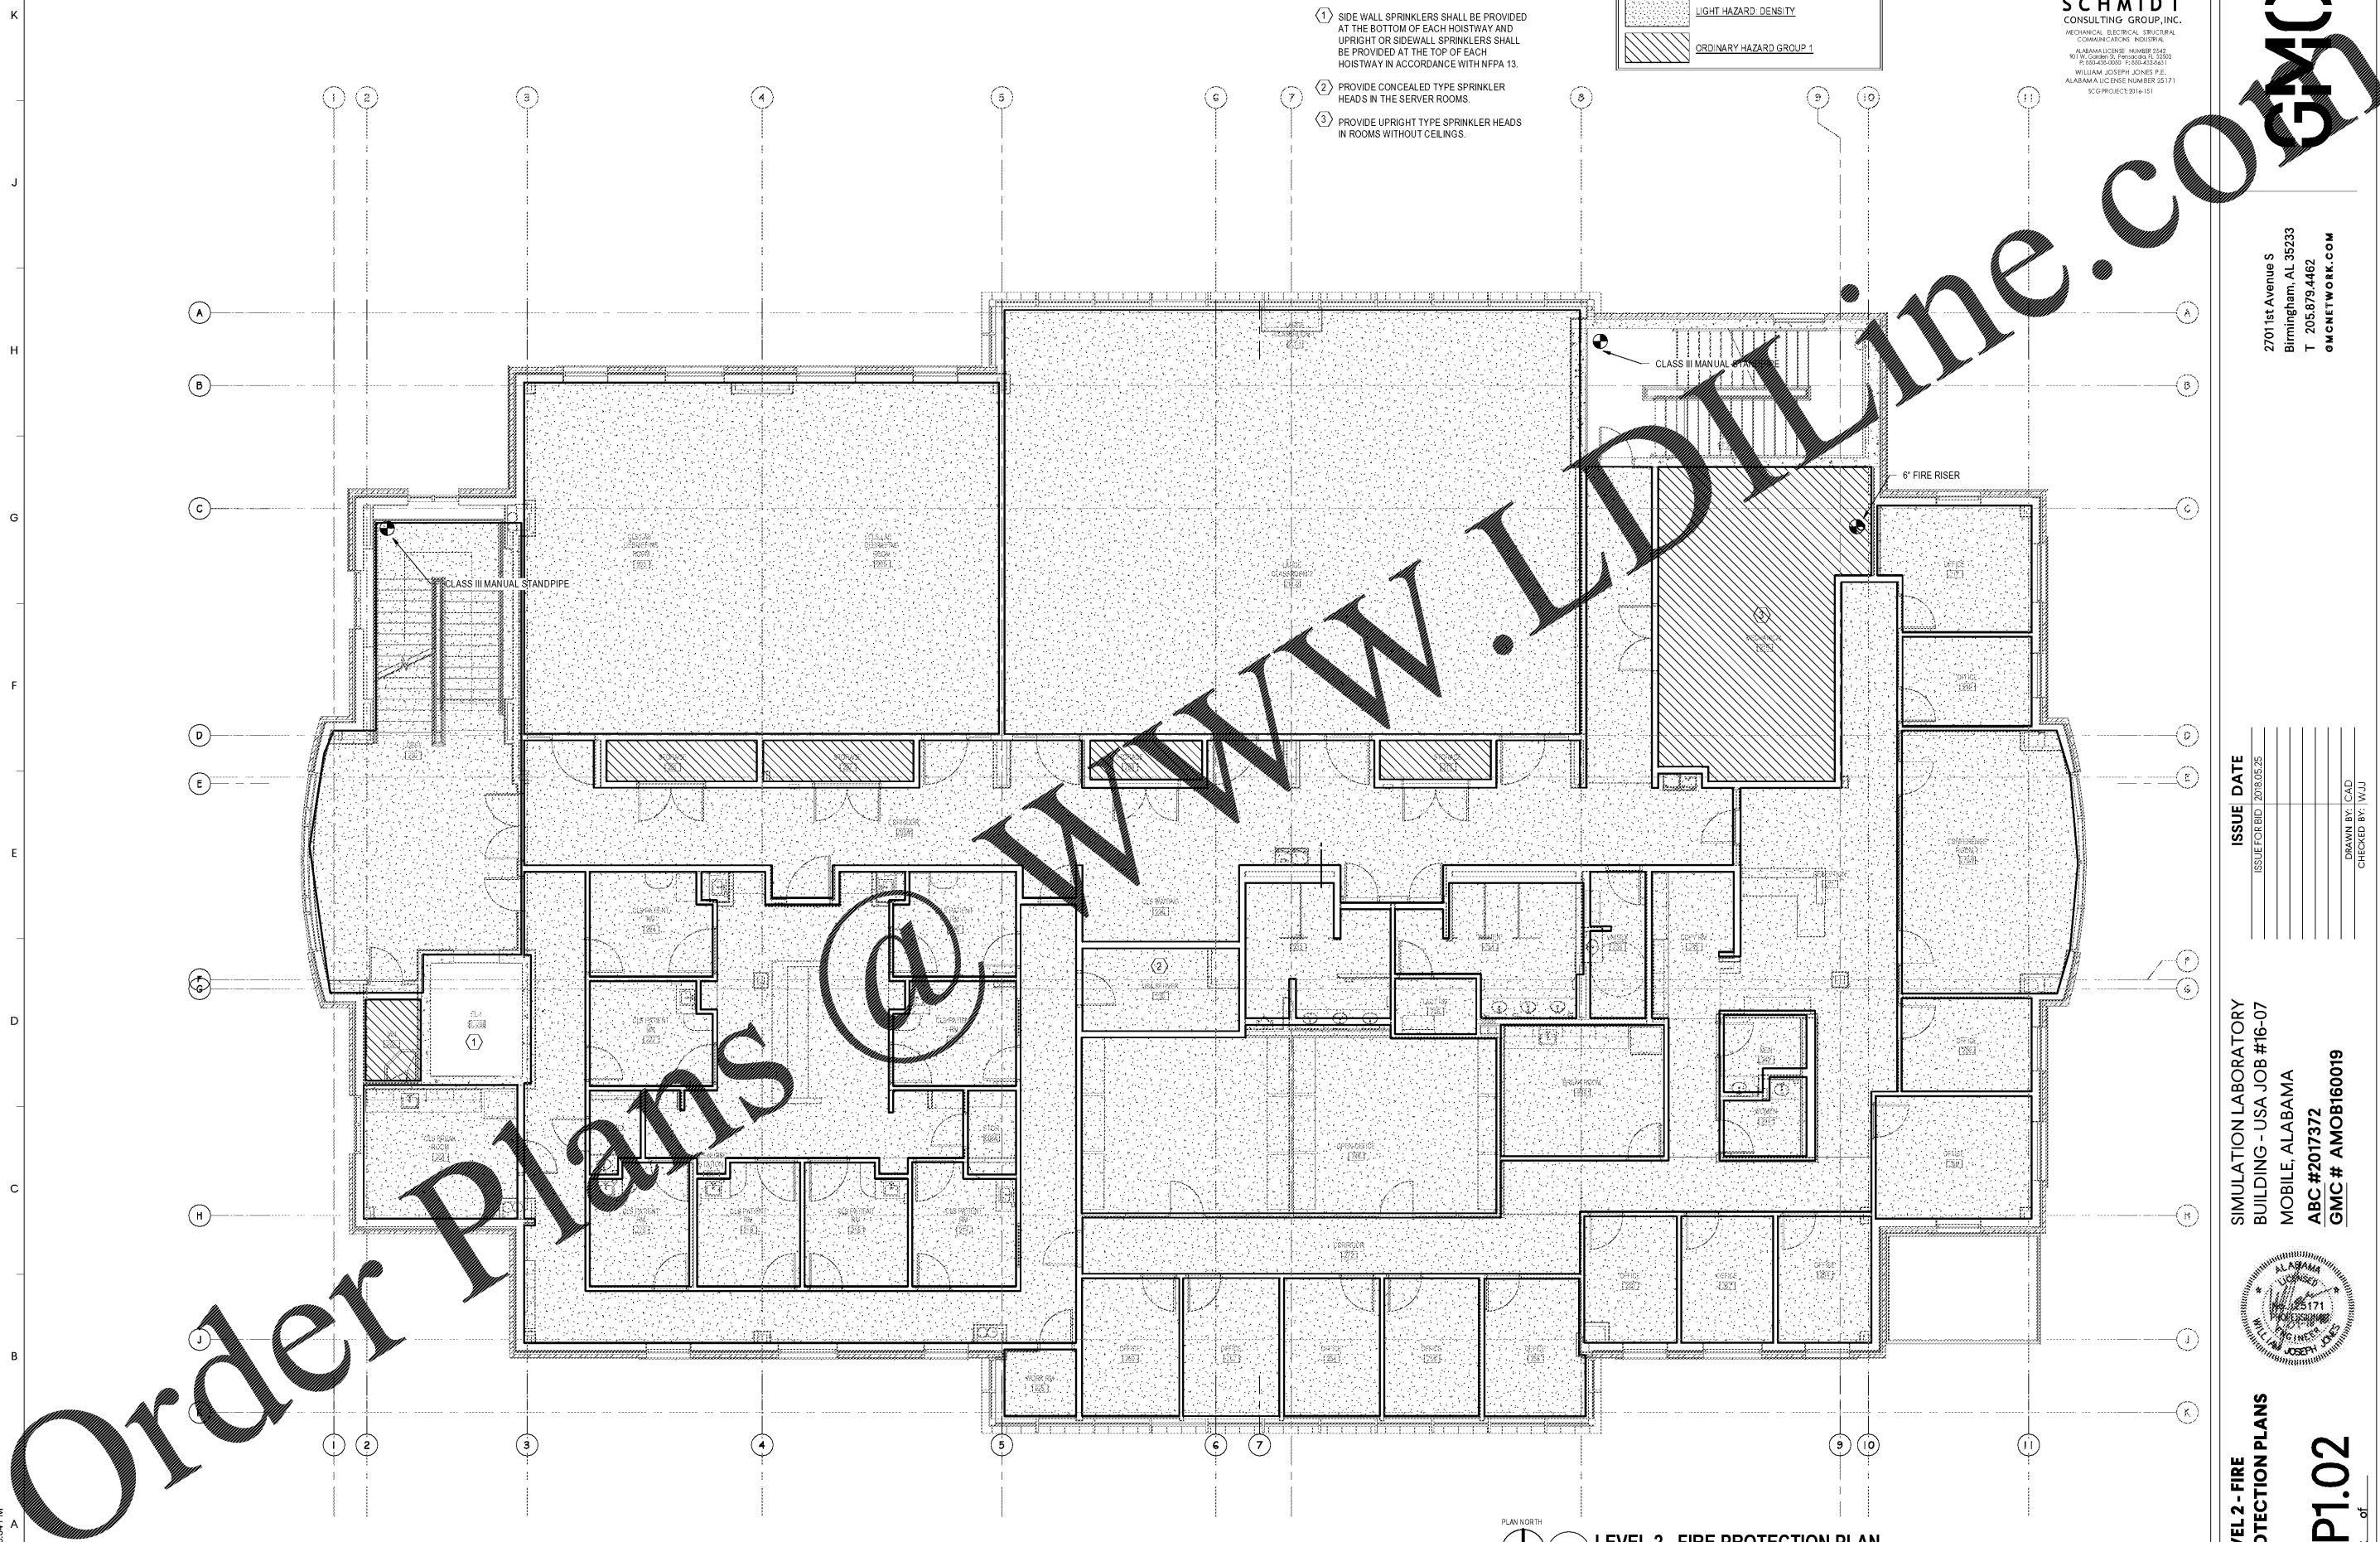

SHEET NOTES

- ① SIDE WALL SPRINKLERS SHALL BE PROVIDED AT THE BOTTOM OF EACH HOISTWAY AND UPRIGHT OR SIDEWALL SPRINKLERS SHALL BE PROVIDED AT THE TOP OF EACH HOISTWAY IN ACCORDANCE WITH NFPA 13.
- ② PROVIDE CONCEALED TYPE SPRINKLER HEADS IN THE SERVER ROOMS.
- ③ PROVIDE UPRIGHT TYPE SPRINKLER HEADS IN ROOMS WITHOUT CEILINGS.

HATCH LEGEND	
	LIGHT HAZARD DENSITY
	ORDINARY HAZARD GROUP 1

SCHMIDT
CONSULTING GROUP, INC.
MECHANICAL, ELECTRICAL, STRUCTURAL,
COMMUNICATIONS, INDUSTRIAL
ALABAMA LICENSE NUMBER 25171
WILLIAM JOSEPH JONES, P.E.
ALABAMA LICENSE NUMBER 25171
SC01 PROJECT 2016-151

2701 1st Avenue S
Birmingham, AL 35233
T 205.879.4462
ONCNETWORK.COM

ISSUE DATE	ISSUE FOR BID
	2018.05.25

 
DRAWN BY: CAD
CHECKED BY: WJL

SIMULATION LABORATORY
BUILDING - USA JOB #16-07
MOBILE, ALABAMA
ABC #2017372
GMC # AMOB160019



Order Plans @ www.lidonline.com

PLAN NORTH
1 LEVEL 2 - FIRE PROTECTION PLAN
SCALE: 3/16"=1'-0"



LEVEL 2 - FIRE PROTECTION PLANS

FP1.02
Sheet of