

SCHMIDT
CONSULTING GROUP, INC.
MECHANICAL ELECTRICAL STRUCTURAL
COMMERCIAL INDUSTRIAL
ALABAMA LICENSE NUMBER 2215
WETA COMPANY, P.E. PENNSYLVANIA LICENSE NUMBER 33259
P. 304-880-0000 F. 610-426-6471
TODD NICHOLSON, P.E.
ALABAMA LICENSE NUMBER 29943-E
SC10 PROJECT 2016-131

GMC
2701 1st Avenue S
Birmingham, AL 35233
T 205.879.4462
GMCNETWORK.COM

ISSUE	DATE
ISSUE FOR BID	2018.05.25


DRAWN BY: JTH
CHECKED BY: TAN

SIMULATION LABORATORY
BUILDING - USA JOB #16-07
MOBILE, ALABAMA
ABC #2017372
GMC # AMOB160019



**3RD FLOOR
MECHANICAL POWER
PLAN
E403**
Sheet 1 of 1

5/23/2018 8:01:43 AM

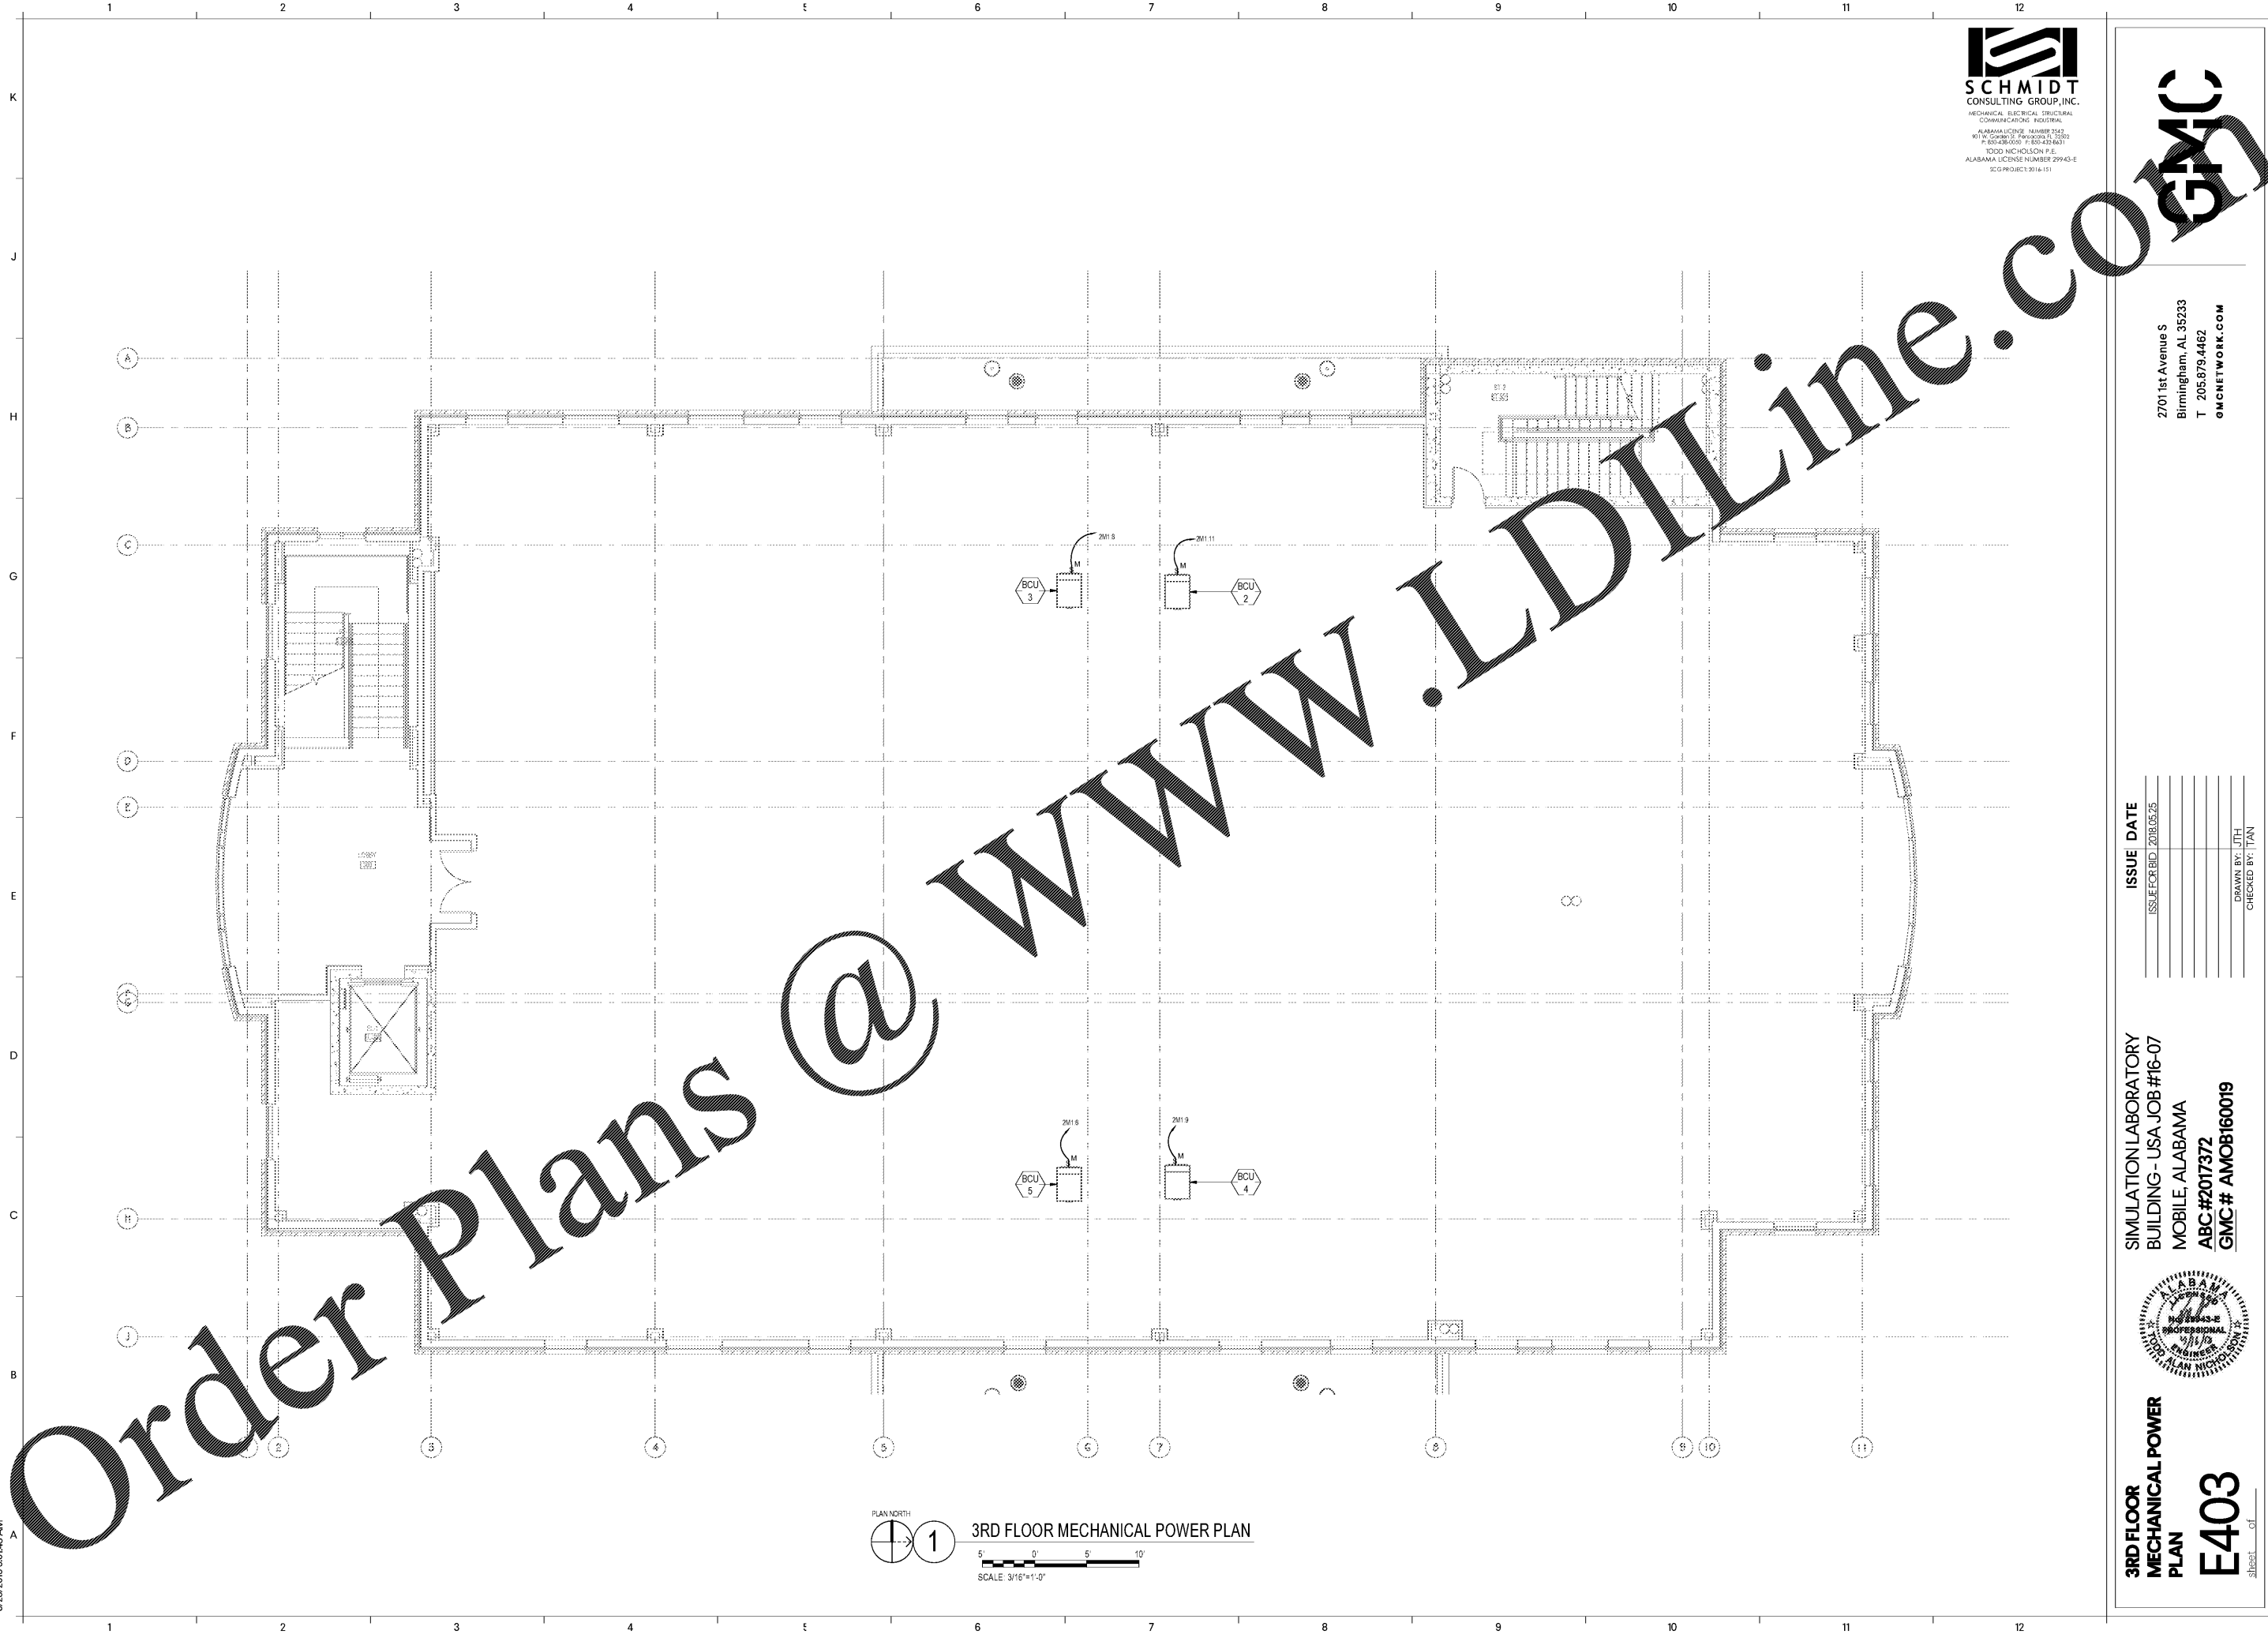

PLAN NORTH
1
3RD FLOOR MECHANICAL POWER PLAN
5' 0' 5' 10'
SCALE 3/16"=1'-0"

Order Plans @ www.LDITLine.com

www.LDITLine.com