

ISSUE DATE	ISSUE FOR BID
	2018.05.25

DRAWN BY: CEC  
CHECKED BY: TAN


SIMULATION LABORATORY  
BUILDING - USA JOB #16-07  
MOBILE, ALABAMA  
ABC #2017372  
GMC # AMOB160019



2ND FLOOR  
TELECOMMUNICATIONS  
PLAN

T202  
Sheet - of

5/23/2018 7:56:57 AM

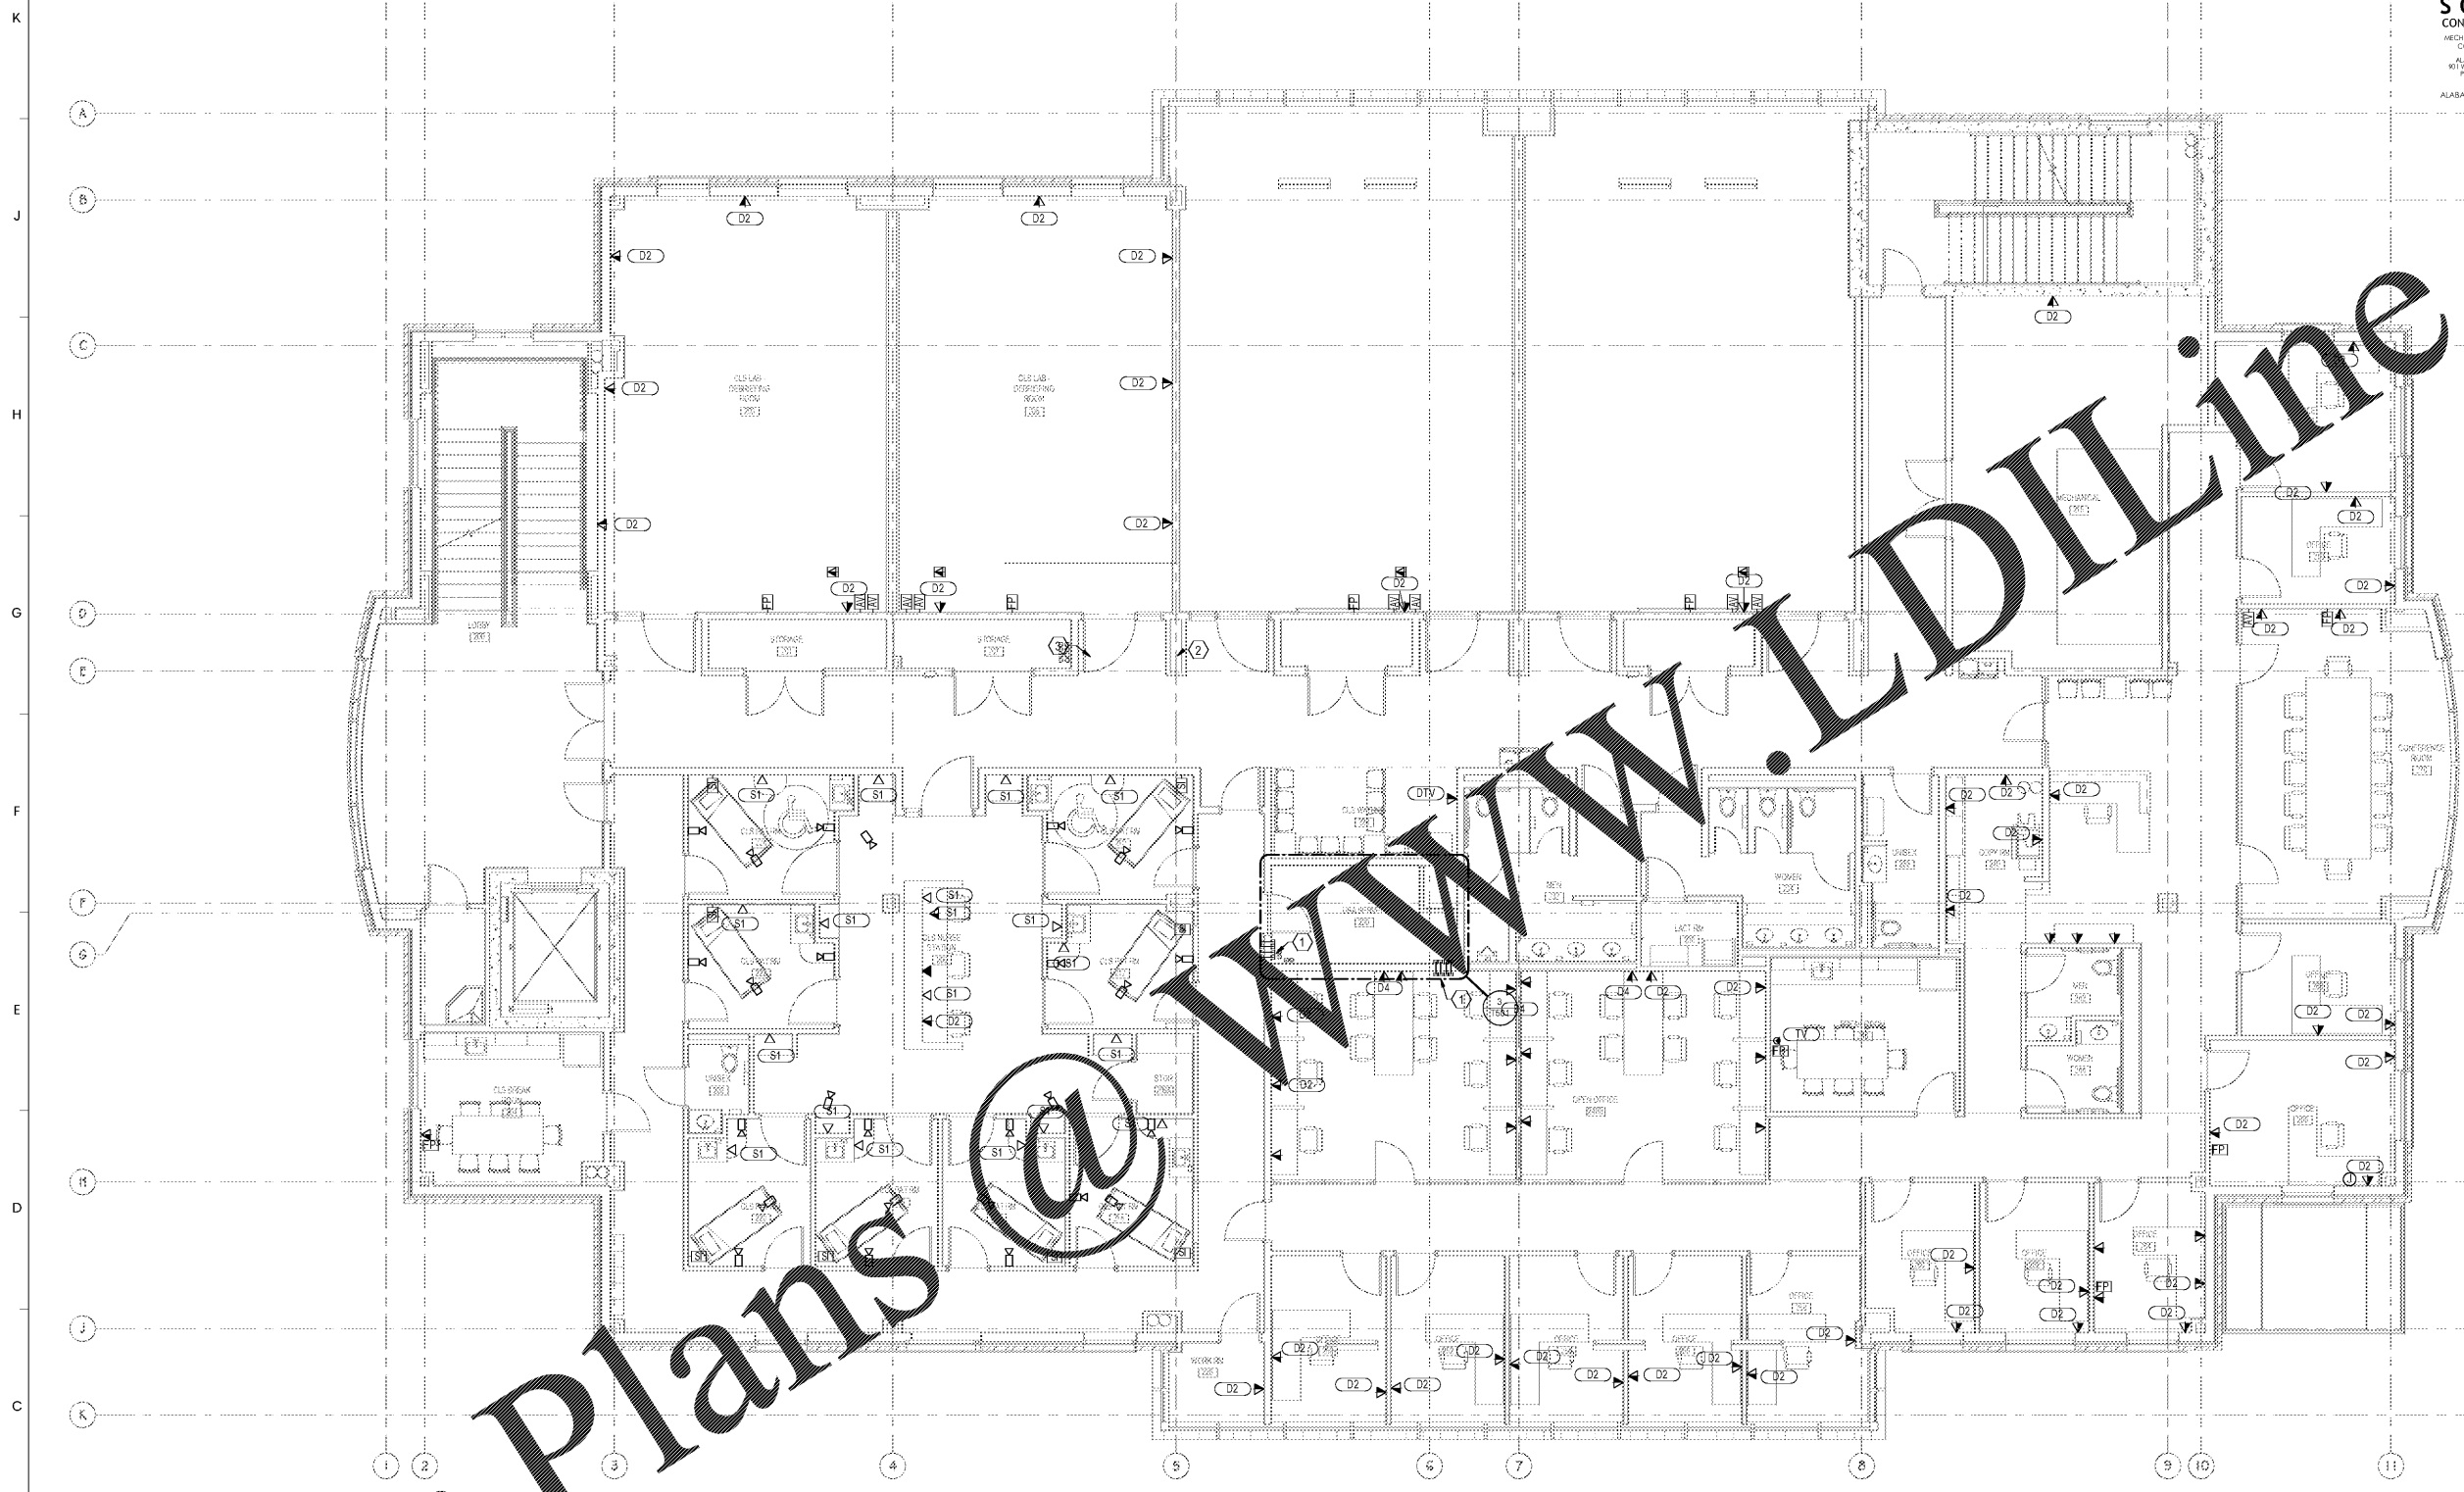

**Order Plans @**

FLOOR PLAN KEY NOTES

- ① (4) 4" MECHANICAL SLEEVES MOUNTED AT 9" AFF. SLEEVES PROVIDED BY G.C.
- ② (4) 4" CONDUITS SLEEVED FROM FLOOR ABOVE FOR 3RD FLOOR HORIZONTAL CABLING. SLEEVES PROVIDED BY G.C.
- ③ (4) 4" CONDUITS SLEEVED FROM FLOOR BELOW FOR 2ND FLOOR HORIZONTAL CABLING. SLEEVES PROVIDED BY G.C.

1 2ND FLOOR TELECOMMUNICATIONS PLAN  
SCALE 3/16"=1'-0"