

**ADD. ALT. NO. 9
 DOWNSPOUT BOOTS AND ROOF DRAINAGE PIPING IS PART OF ADD. ALT. NO. 9.
 BASE BID IS PLASTIC SPLASHBLOCK DISCHARGING ON GRADE.**



SMITH DESIGN GROUP, INC.
 20 WEST HUNTERSTON STREET
 LAGRANGE, GEORGIA 30240
 706-882-5511 www.SDGarch.net

- KEYNOTES**
- ① ROOF DRAIN SEE DETAIL 7/A6-3.
 - ② 3" CAST IRON ROOF DRAIN, FULLY INSULATED.
 - ③ 3" DIAMETER METAL DOWNSPOUT, DISCHARGE AT GRADE.
 - ④ DOWNSPOUT BOOTS SEE DETAIL 6/A6-2 PART OF ADD. ALT. NO. 10
 - ⑤ VENT THROUGH ROOF SEE PLUMBING DRAWINGS.
 - ⑥ GAS FLUE THROUGH ROOF SEE MECHANICAL DRAWINGS.

LEGEND
 — RD — 10" PVC ROOF DRAIN


REVISIONS

DATE	DESCRIPTION

PROJECT:
VERNON ROAD FIRE STATION
 VERNON ROAD
 LAGRANGE GEORGIA

TITLE:
ROOF PLAN

MODIFIED DATE:	JOB NO: 1731
ISSUED DATE: FOR BID AND PERMIT 07 MAY 2018	SHEET: A6-1

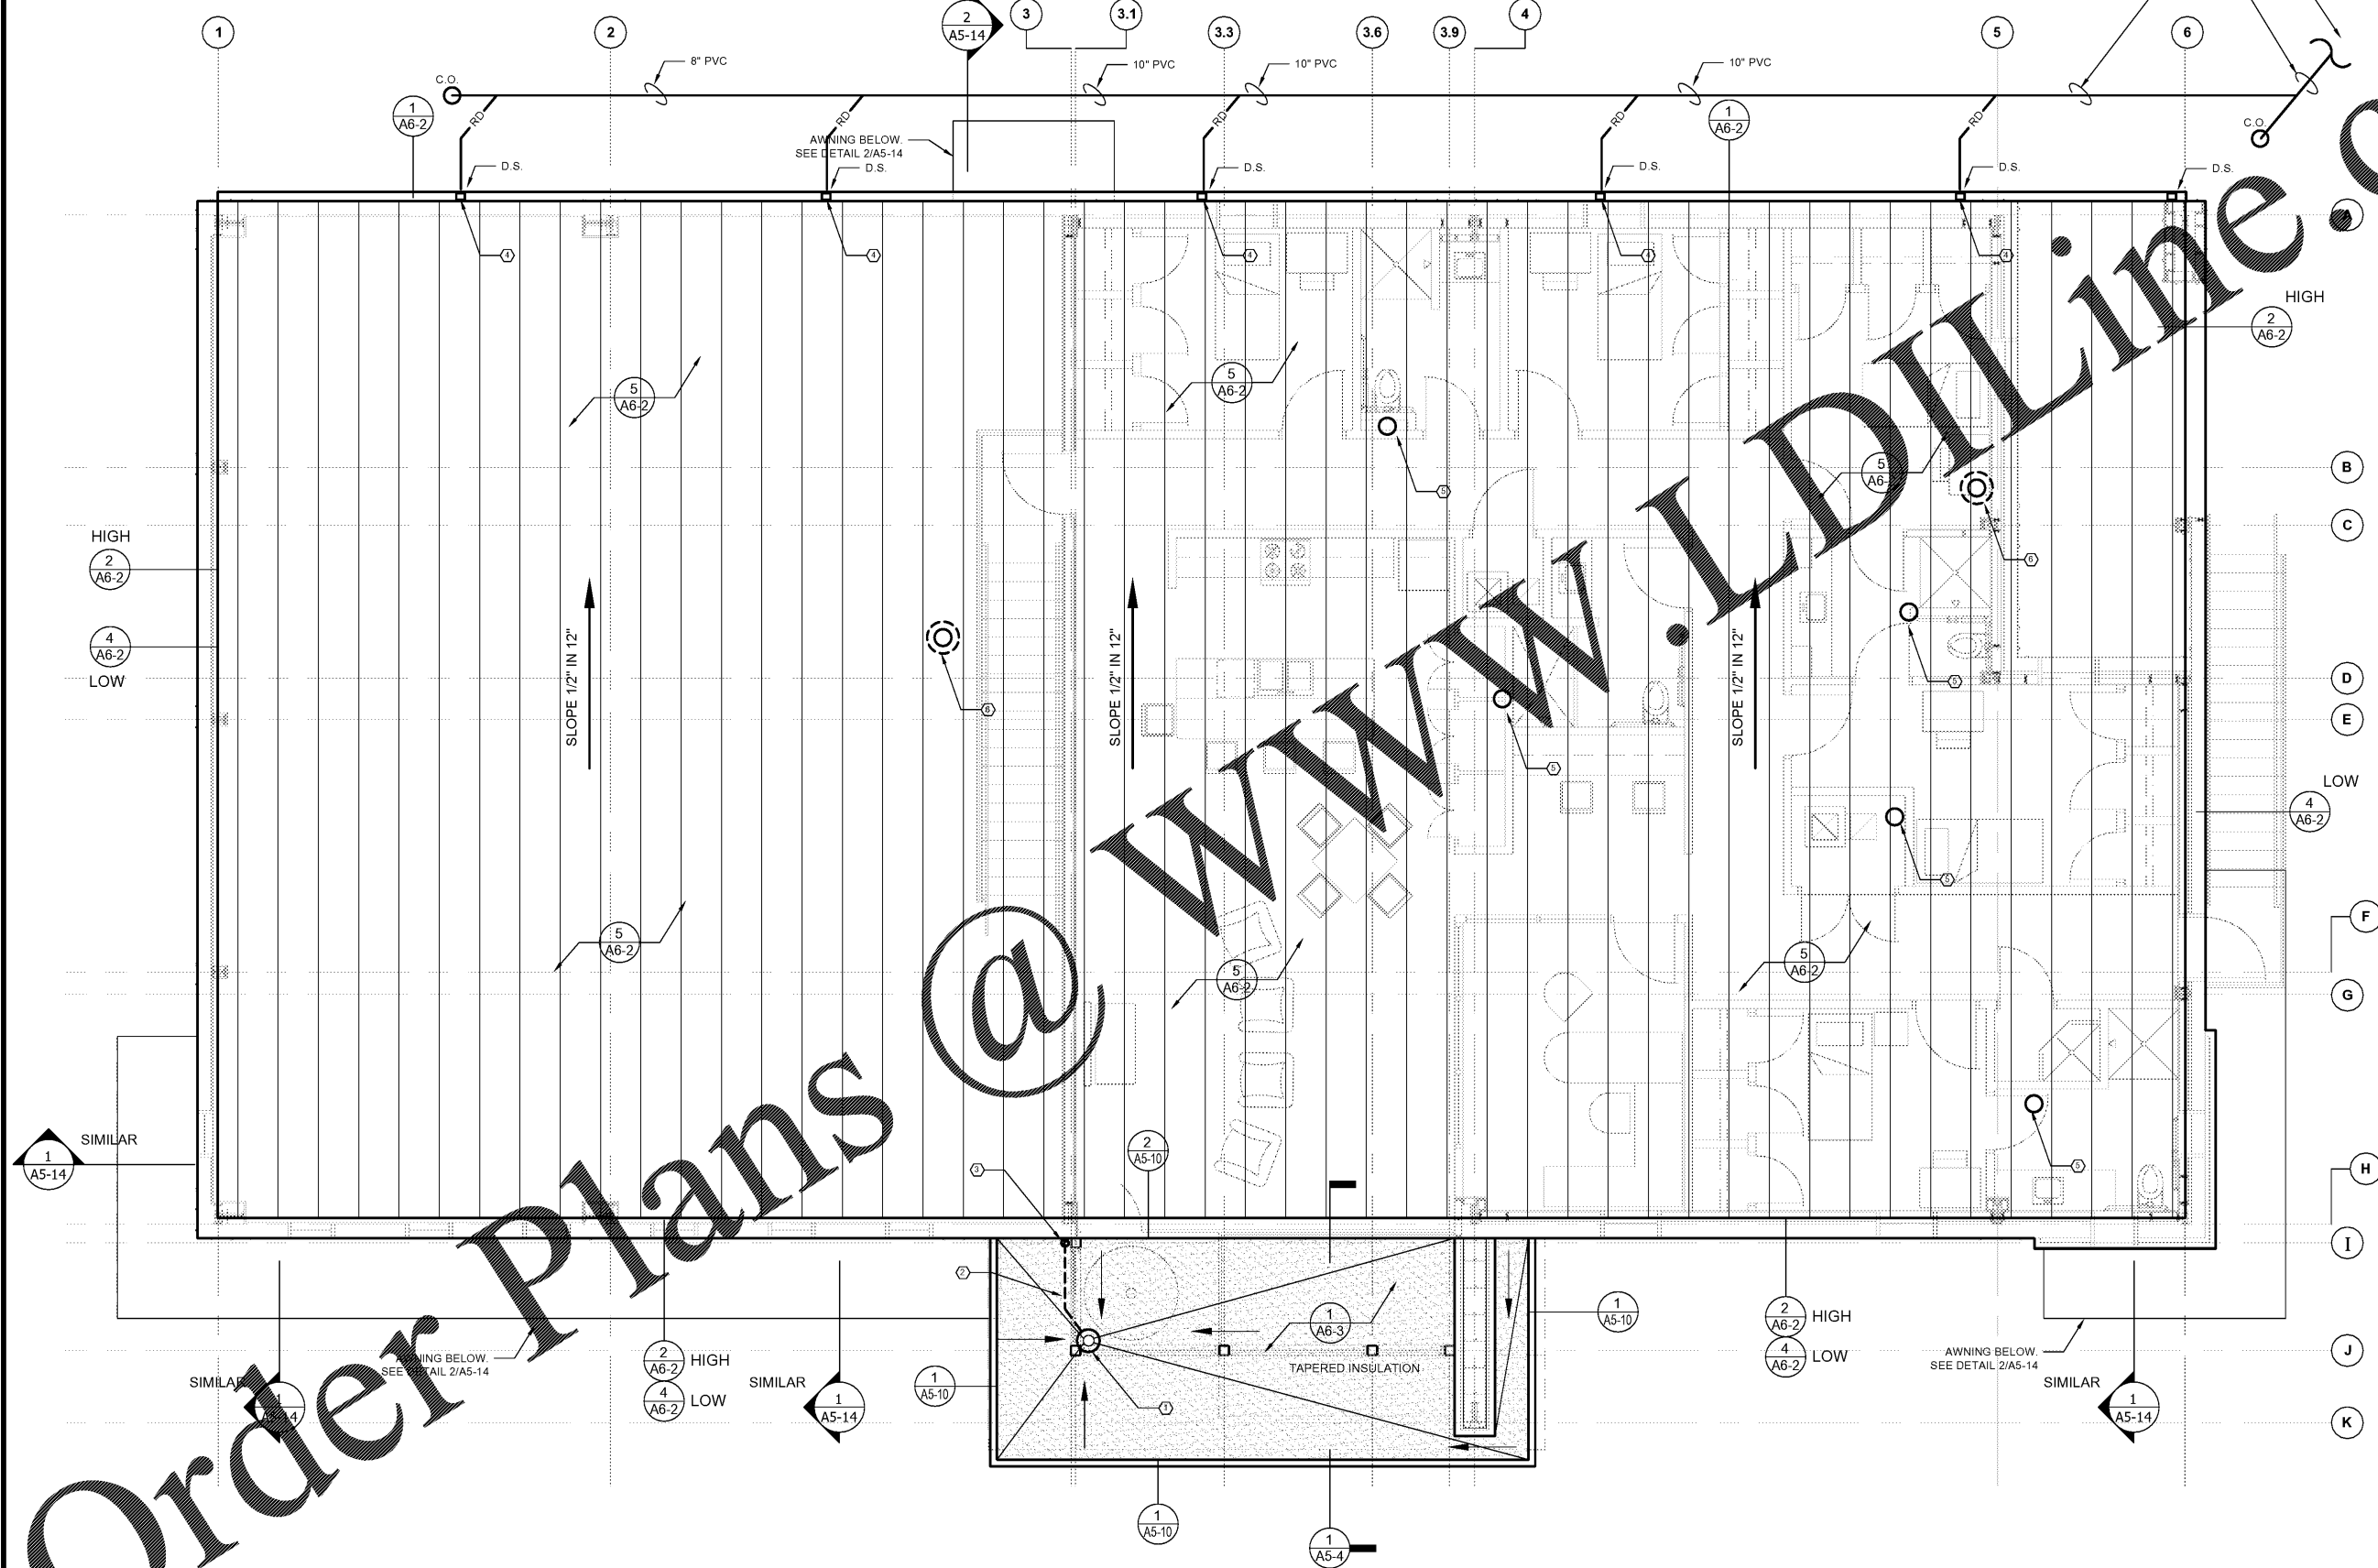

1 ROOF PLAN
 SCALE: 1/4" = 1'-0"

Order Plans @

www.LDOnline.com