

KEYNOTES
 ① 12" WATER RESISTANT GYPSUM BOARD CEILING ON 2X6S @ 16" O.C.

ARCHITECT'S STAMP
 STATE OF GEORGIA
 GEORGINA SMITH
 7575
 REGISTERED ARCHITECT
 SIGNATURE REQUIRED
 SMITH DESIGN GROUP, INC.
 20 WEST JACKSON STREET
 LAGRANGE, GEORGIA 30240
 706-882-5511 www.SDGarch.net

LEGEND

- CEILING FAN LIGHT COMBO
- DECORATIVE PENDANT HUNG FIXTURE
- WALL MOUNTED DECORATIVE LIGHT
- 2X4 LED LAY-IN FIXTURE
- 2X2 LED LAY-IN FIXTURE
- 1X4 LED CEILING MOUNTED FIXTURE
-
- WALL SCONCE EACH SIDE OF MIRROR MOUNT AT 5'-6" A.F.F., SEE INTERIOR ELEVATIONS
-
-
-
-
- 2X2' LAY-IN CEILING AND GRID
- FLUSH MOUNTED SPEAKER (CEILING MOUNT) SEE REFLECTED CEILING PLAN.
- RATED WALL - EXTEND TIGHT AGAINST FLOOR OR ROOF DECK ABOVE. SEAL ALL PENETRATIONS.


REVISIONS

DATE	DESCRIPTION


PROJECT:
 VERNON ROAD FIRE STATION
 VERNON ROAD
 LAGRANGE GEORGIA

TITLE:
 SECOND FLOOR PLAN
 REFLECTED CEILING PLAN

MODIFIED DATE:	JOB NO: 1731
ISSUED DATE: FOR BID AND PERMIT 07 MAY 2018	SHEET: RC-2

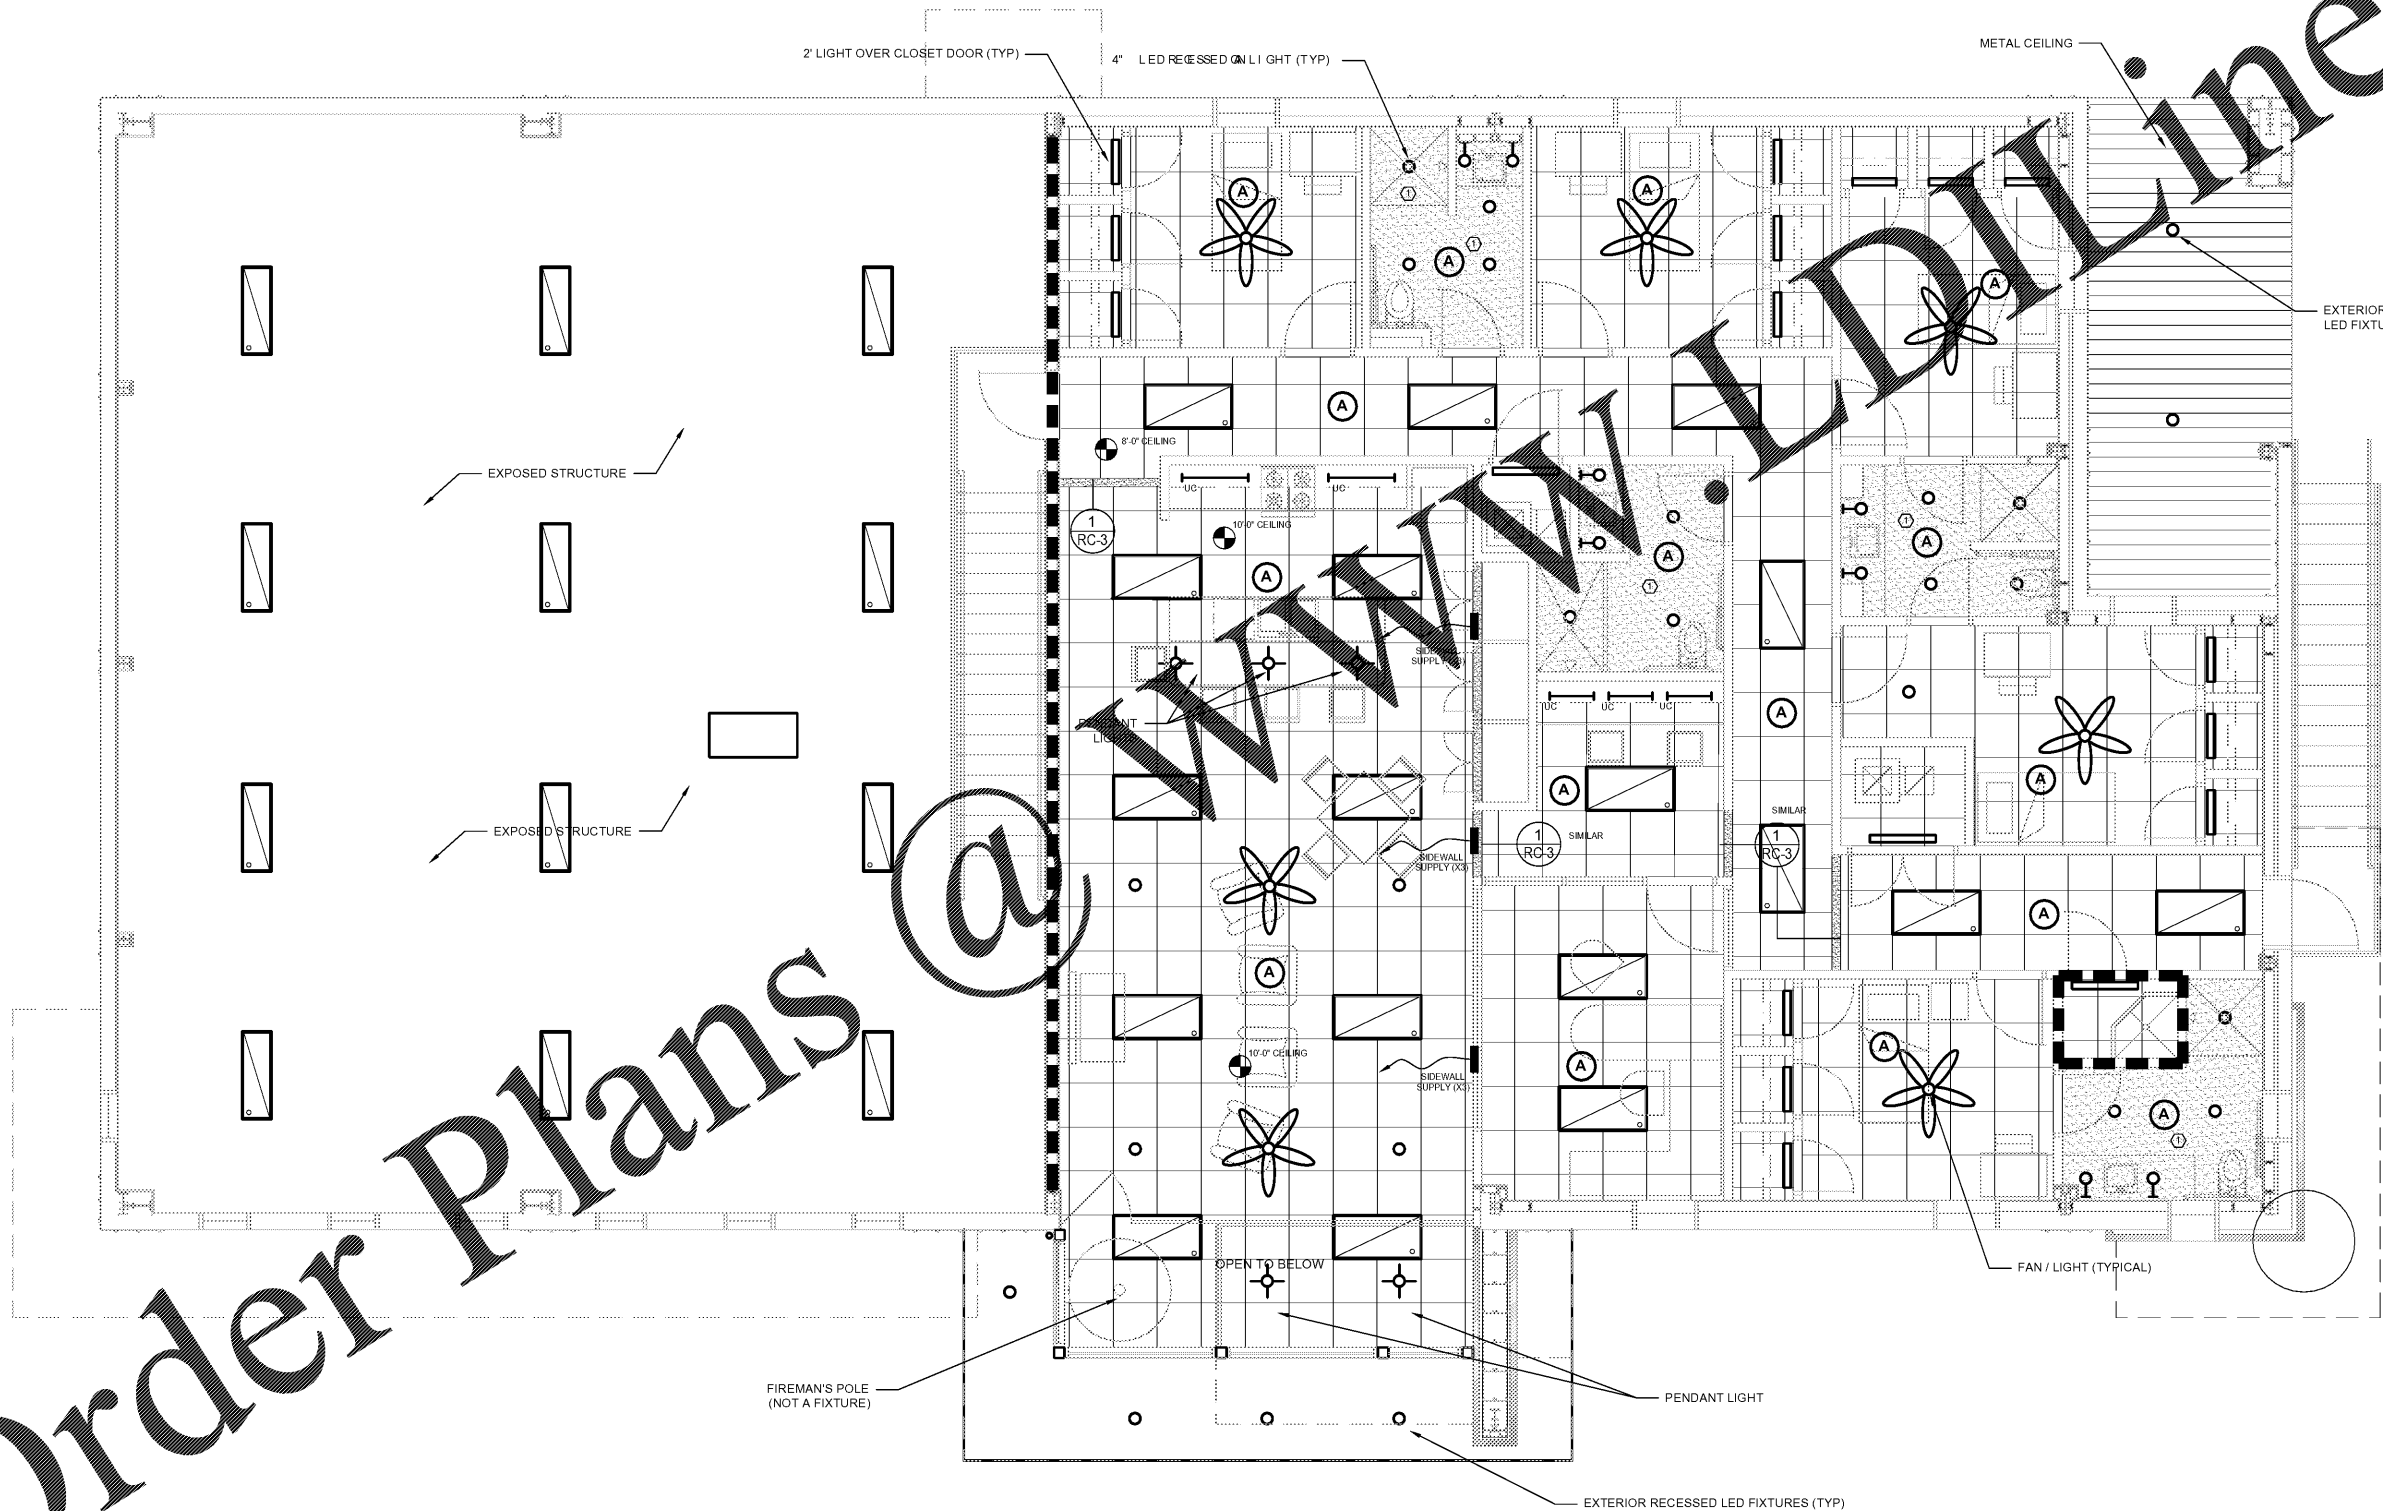

 ① SECOND FLOOR REFLECTED CEILING PLAN
 SCALE: 1/4" = 1'-0"



Order Plans @ www.weldline.com