


KEYNOTES  
 ① 12" WATER RESISTANT GYPSUM BOARD CEILING ON 2X6S @ 16" O.C.

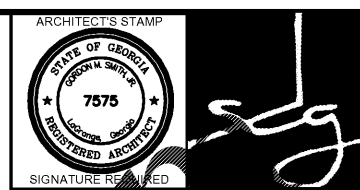

SMITH DESIGN GROUP, INC.  
 20 WEST JACKSON STREET  
 LAGRANGE, GEORGIA 30240  
 706-882-5511 www.SDGarch.net

**LEGEND**

- CEILING FAN LIGHT COMBO
- DECORATIVE PENDANT HUNG FIXTURE
- WALL MOUNTED DECORATIVE LIGHT
- 2X4 LED LAY-IN FIXTURE
- 2X2 LED LAY-IN FIXTURE
- 1X4 LED CEILING MOUNTED FIXTURE
- 8'-0" HANGING LED
- WALL SCONCE EACH SIDE OF MIRROR MOUNT AT 5'-6" A.F.F., SEE INTERIOR ELEVATIONS
- 4" RECESSED LED CANS ON DIMMER
- 4" RECESSED LED CANS
- 3' LONG UNDER CABINET LIGHTS
- 2'-0" OR 3'-0" WALL MOUNTED LIGHT IN CLOSET AREAS ABOVE DOOR
- 2X2 LAY-IN CEILING AND GRID
- FLUSH MOUNTED SPEAKER (CEILING MOUNT) SEE REFLECTED CEILING PLAN.
- RATED WALL - EXTEND TIGHT AGAINST FLOOR OR ROOF DECK ABOVE. SEAL ALL PENETRATIONS.


**REVISIONS**

DATE	DESCRIPTION


PROJECT:  
**VERNON ROAD FIRE STATION**  
 VERNON ROAD  
 LAGRANGE GEORGIA

TITLE:  
**SECOND FLOOR PLAN  
 REFLECTED CEILING PLAN**

MODIFIED DATE:	JOB NO: <b>1731</b>
ISSUED DATE: FOR BID AND PERMIT 07 MAY 2018	SHEET: <b>RC-2</b>

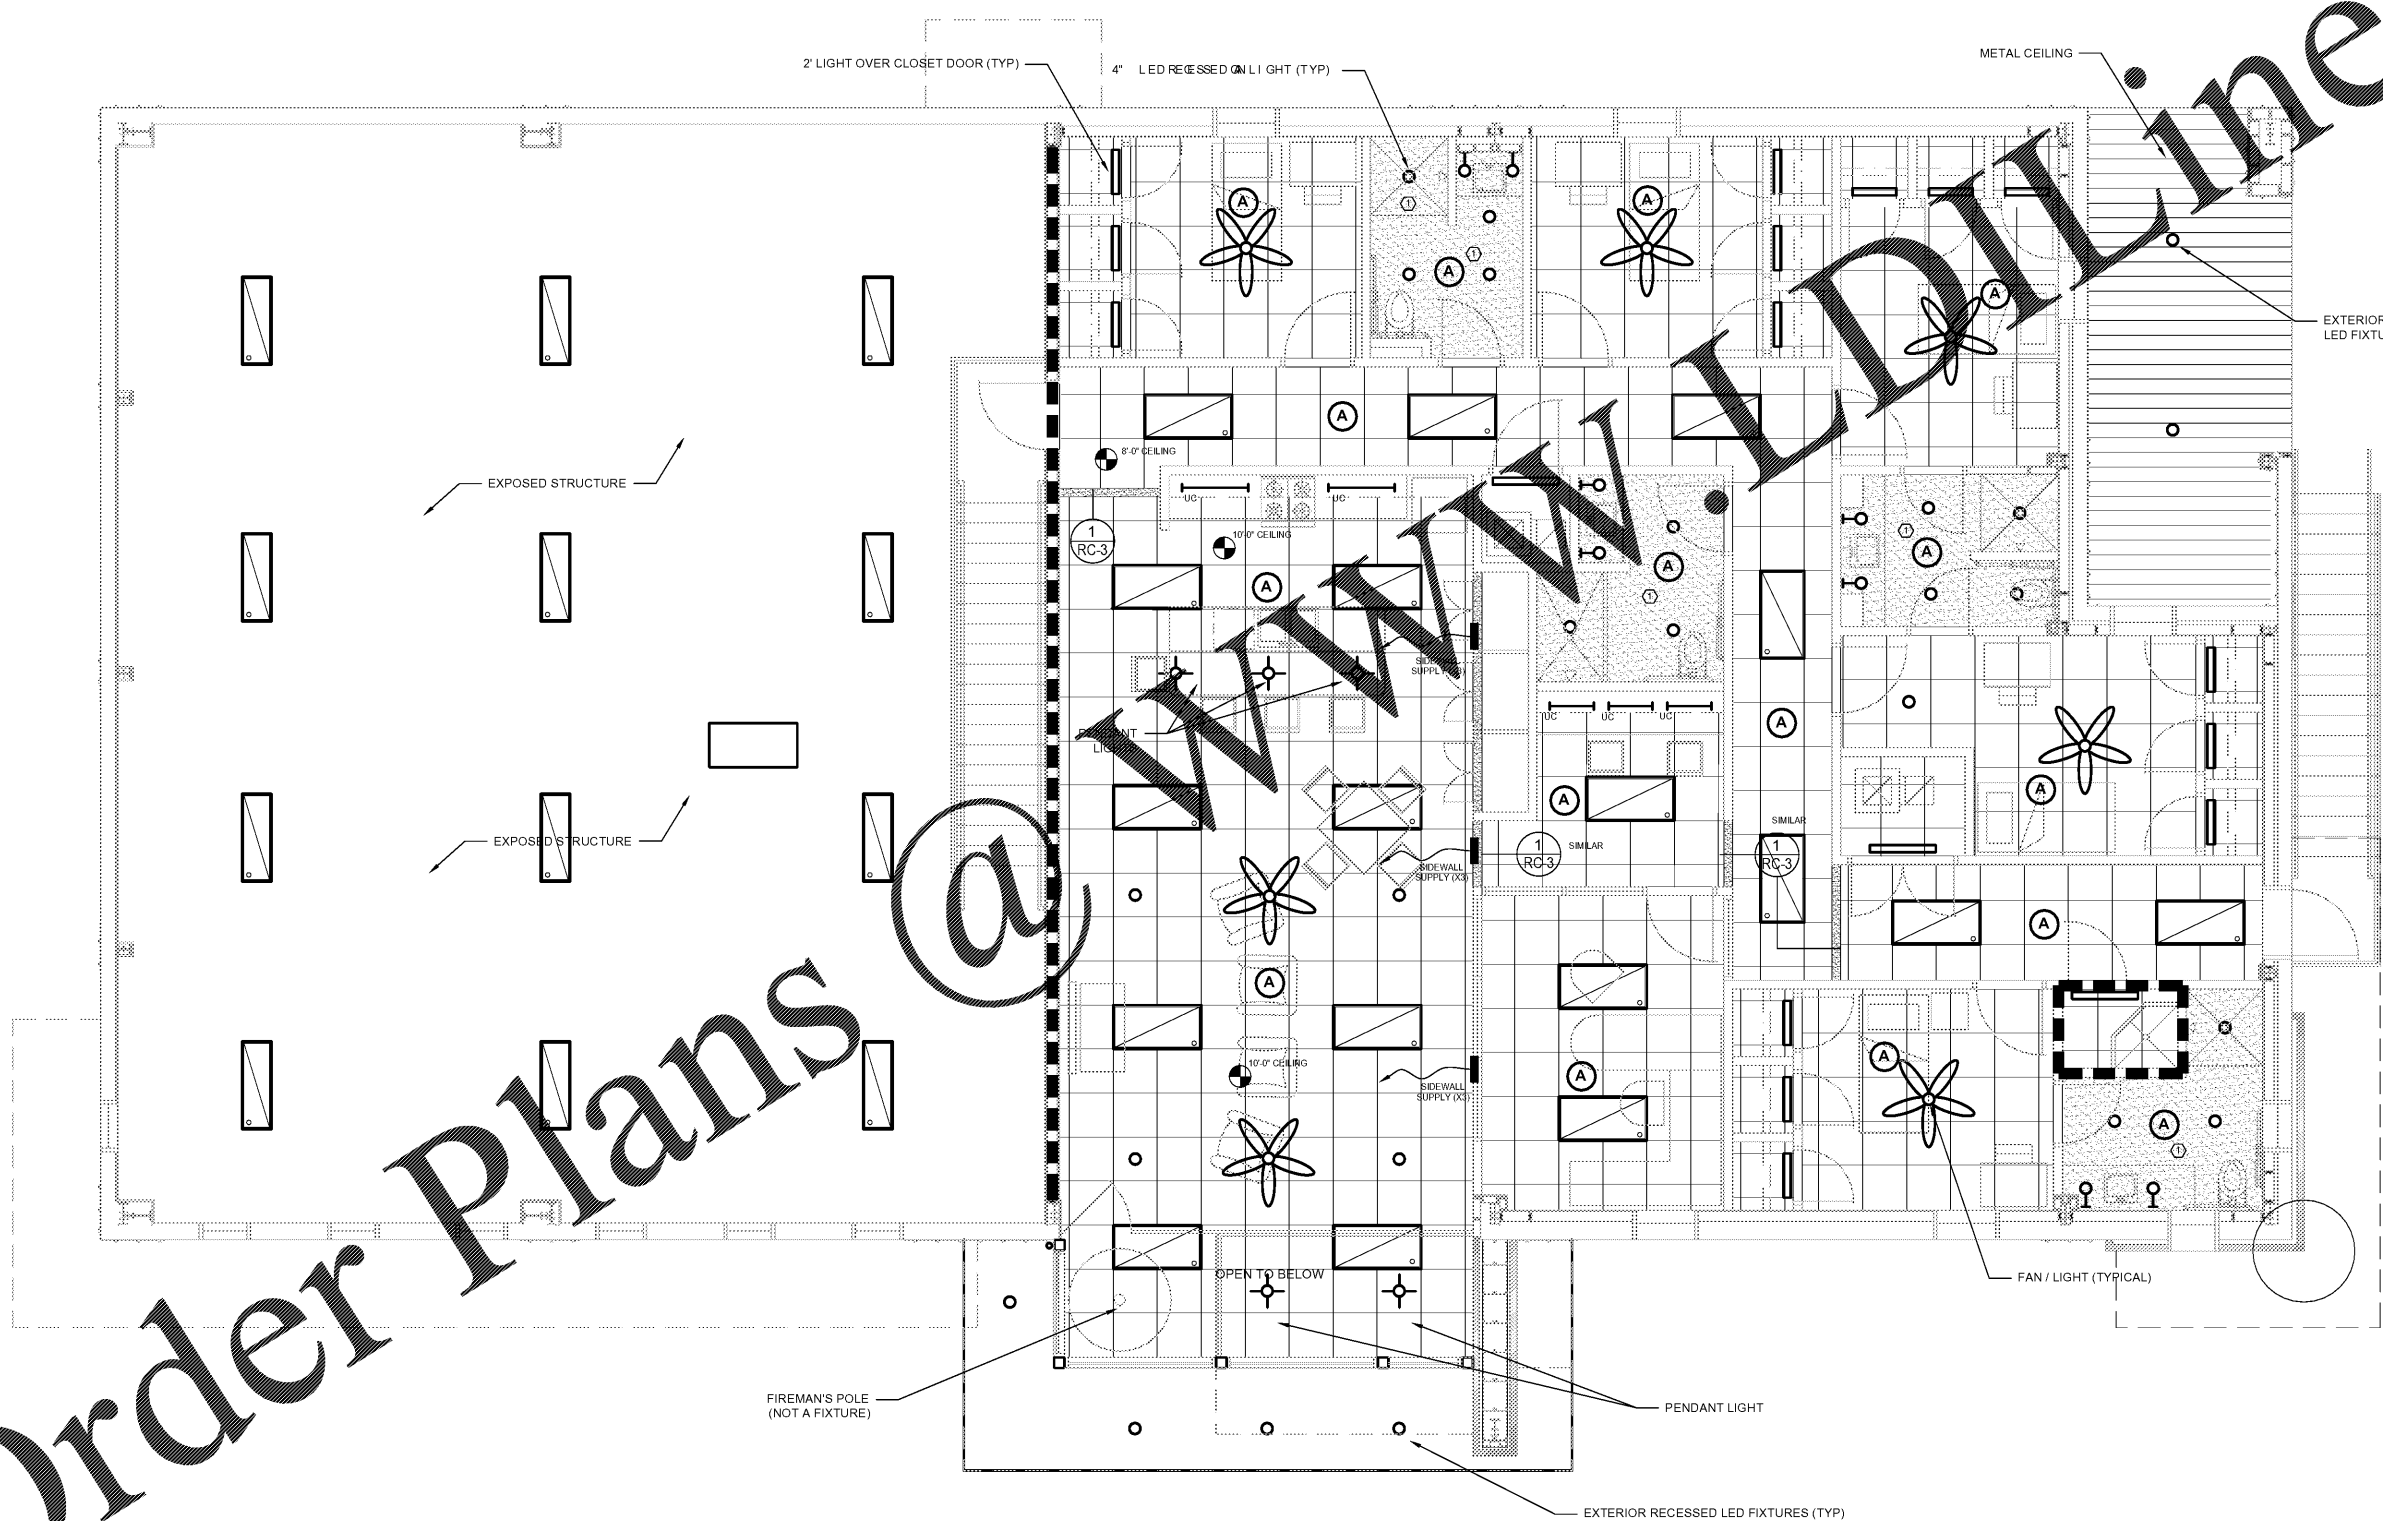

 ① **SECOND FLOOR REFLECTED CEILING PLAN**  
 SCALE: 1/4" = 1'-0"



Order Plans @ [www.weldline.com](http://www.weldline.com)