


KEYNOTES  
 KEYNOTES KEYNOTES KEYNOTES

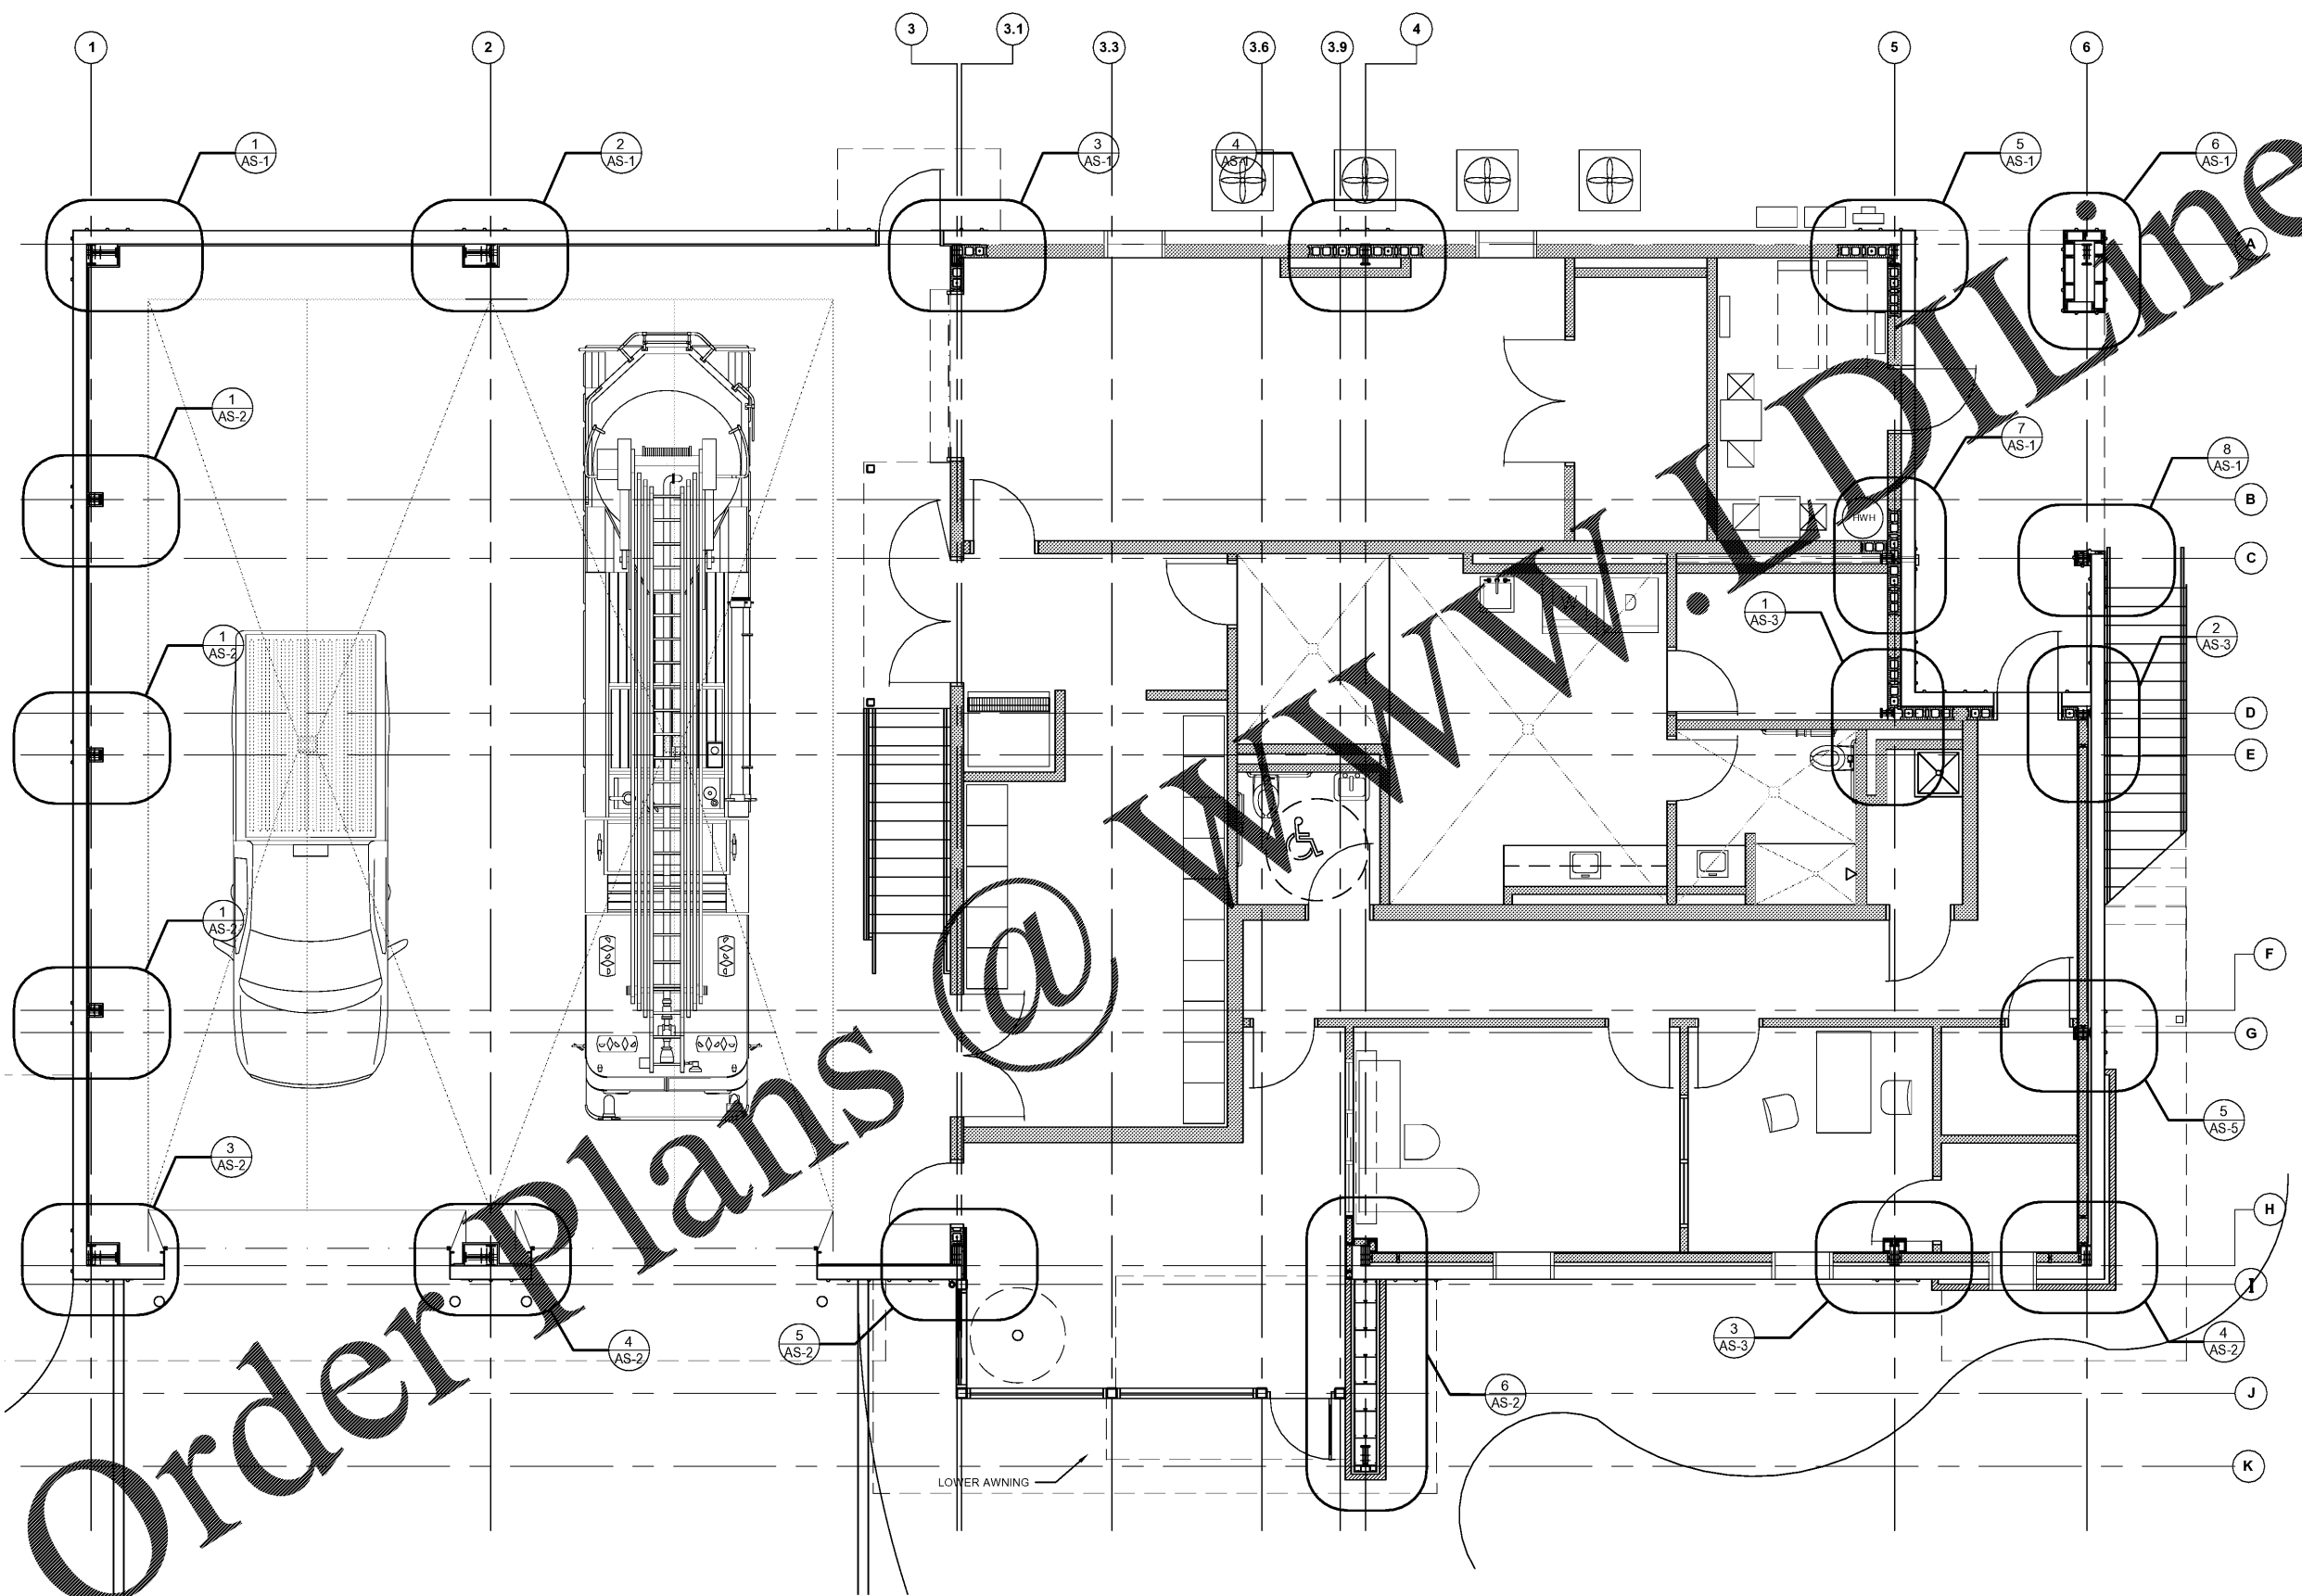

SIGNATURE REQUIRED  
 SMITH DESIGN GROUP, INC.  
 206 WEST HAMILTON STREET  
 LAGRANGE, GEORGIA 30240  
 770-882-5511 www.SDGarch.net



REVISIONS	
DATE	DESCRIPTION

PROJECT:  
 VERNON ROAD FIRE STATION  
 VERNON ROAD  
 LAGRANGE GEORGIA

TITLE:  
 COLUMN DETAIL  
 REFERENCE FLOOR PLAN

MODIFIED DATE:	JOB NO: 1731
ISSUED DATE: FOR BID AND PERMIT 07 MAY 2018	SHEET: AS-6

1 AS-6 COLUMN DETAIL REFERENCE FLOOR PLAN  
 SCALE: 1/4" = 1'-0"

Order Plans