


KEYNOTES  
① KEYNOTES KEYNOTES KEYNOTES

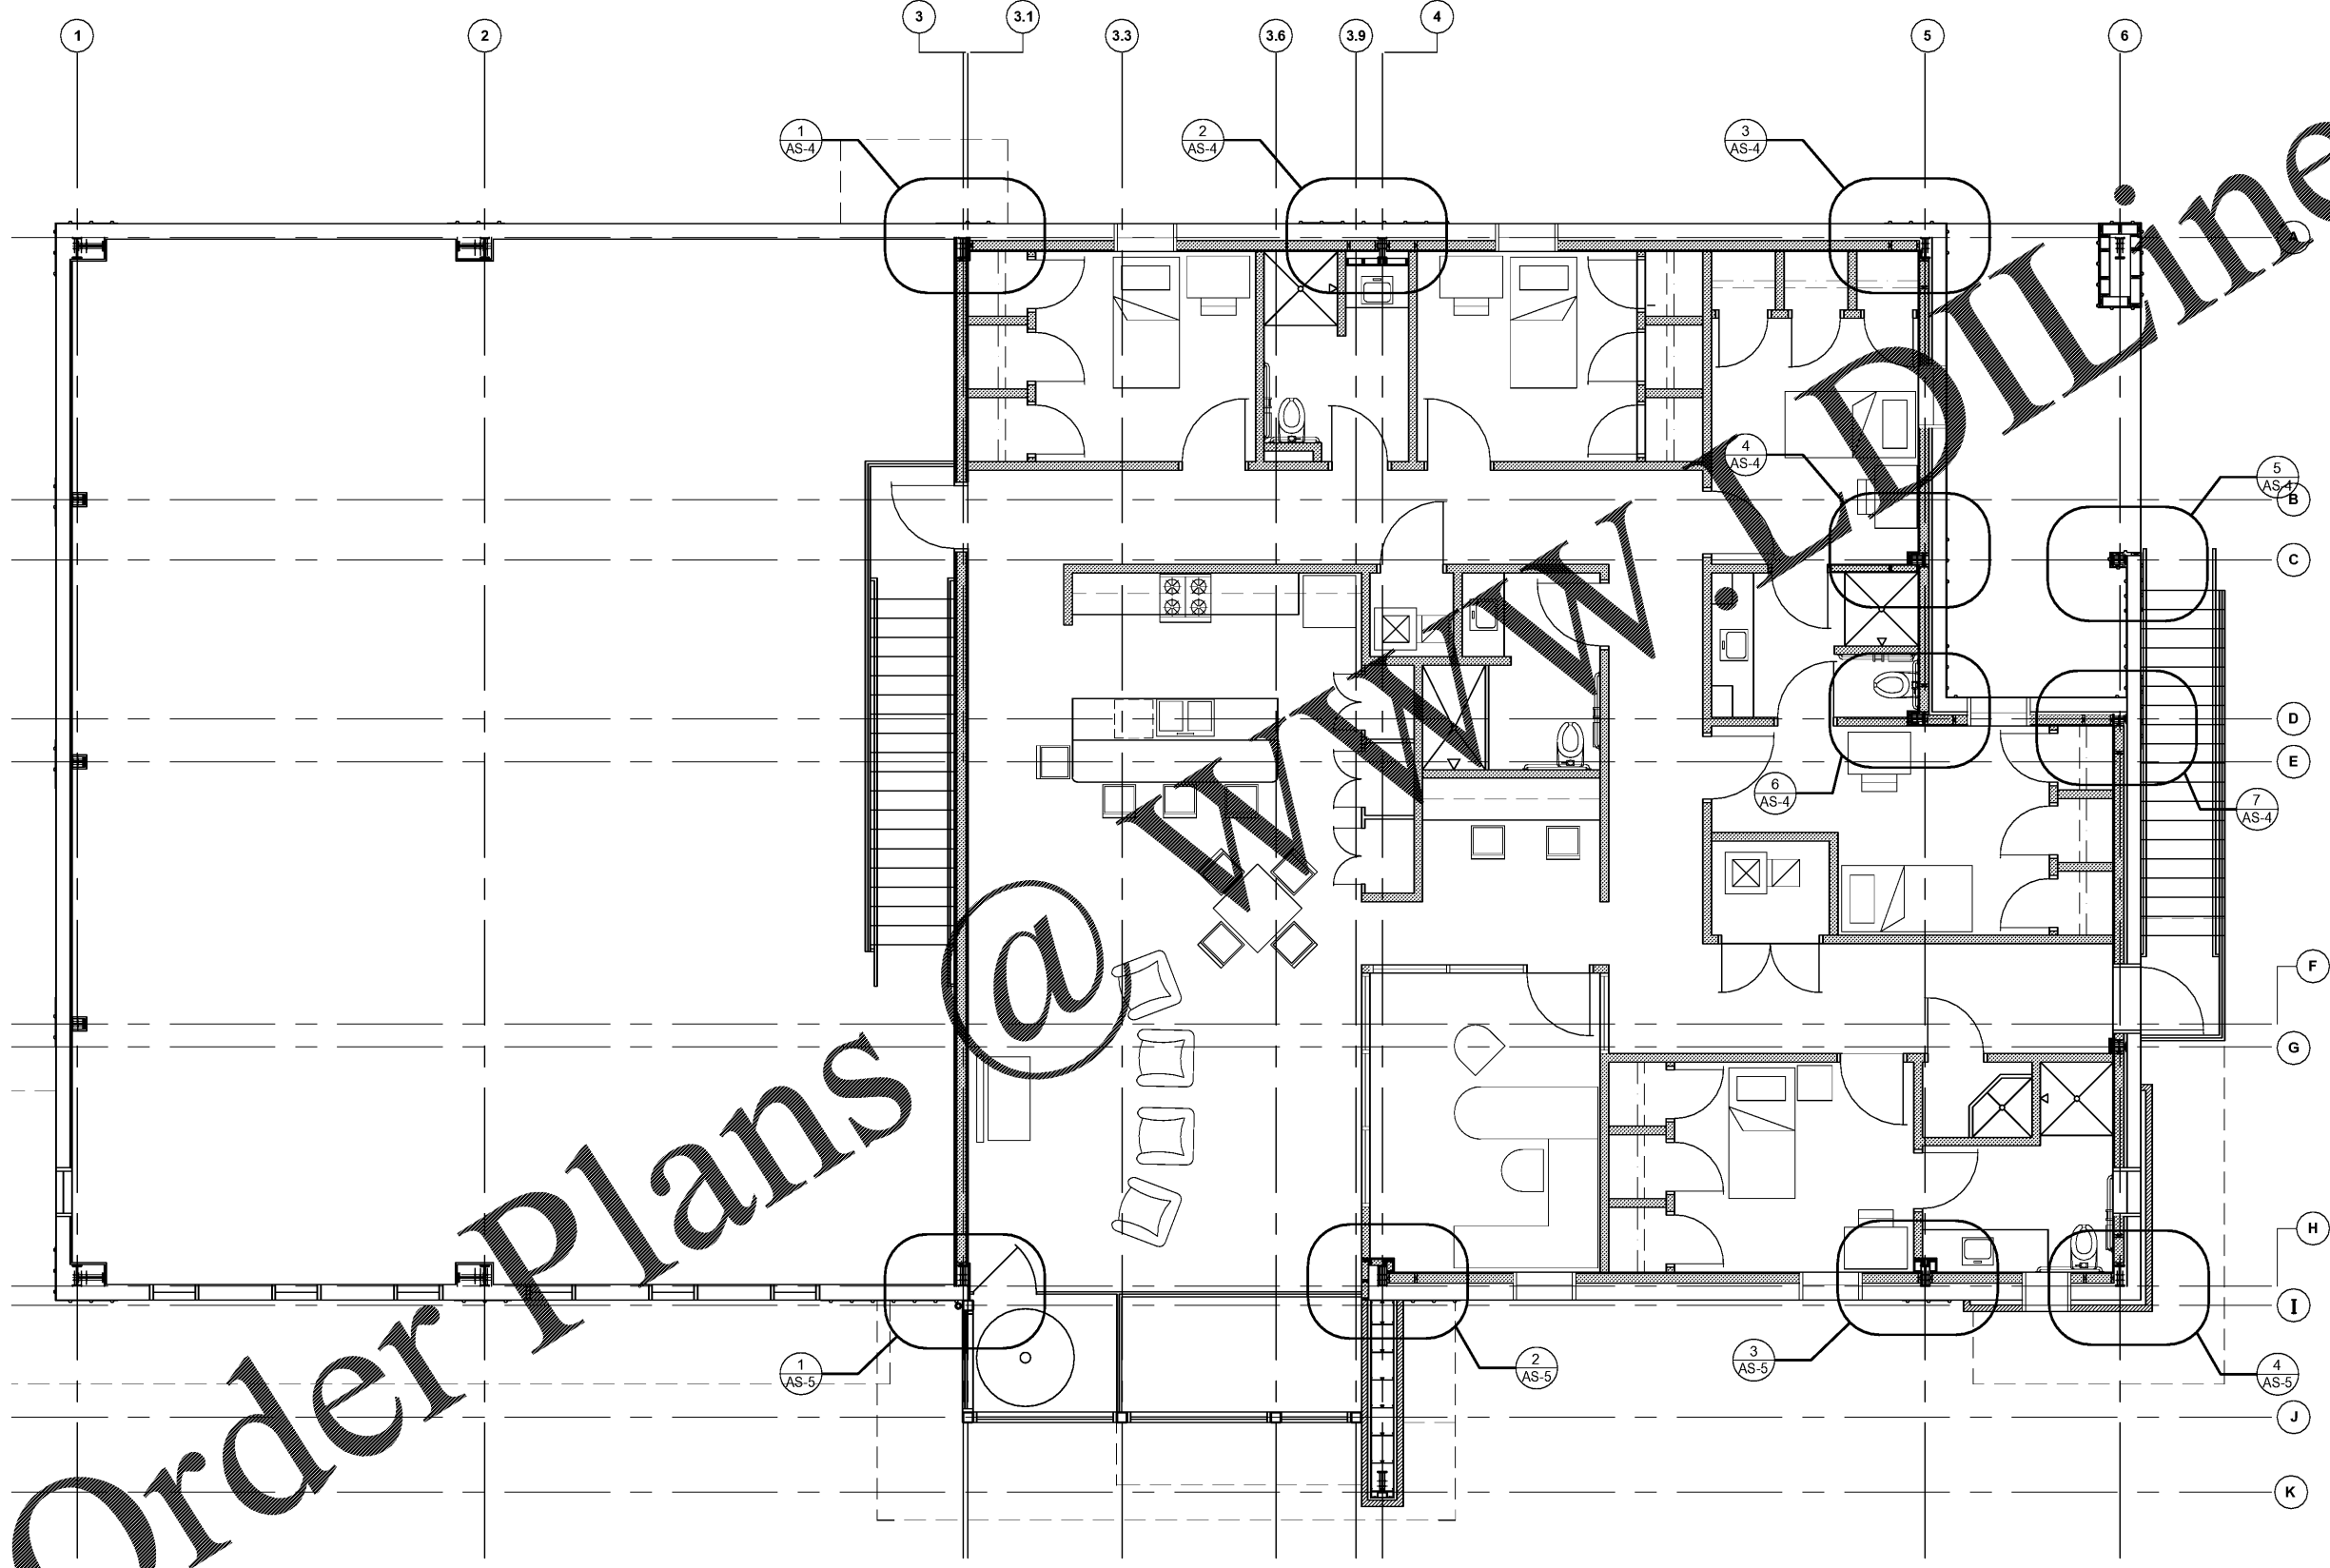

**SMITH DESIGN GROUP, INC.**  
20 WEST HAWKSON STREET  
LAGRANGE, GEORGIA 30240  
706-882-5511 www.SDGarch.net



REVISIONS	
△ DATE	DESCRIPTION

PROJECT:  
**VERNON ROAD FIRE STATION**  
VERNON ROAD  
LAGRANGE GEORGIA

TITLE:  
**COLUMN DETAIL  
REFERENCE FLOOR PLAN**

MODIFIED DATE:	JOB NO: <b>1731</b>
ISSUED DATE: FOR BID AND PERMIT 07 MAY 2018	SHEET: <b>AS-7</b>

① **COLUMN DETAIL REFERENCE FLOOR PLAN**  
SCALE: 1/4" = 1'-0"

Order Plans @ [www.dline.com](http://www.dline.com)