


KEYNOTES
① KEYNOTES KEYNOTES KEYNOTES

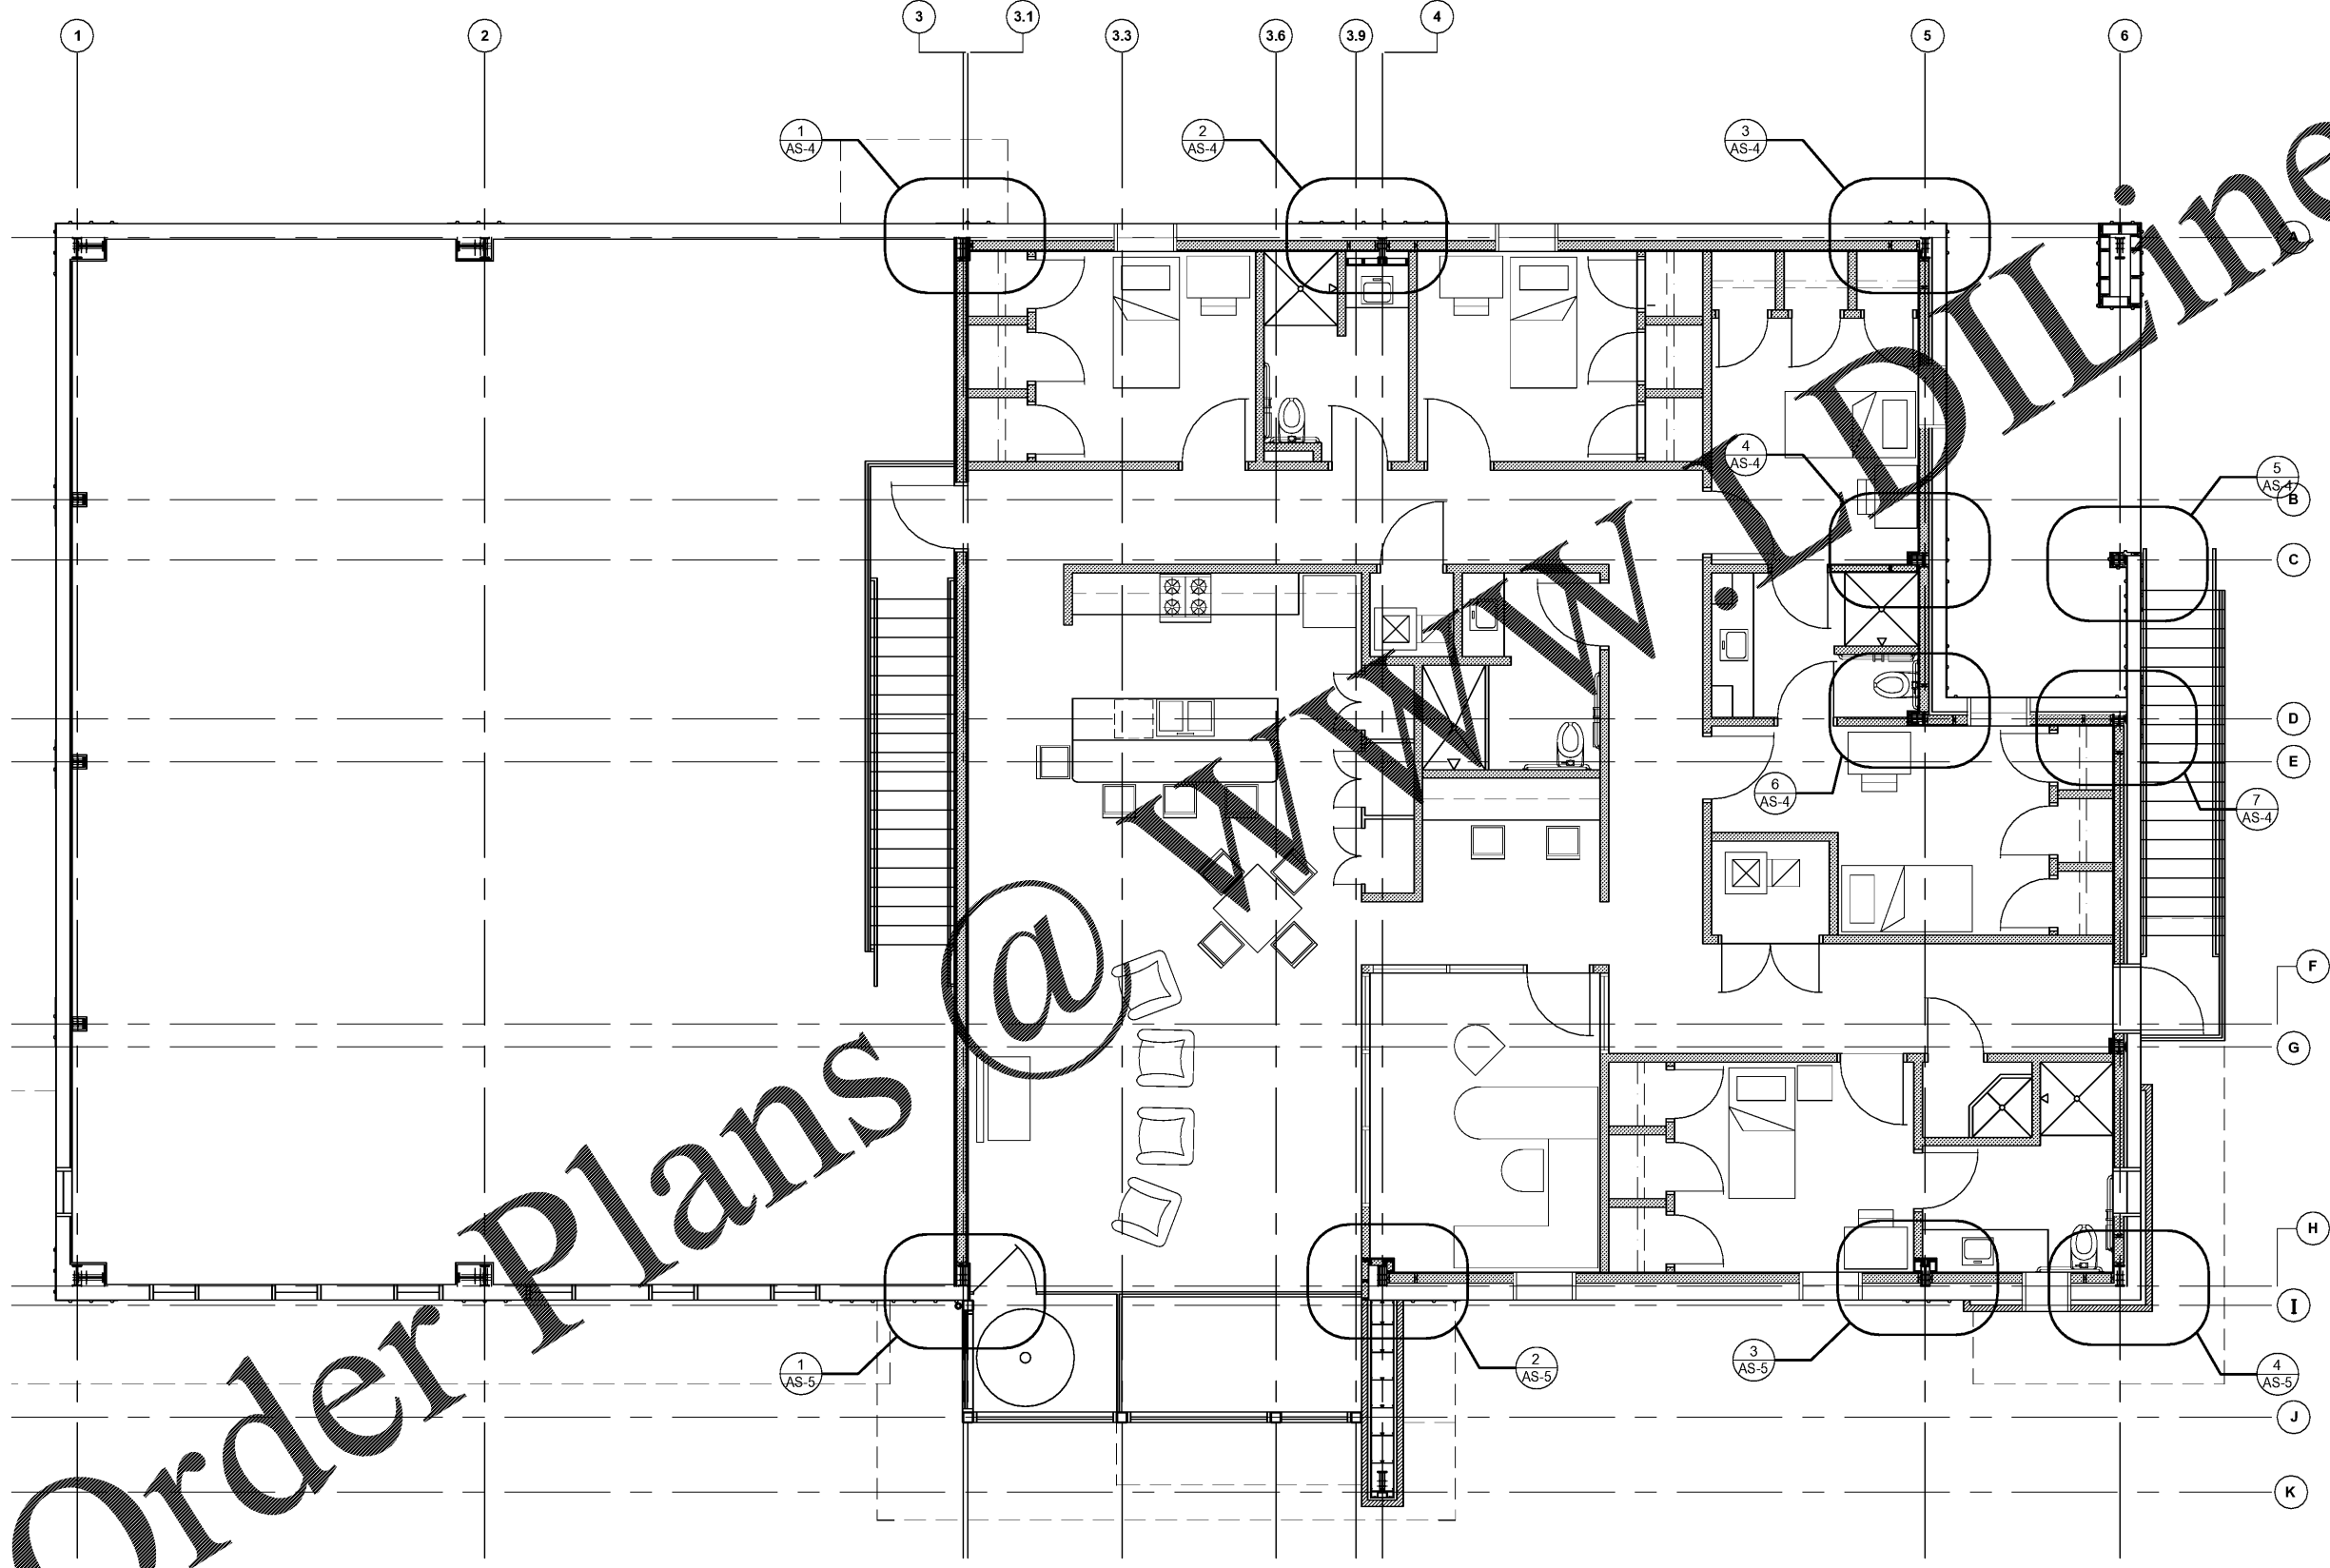

SMITH DESIGN GROUP, INC.
20 WEST HAWKSON STREET
LAGRANGE, GEORGIA 30240
706-882-5511 www.SDGarch.net



REVISIONS	
DATE	DESCRIPTION

PROJECT:
VERNON ROAD FIRE STATION
VERNON ROAD
LAGRANGE GEORGIA

TITLE:
**COLUMN DETAIL
REFERENCE FLOOR PLAN**

MODIFIED DATE:	JOB NO: 1731
ISSUED DATE: FOR BID AND PERMIT 07 MAY 2018	SHEET: AS-7

① **COLUMN DETAIL REFERENCE FLOOR PLAN**
SCALE: 1/4" = 1'-0"

Order Plans @ www.dline.com