



SMITH DESIGN GROUP, INC.  
 20 WEST HUNTERSON STREET  
 LAGRANGE, GEORGIA 30240  
 706-882-5511 www.SDGarch.net

LEGEND

- ⊕ HOSE BIBB
- COLD WATER
- - - - - HOT WATER
- GAS PIPING

REVISIONS

DATE	DESCRIPTION


PROJECT:  
**VERNON ROAD FIRE STATION**  
 VERNON ROAD  
 LAGRANGE GEORGIA

TITLE:  
**PLUMBING PLAN  
 FIRST FLOOR**

MODIFIED DATE:	JOB NO: <b>1731</b>
ISSUED DATE: FOR BID AND PERMIT 07 MAY 2018	SHEET: <b>P-6</b>

**PLUMBING PLAN - FIRST FLOOR**  
 SCALE: 1/4" = 1'-0"

**NOTE:  
 BACKFLOW PREVENTOR AND  
 PRESSURE REDUCING VALVE  
 LOCATED AT STREET IN VAULT**

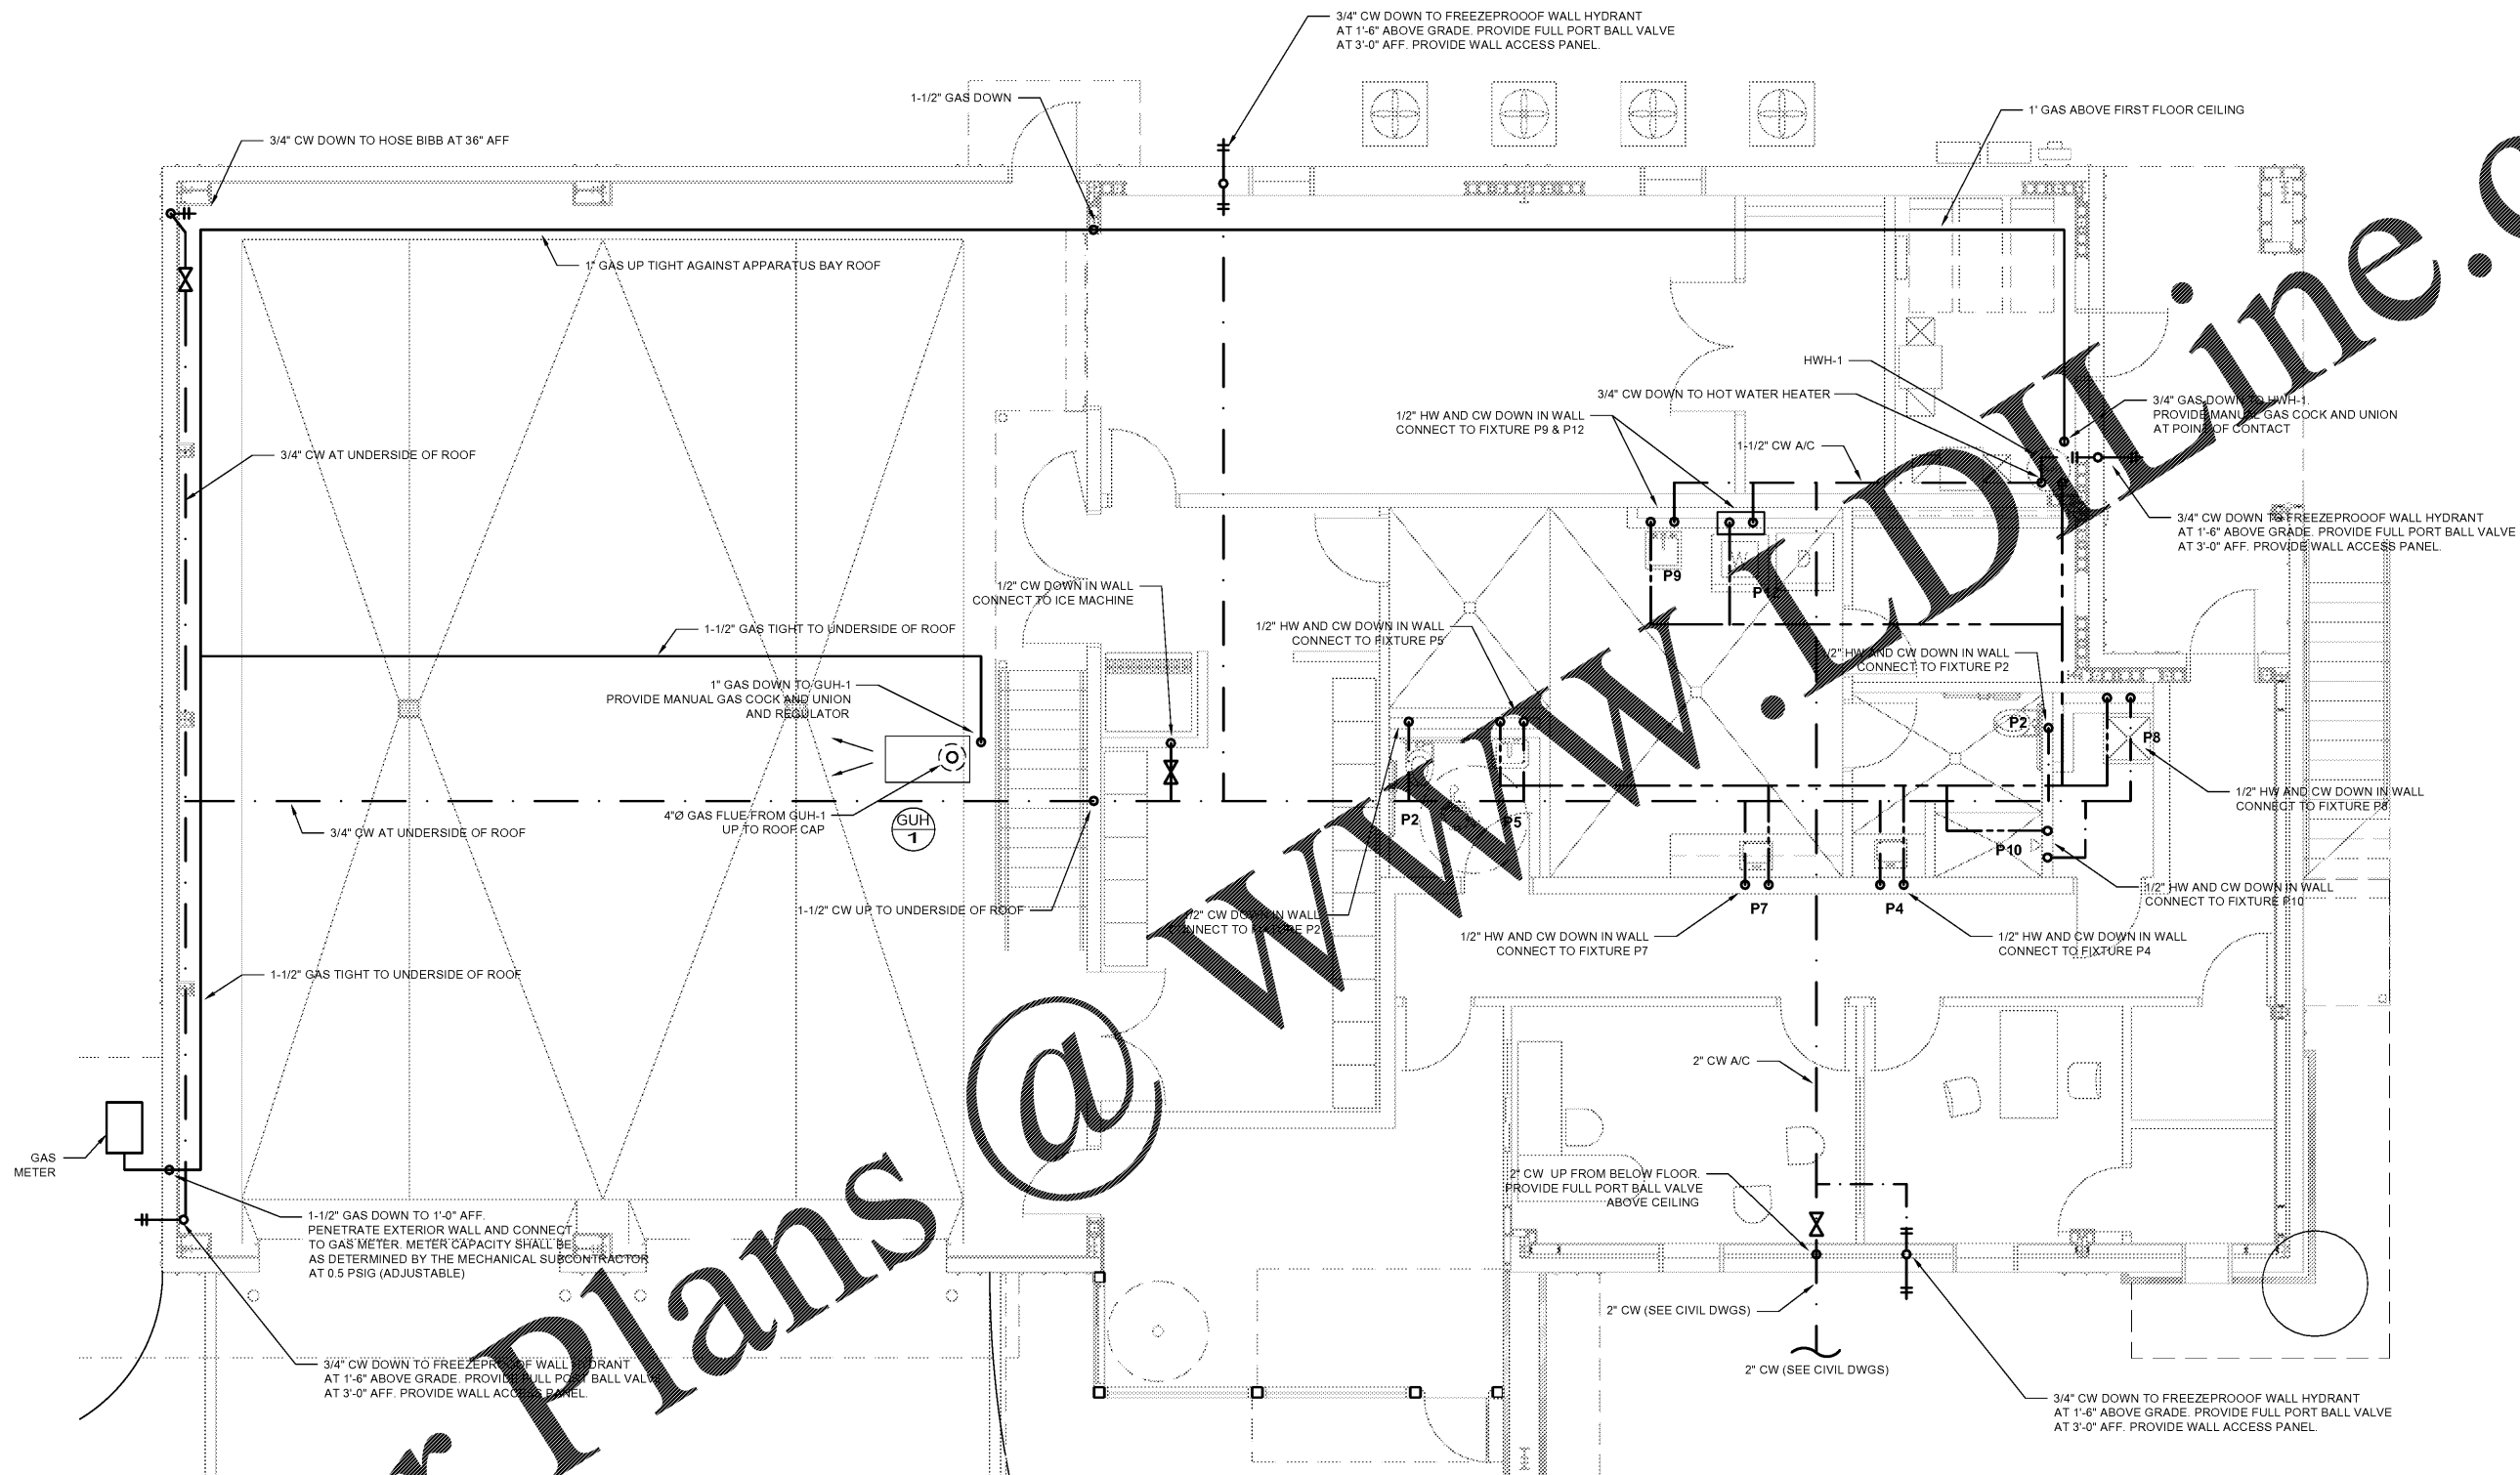

Order Plans @ www.Drillline.com